




ARCHITECTURE | INTERIOR DESIGN
zervasgroup.com
209 Prospect Street
Bellingham, WA 98225
360.734.4744

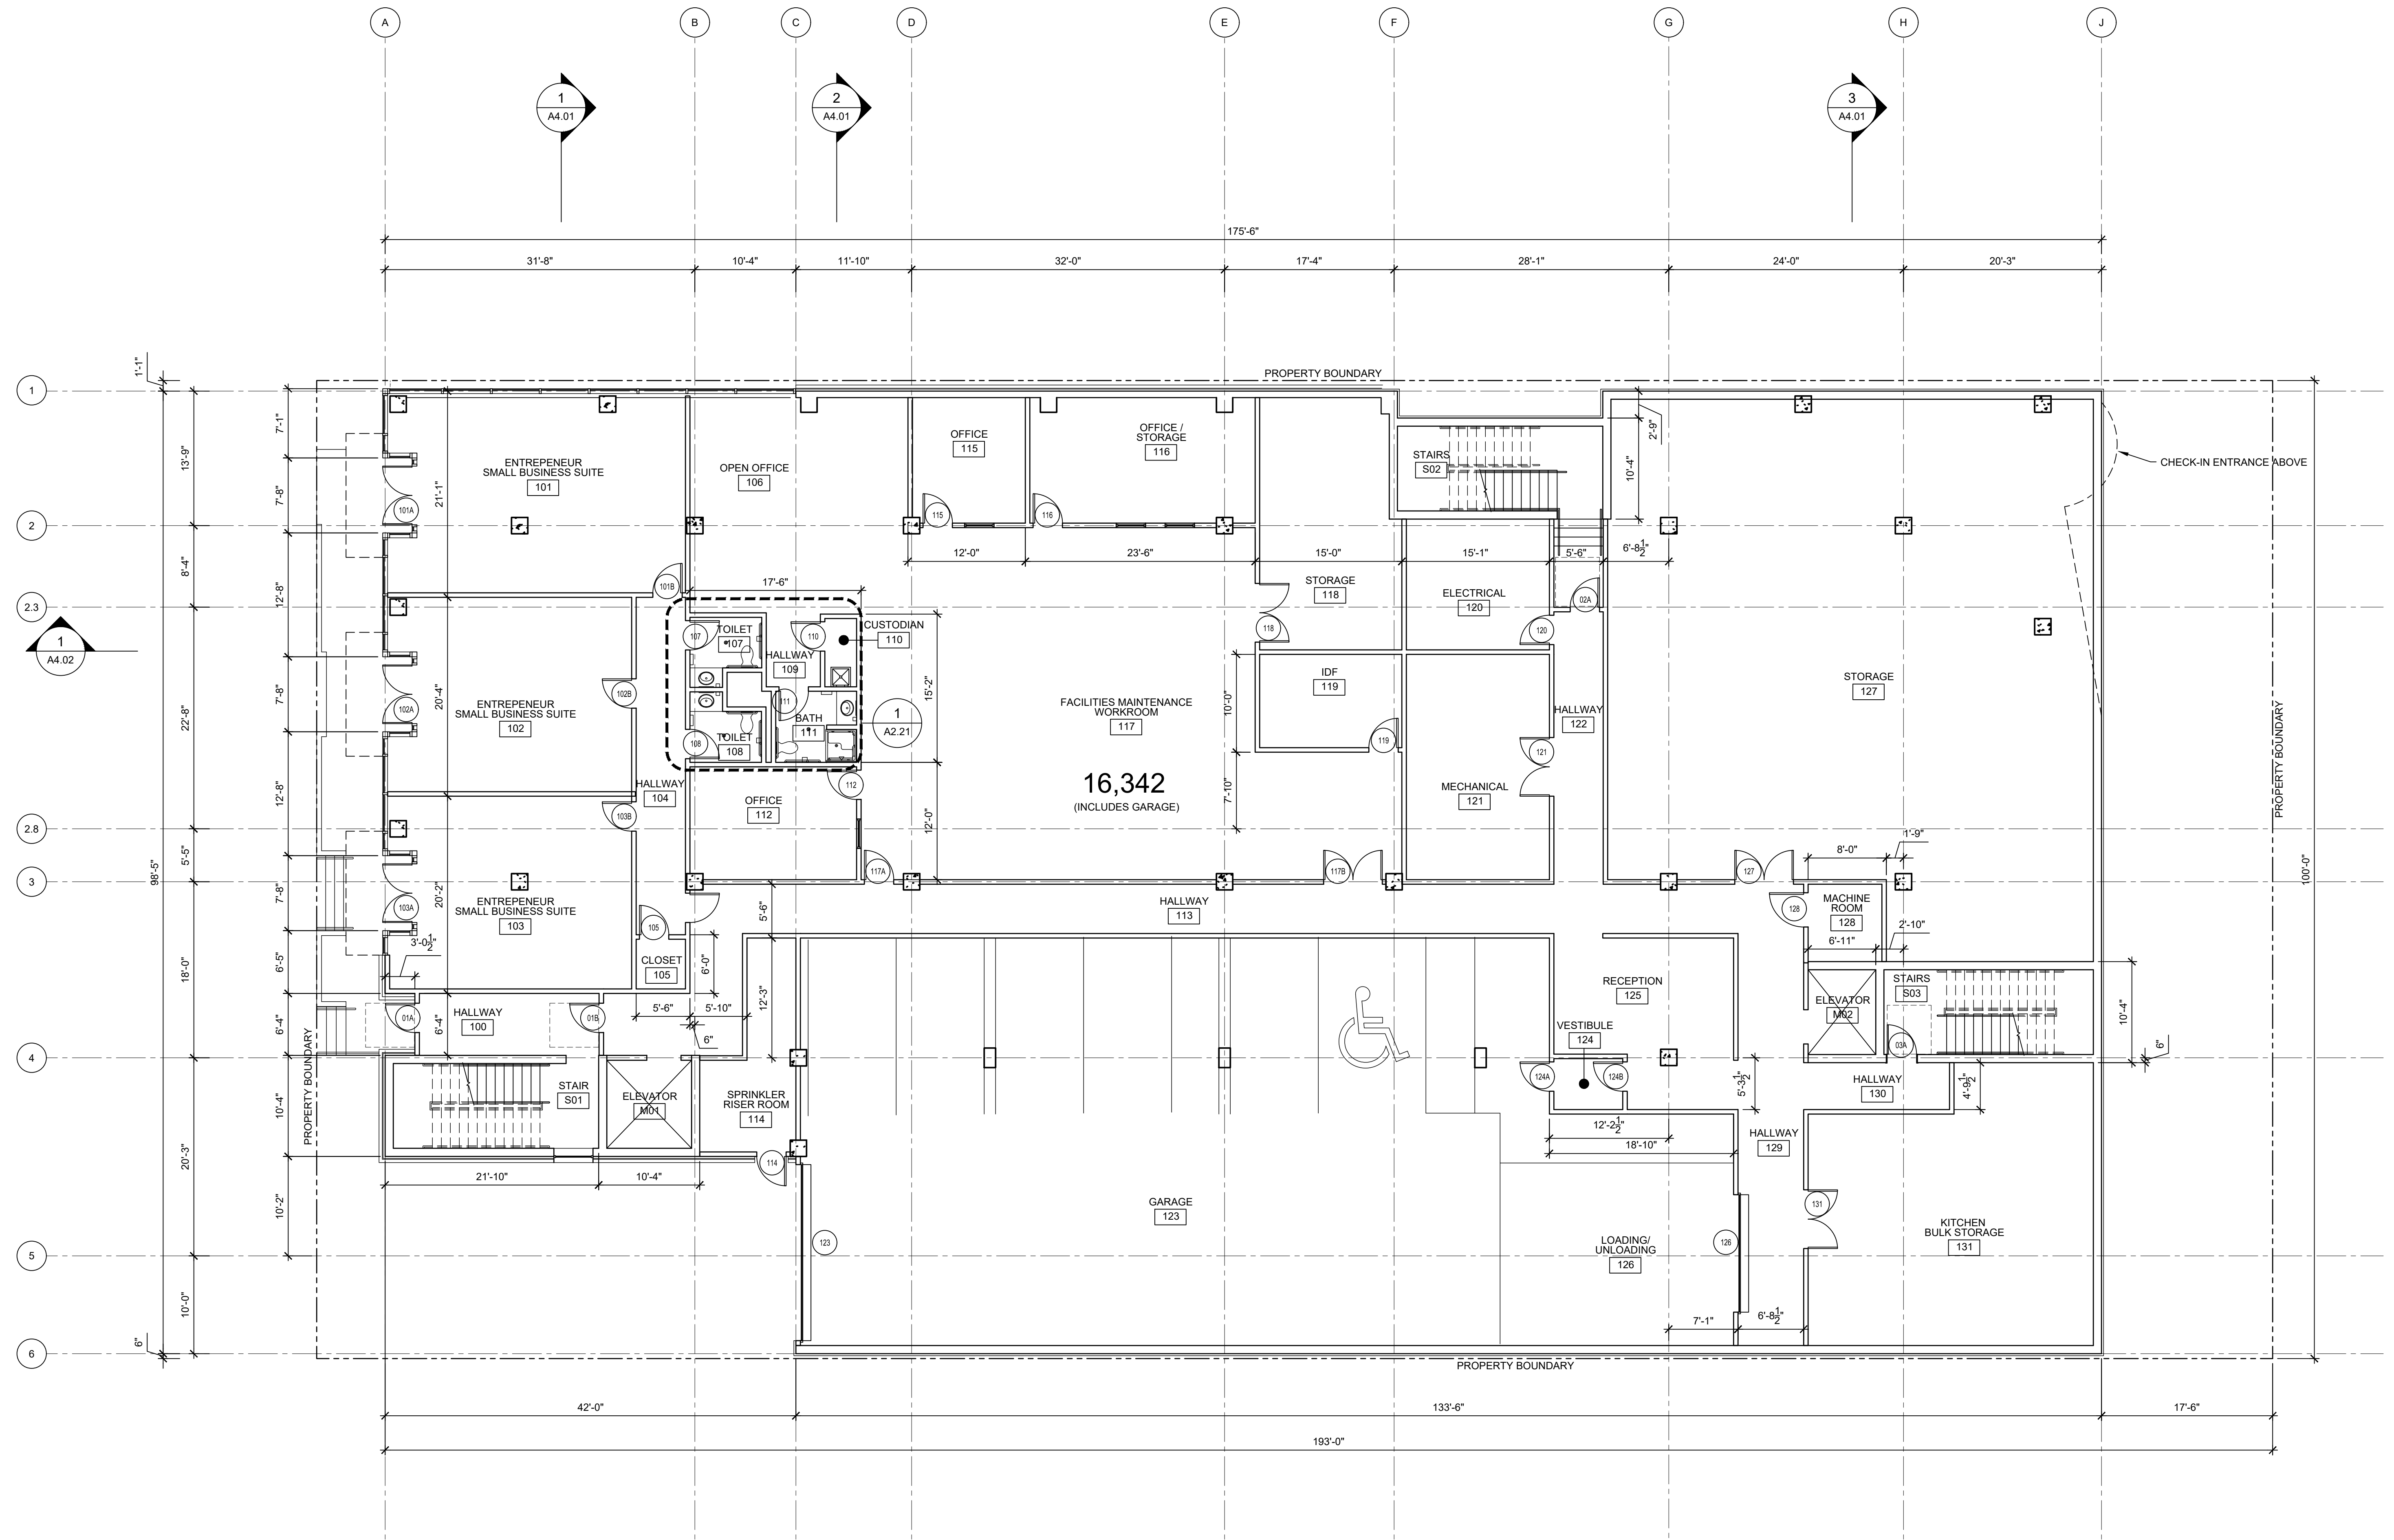

DESIGN DEVELOPMENT

REV	ISSUED FOR	DATE


PLAN NORTH


TRUE NORTH

SCALE: 1/8"=1'-0"


0 8'

LIGHTHOUSE MISSION RE-BUILD


FIRST FLOOR PLAN

PROJECT No: 202009.02
DRAWN BY: AK
CHECKED BY: AK
DATE ISSUED: 07.10.22

A2.01




ARCHITECTURE | INTERIOR DESIGN
zervasgroup.com
209 Prospect Street
Bellingham, WA 98225
360.734.4744

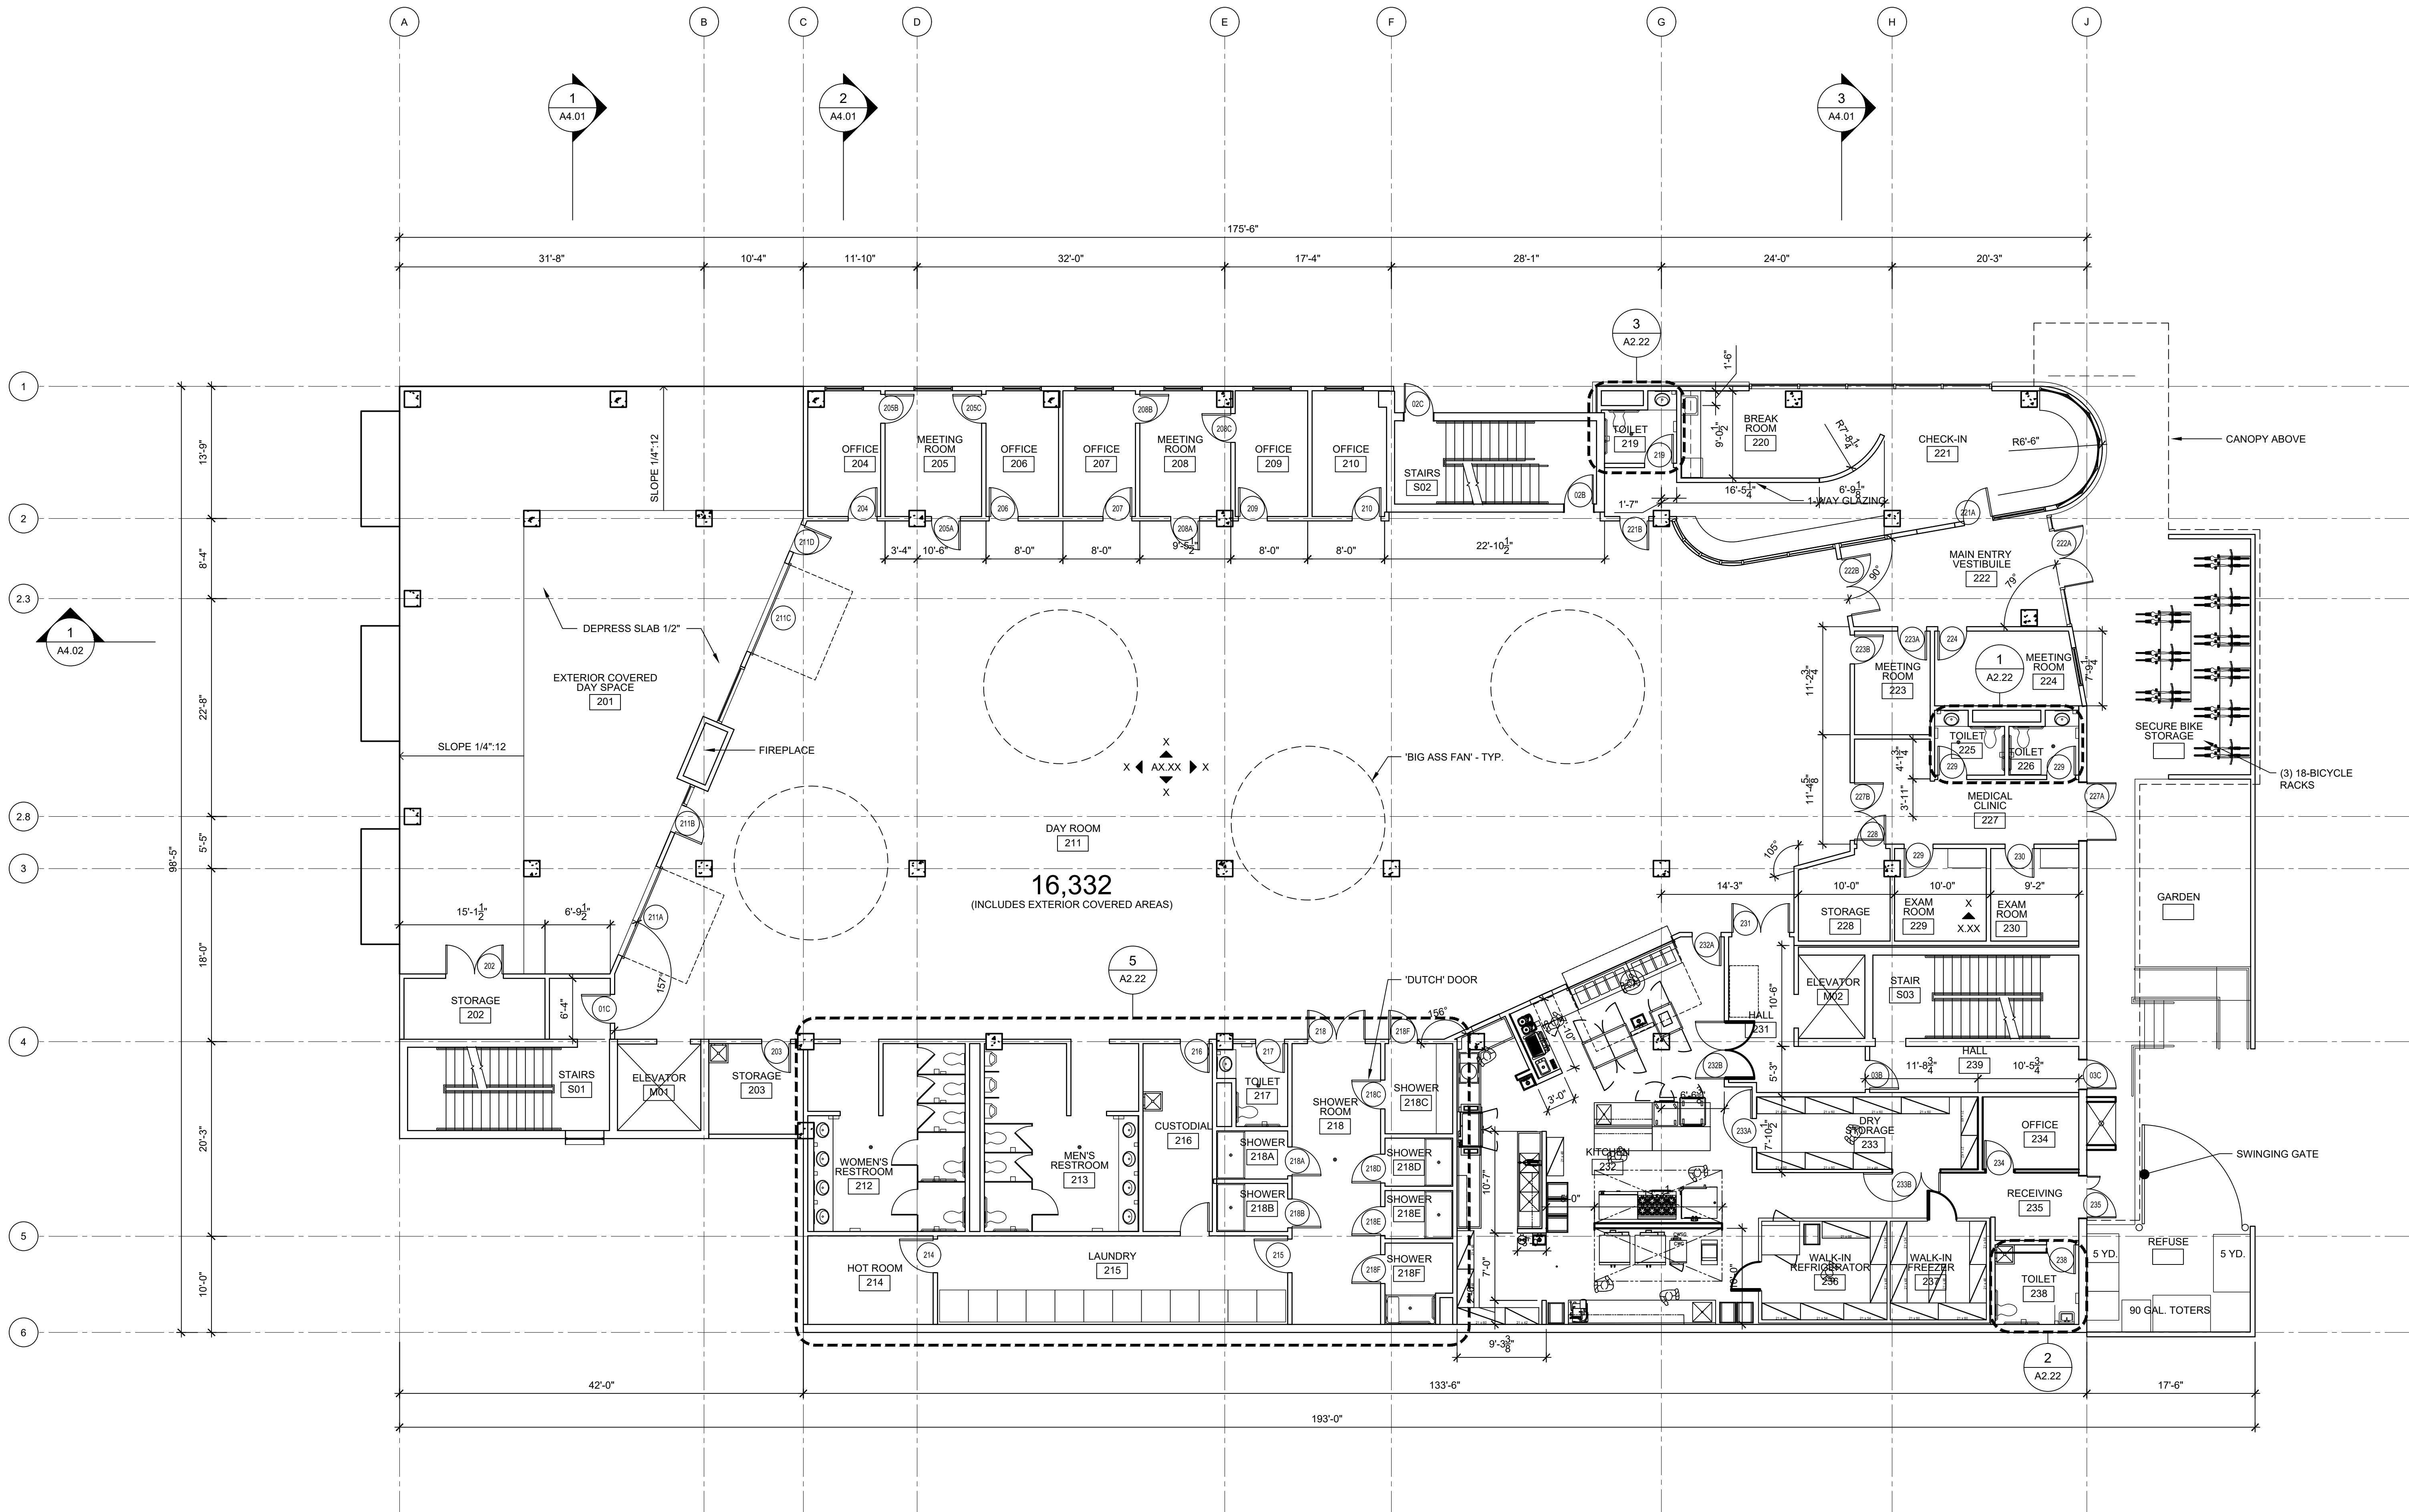

DESIGN DEVELOPMENT

REV	ISSUED FOR	DATE

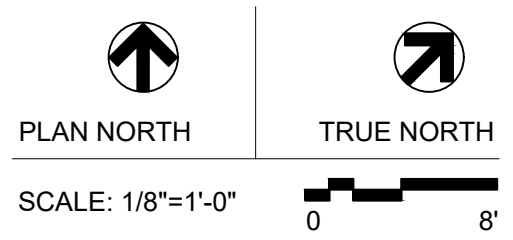

LIGHTHOUSE MISSION RE-BUILD


SECOND FLOOR AND PARTIAL SITE PLAN

PROJECT No: 202009.02
DRAWN BY: AK
CHECKED BY: AK
DATE ISSUED: 07.10.22

A2.02



ARCHITECTURE | INTERIOR DESIGN
zervasgroup.com
209 Prospect Street
Bellingham, WA 98225
360.734.4744

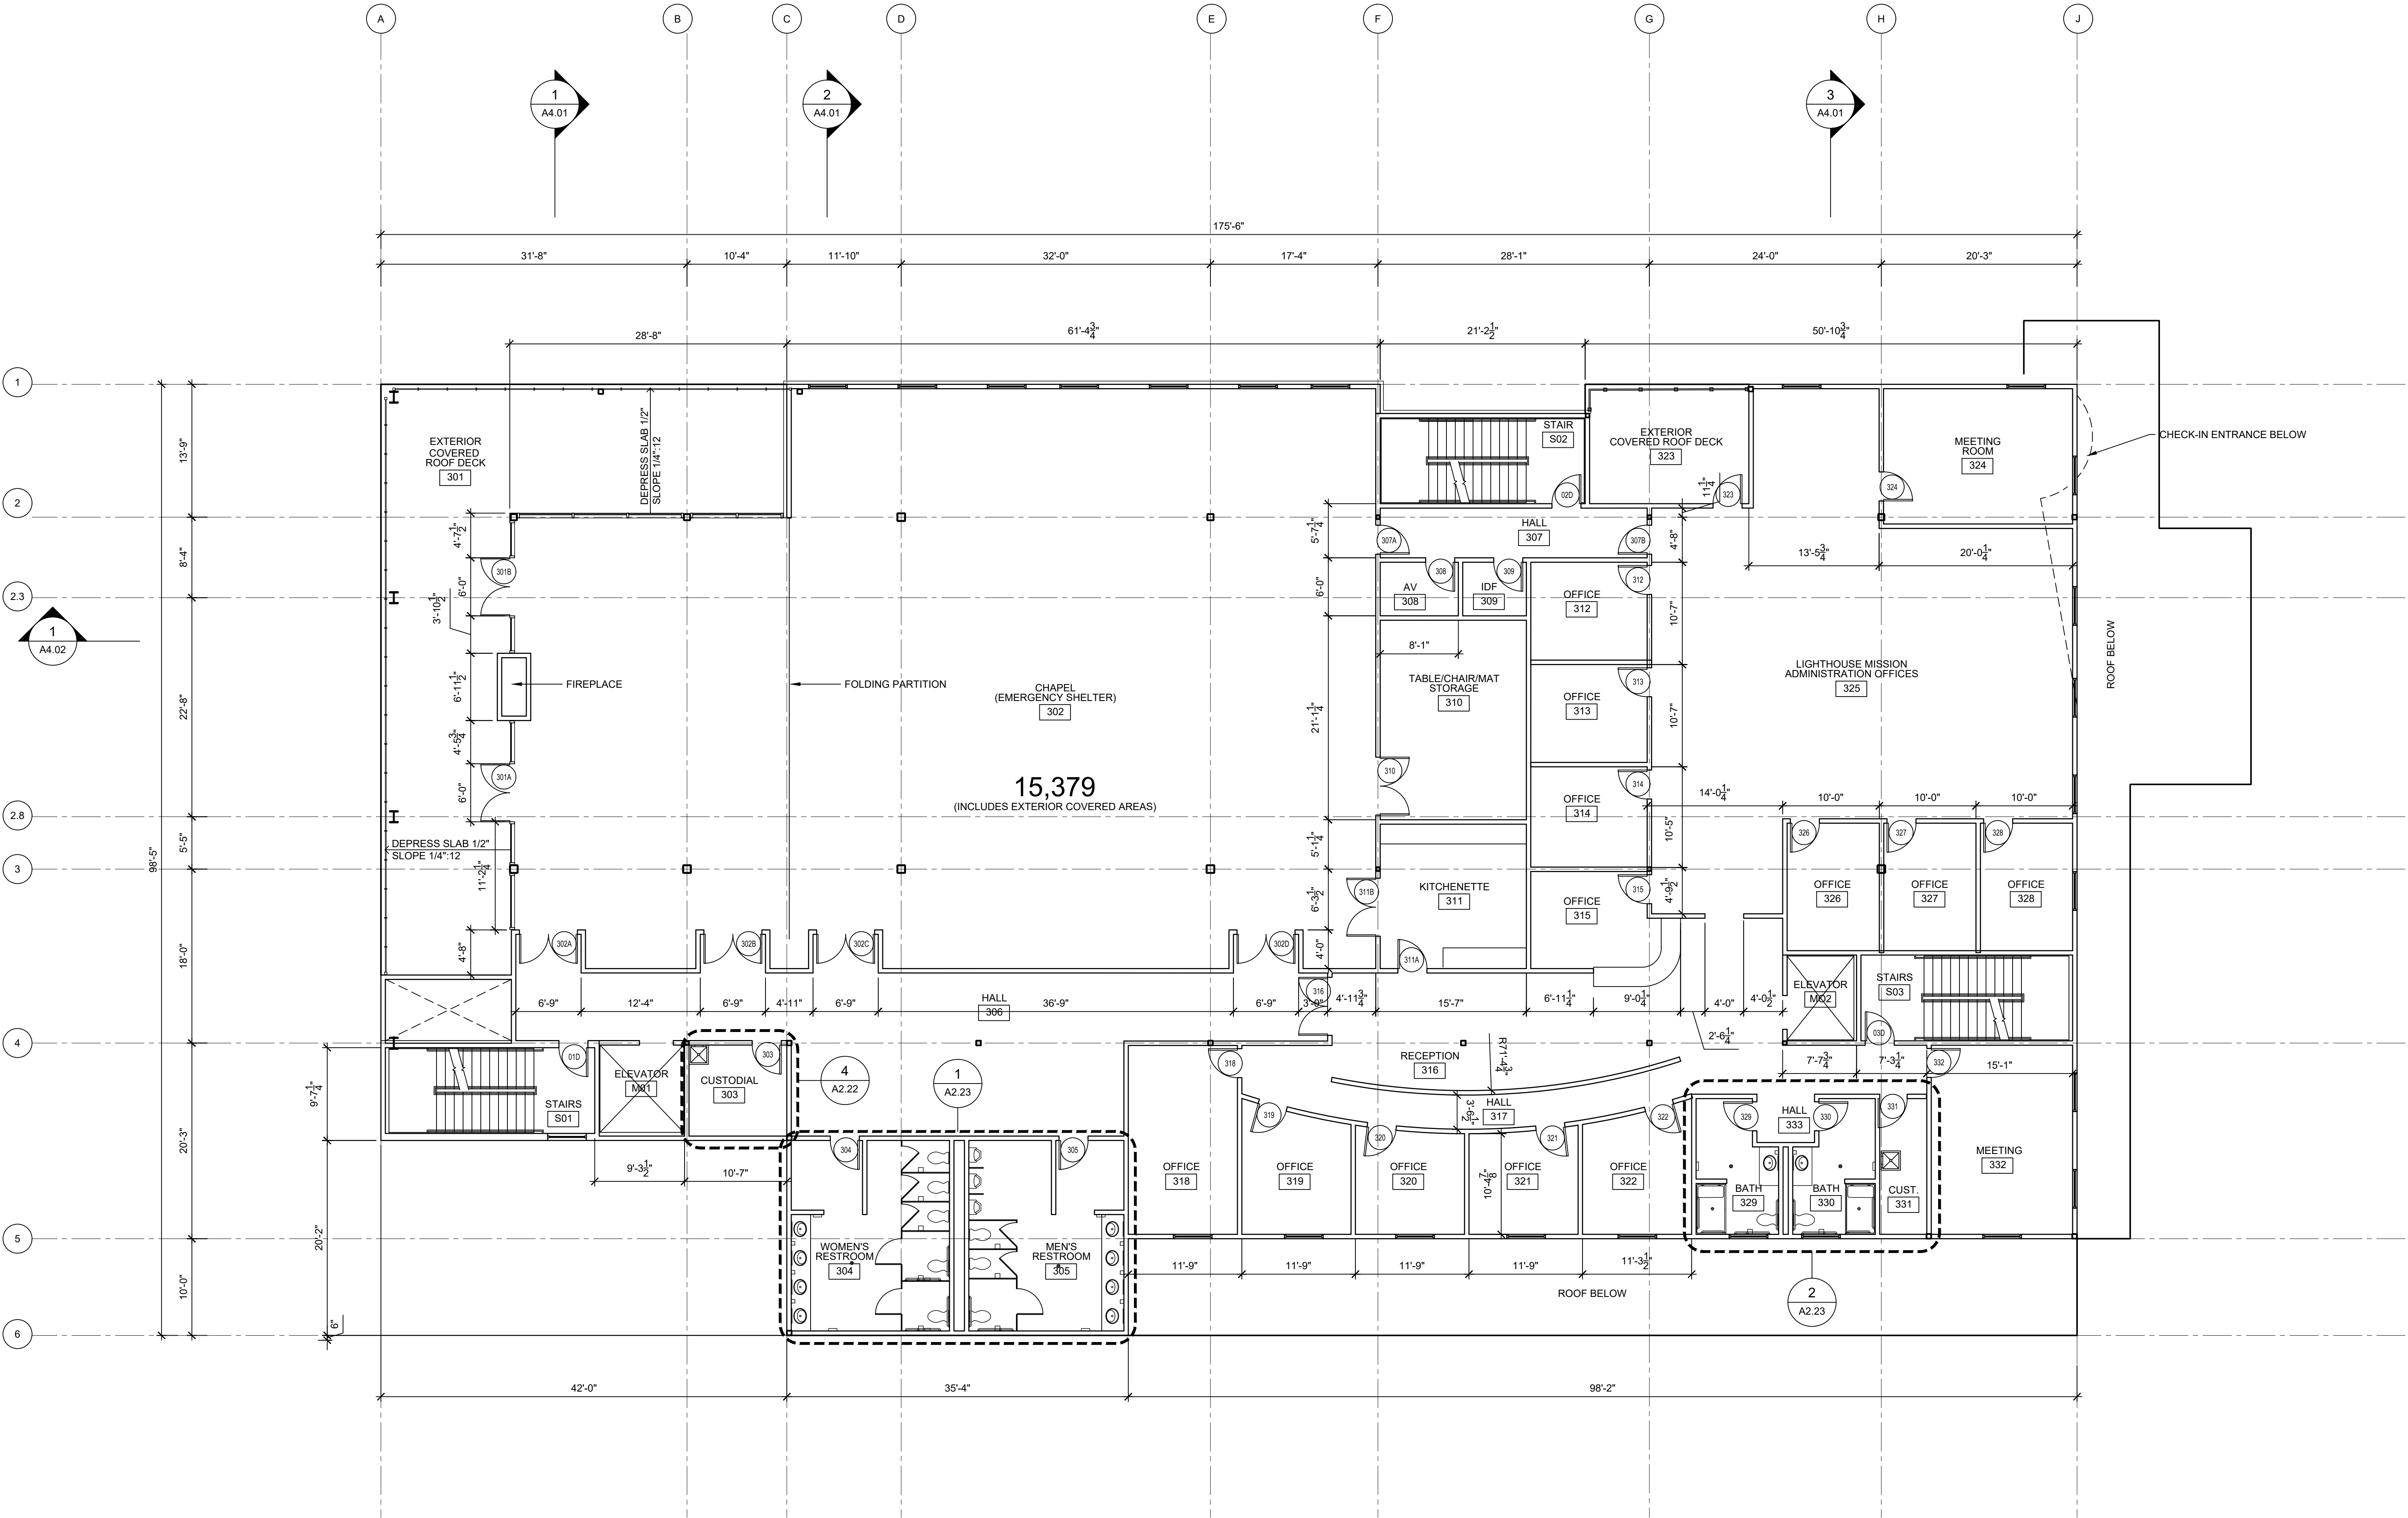

DESIGN DEVELOPMENT		
REV	ISSUED FOR	DATE

PLAN NORTH

TRUE NORTH

SCALE: 1/8"=1'-0"

LIGHTHOUSE MISSION RE-BUILD


THIRD FLOOR PLAN

PROJECT No: 202009.02
DRAWN BY: AK
CHECKED BY: AK
DATE ISSUED: 07.10.22

A2.03



ARCHITECTURE | INTERIOR DESIGN
zervasgroup.com
209 Prospect Street
Bellingham, WA 98225
360.734.4744

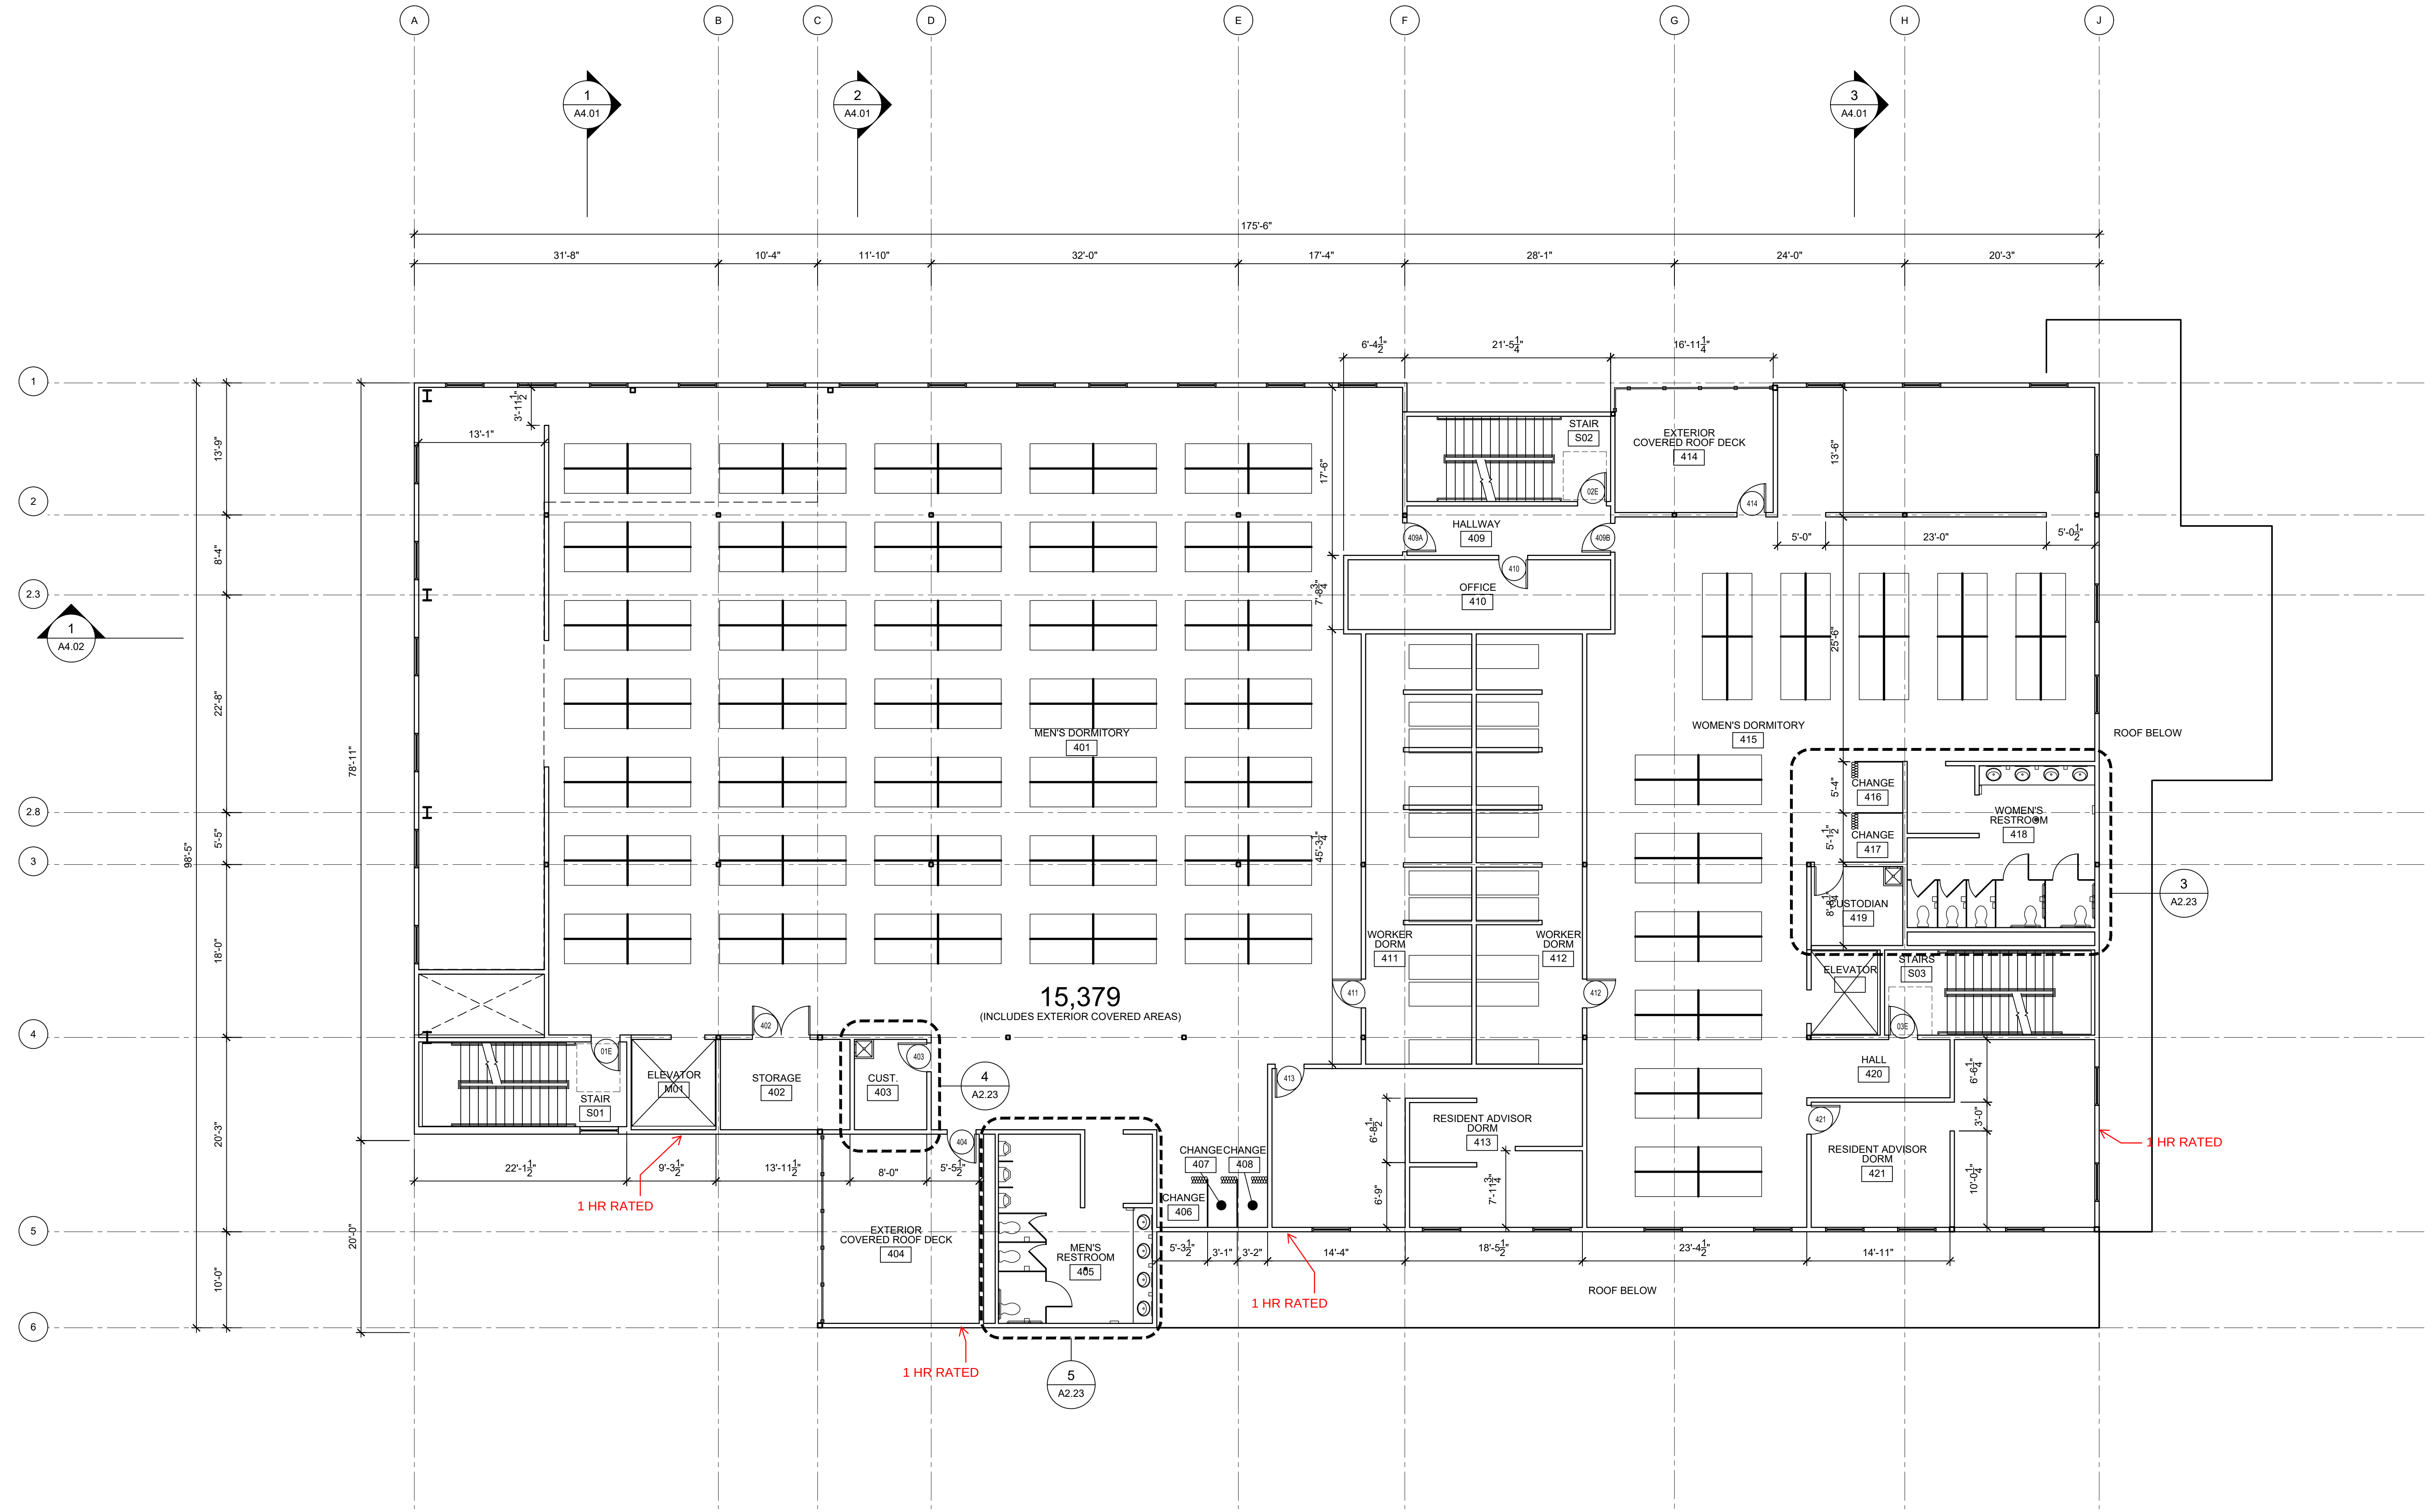

DESIGN DEVELOPMENT

REV	ISSUED FOR	DATE

PLAN NORTH

TRUE NORTH

SCALE: 1/8"=1'-0"
0 8'

LIGHTHOUSE MISSION RE-BUILD

FOURTH FLOOR PLAN


PROJECT No: 202009.02
DRAWN BY: AK
CHECKED BY: AK
DATE ISSUED: 07.10.22

A2.04

© 2019



ARCHITECTURE | INTERIOR DESIGN
zervasgroup.com
209 Prospect Street
Bellingham, WA 98225
360.734.4744

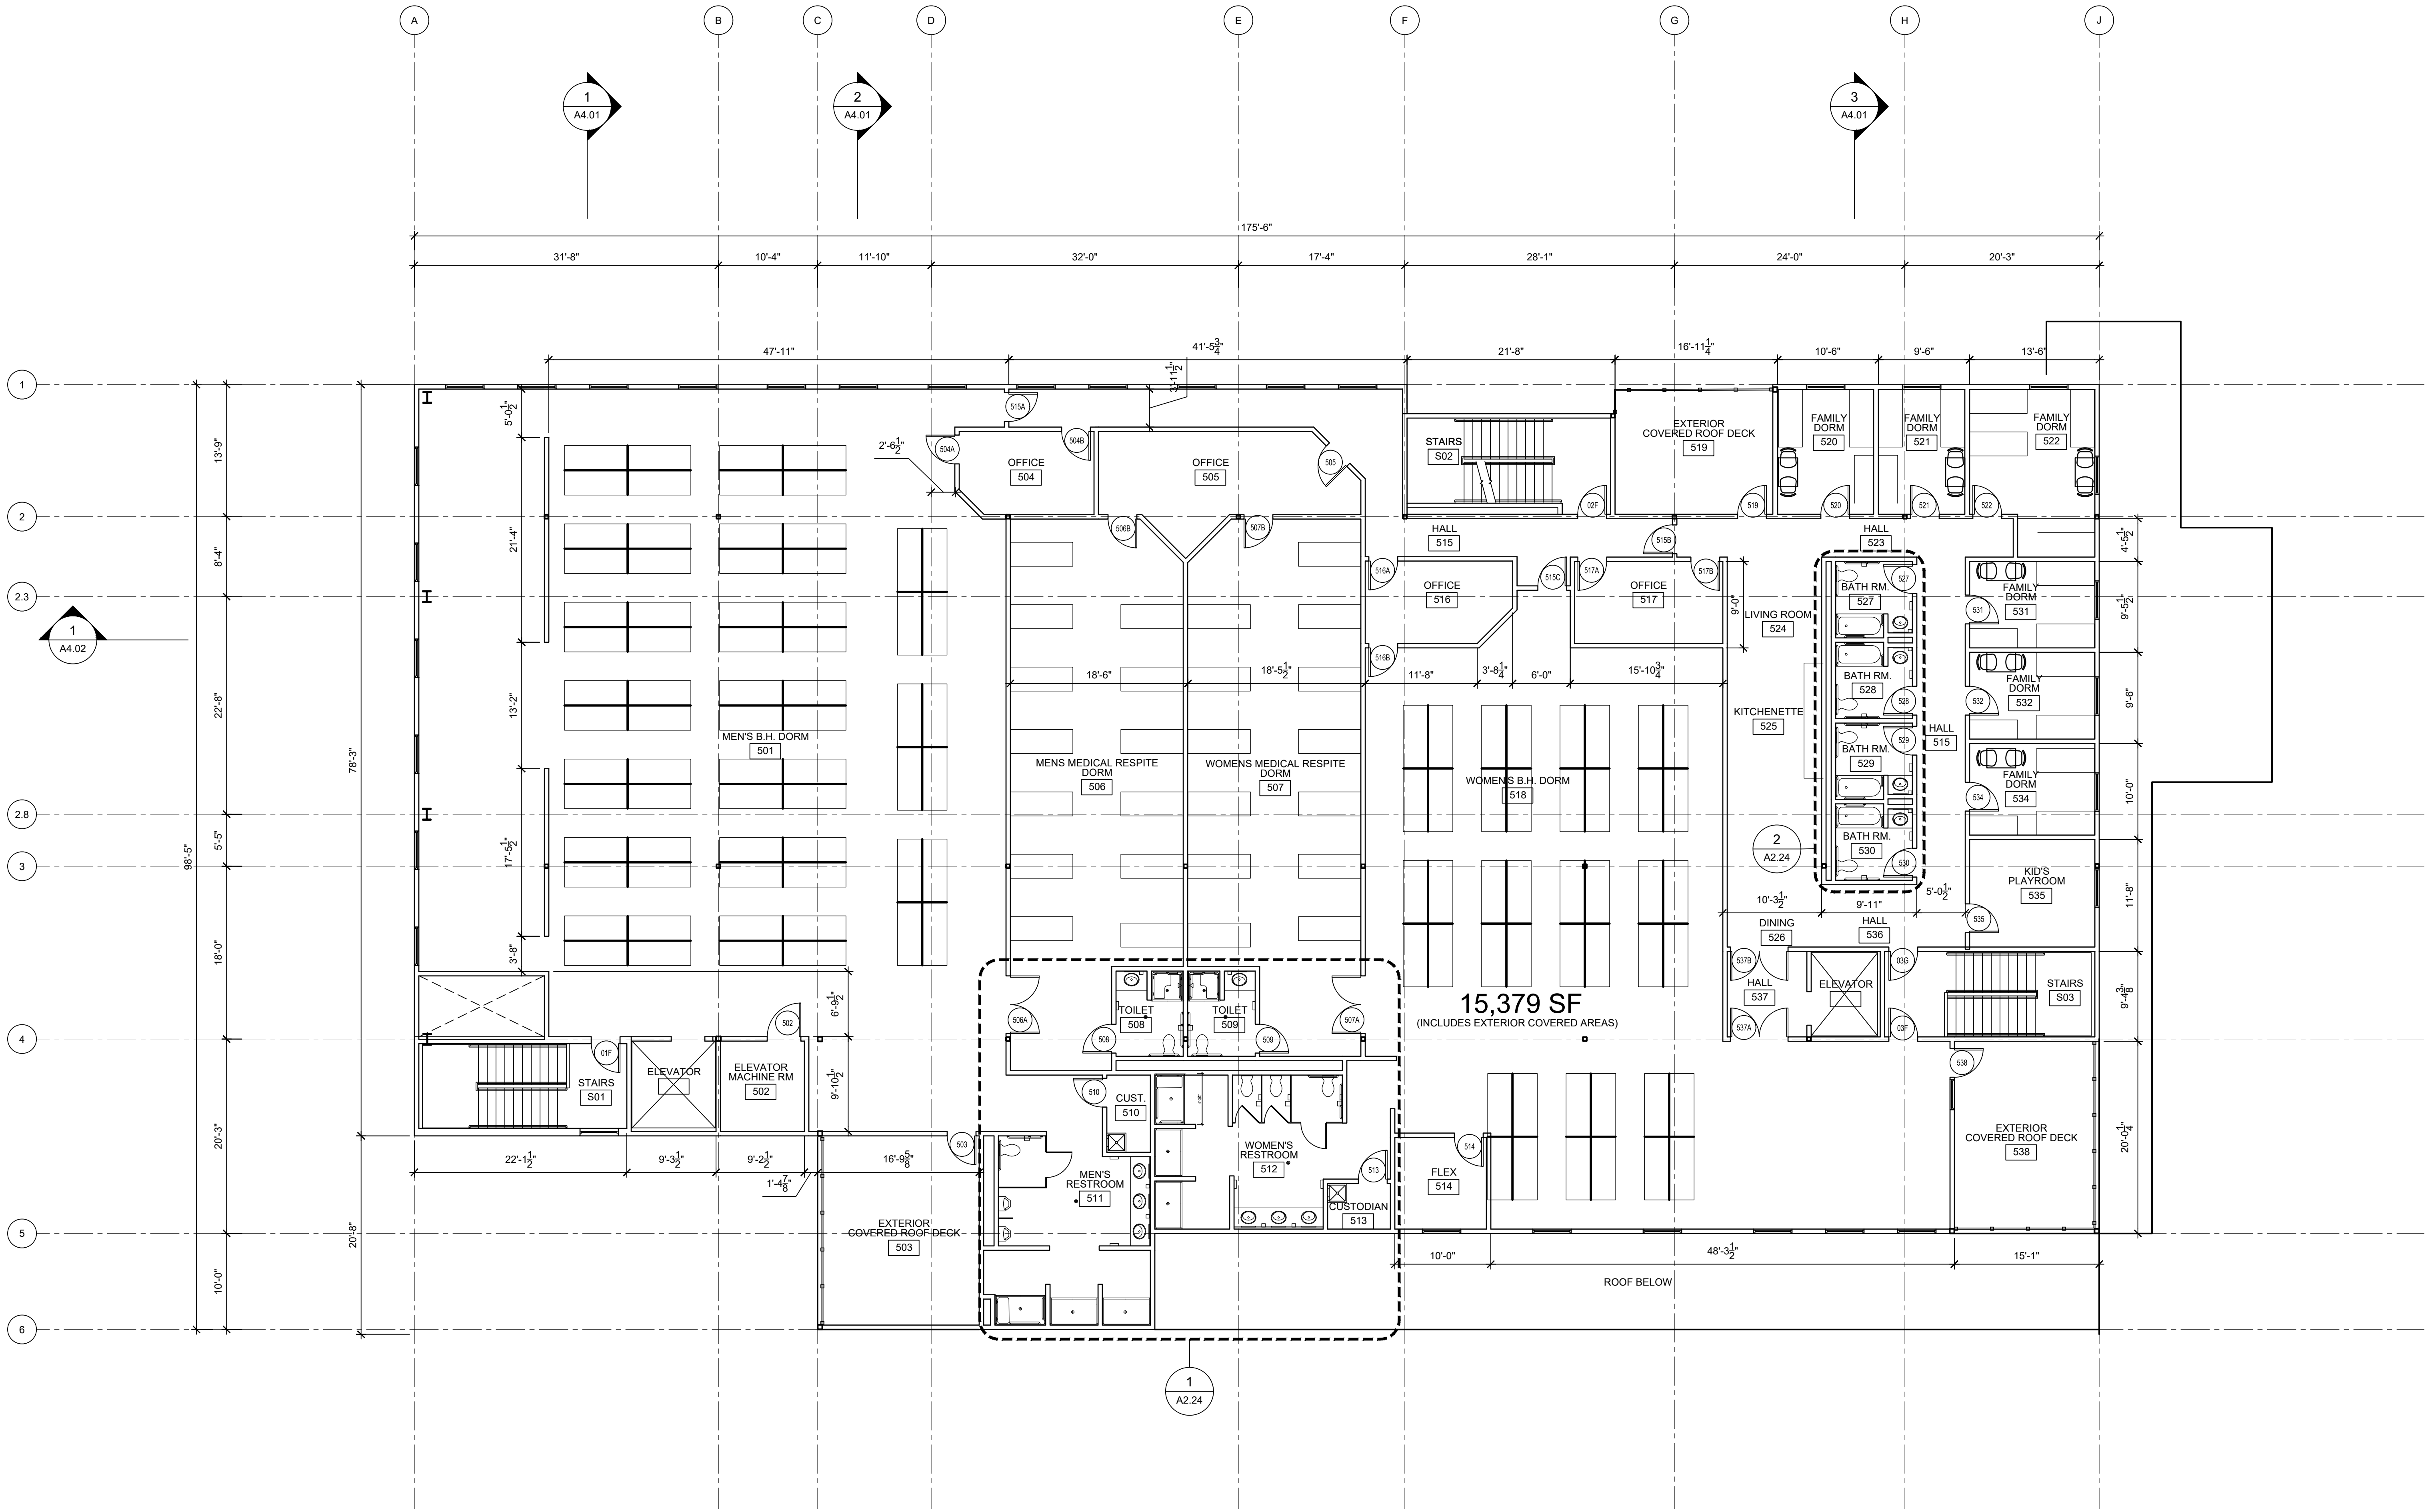

DESIGN DEVELOPMENT		
REV	ISSUED FOR	DATE

PLAN NORTH

TRUE NORTH

SCALE: 1/8"=1'-0"

0

8'

LIGHTHOUSE
MISSION
RE-BUILD

FIFTH FLOOR
PLAN


PROJECT No: 202009.02
DRAWN BY: AK
CHECKED BY: AK
DATE ISSUED: 07.10.22

A2.05

© 2019



ARCHITECTURE | INTERIOR DESIGN
zervasgroup.com
209 Prospect Street
Bellingham, WA 98225
360.734.4744

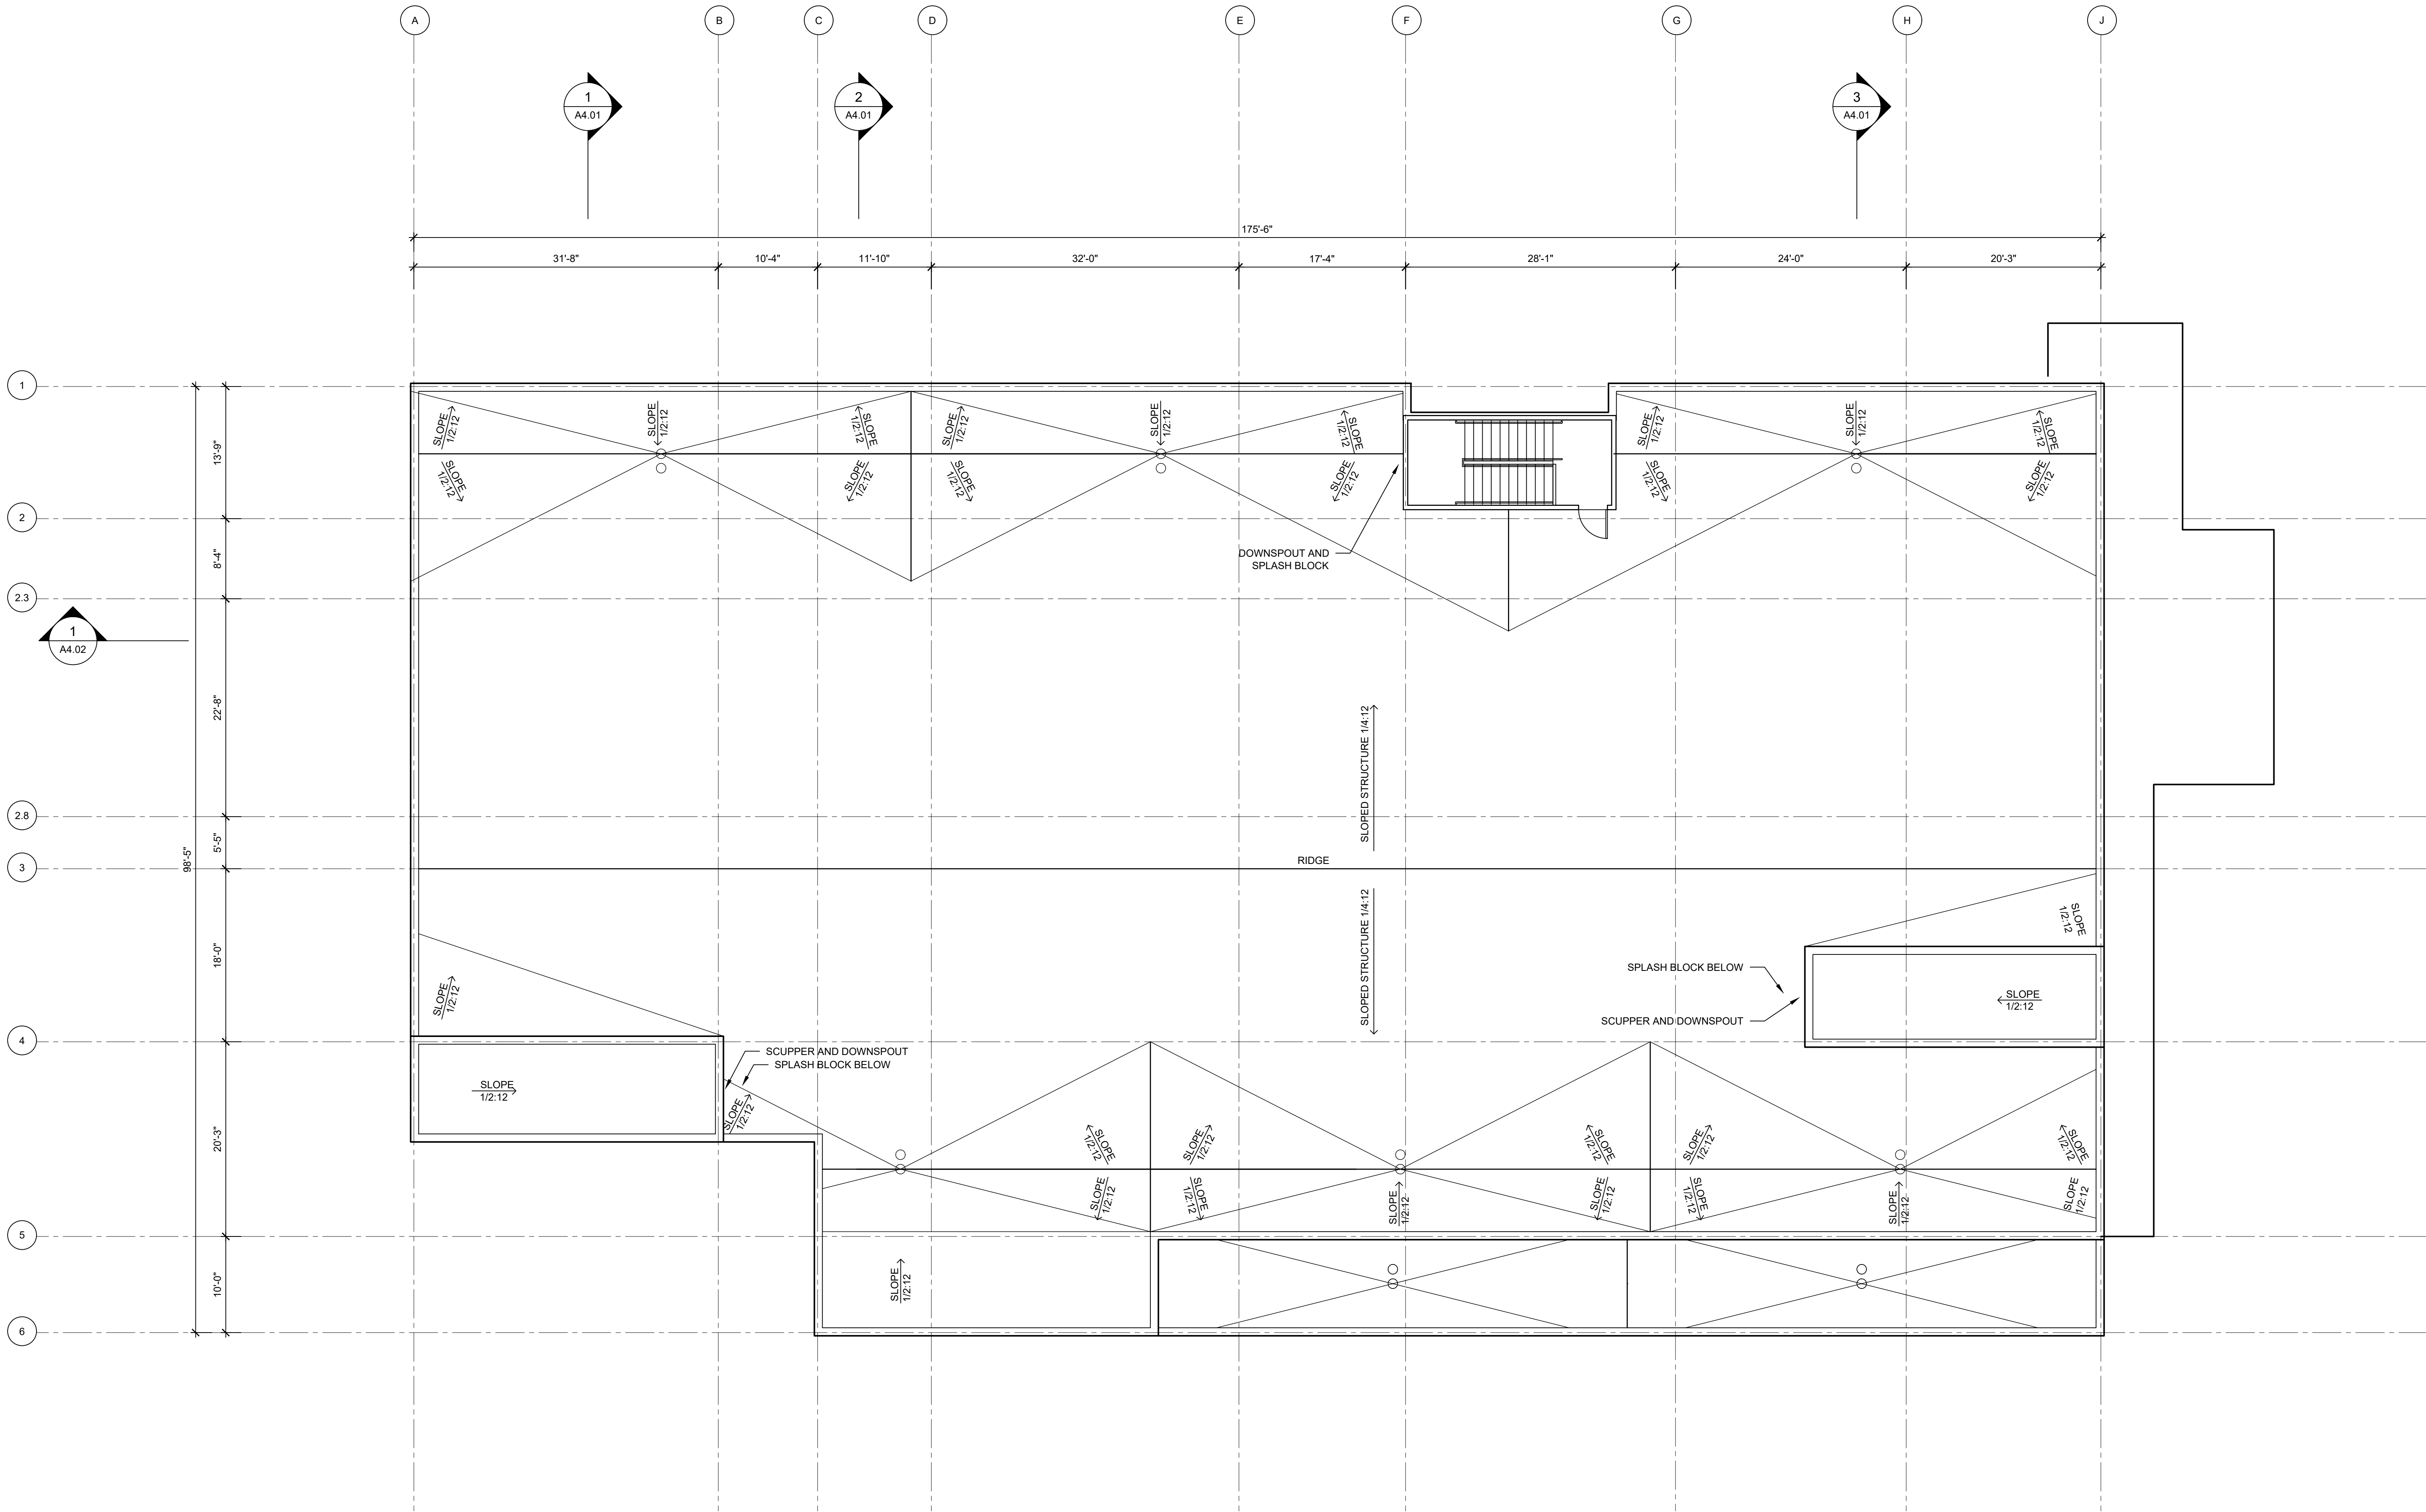


DESIGN DEVELOPMENT

REV	ISSUED FOR	DATE


PLAN NORTH


TRUE NORTH

 SCALE: 1/8"=1'-0"




LIGHTHOUSE MISSION RE-BUILD

ROOF PLAN

PROJECT No: 202009.02
DRAWN BY: AK
CHECKED BY: AK
DATE ISSUED: 07.10.22


A2.05

- ① SURFACE MOUNTED PAPER TOWEL DISPENSER
OWNER PROVIDED/OWNER INSTALLED
- ② NEW SINK w/ SHROUD AND FAUCET TO MATCH
BUILDING STANDARD
- ③ MIRROR
BOBRICK #B-165 1830
- ④ SOAP DISPENSER
BOBRICK #B-2012
- ⑤ 36" GRAB BAR
BOBRICK #B-5806X36
- ⑥ NEW ACCESSIBLE TOILET TO MATCH BUILDING
STANDARD
- ⑦ TOILET TISSUE DISPENSER
OWNER PROVIDED/OWNER INSTALLED
- ⑧ 18" GRAB BAR
BOBRICK #B-5806X18
- ⑨ 42" GRAB BAR
BOBRICK #B-5806X42
- ⑩ NEW JANITOR MOP SINK TO MATCH BUILDING
STANDARD
- ⑪ 36 X 36 TRANSFER SHOWER
- ⑫ 36X60 ACCESSIBLE ROLL IN SHOWER
- ⑬ 30 X 60 SHOWER
- ⑭ BATH TUB
- ⑮ STANDARD TOILET
- ⑯ URINAL
- ⑰ ADA URINAL
- ⑱ NAPKIN DISPENSER

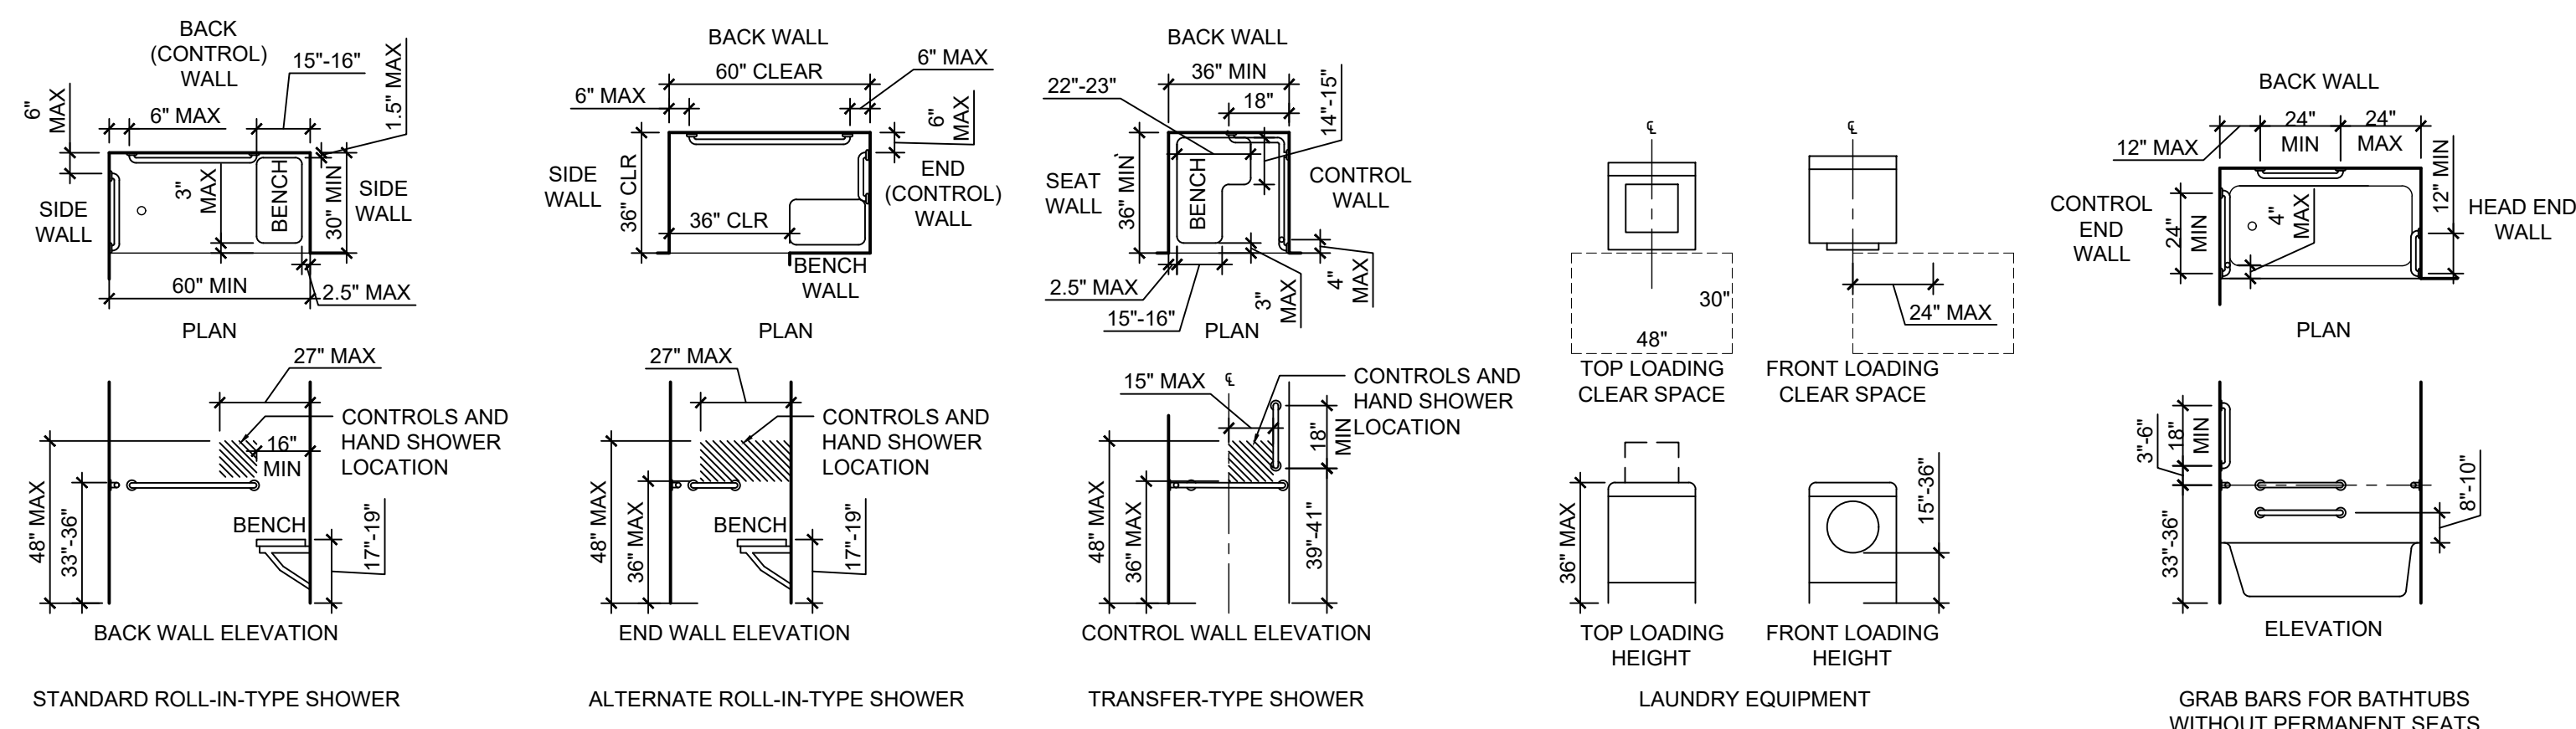


NOTES:

1. FIXTURES ARE GENERIC REPRESENTATIONS AND DO NOT NECESSARILY REPRESENT THE ITEM AS SPECIFIED.
2. ALL DIMENSIONS ARE TYPICAL UNLESS OTHERWISE NOTED ON DRAWINGS
3. THE HEIGHT ABOVE FINISH FLOOR TO ANY RACK, OPERATING CONTROL, RECEPTACLE OR DISPENSER DEEMED ADA ACCESSIBLE MAY NOT EXCEED 48"
4. EXPOSED HOT WATER AND DRAIN PIPES SHALL BE INSULATED OR OTHERWISE COVERED.
5. THERE WILL BE NO SHARP OR ABRASIVE SURFACES UNDER SINKS.
6. DISPENSERS AND RECEPTACLES SHALL BE INSTALLED WITHIN EASY REACH OF THE WC AND SHALL NOT INTERFERE WITH GRAB BAR UTILIZATION.
7. A HAND SHOWER W/ A HOSE 59" MIN IN LENGTH, THAT CAN BE USED BOTH AS A FIXED SHOWER HEAD AND AS A HAND SHOWER, SHALL BE PROVIDED. THE CONTROL SHALL HAVE A NONPOSITIVE SHUT-OFF FEATURE. WHERE PROVIDED, AN ADJUSTABLE HEIGHT HAND SHOWER MOUNTED ON A VERTICAL BAR SHALL BE INSTALLED SO AS TO NOT OBSTRUCT THE USE OF GRAB BARS.
8. THRESHOLDS AT ROLL-IN-TYPE SHOWER COMPARTMENTS SHALL NOT EXCEED 1/2"

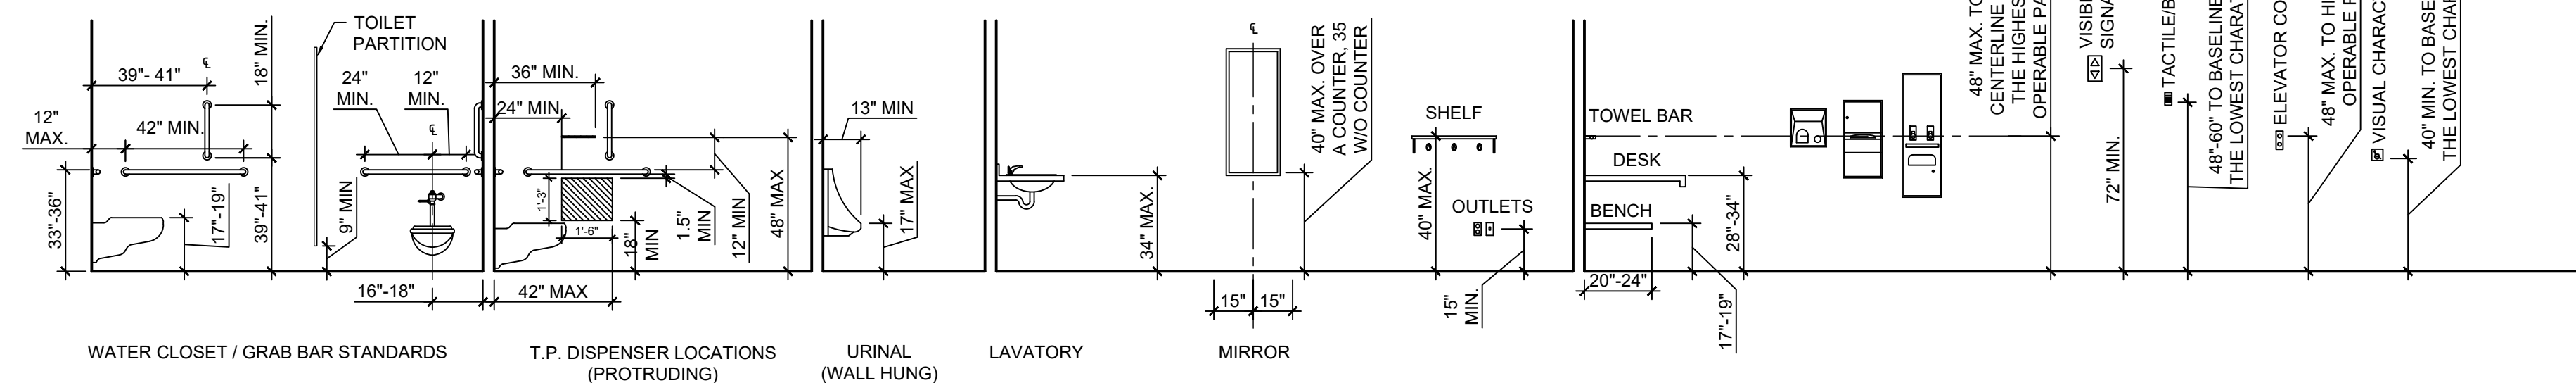


4 FIRST
1/4" = 1'-0"

REV	ISSUED FOR	DATE

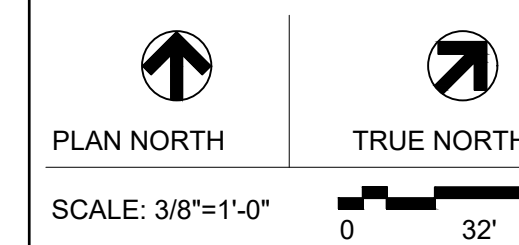


1st FLOOR ENLARGED FLOOR PLANS AND TYP. ADA MOUNTING HEIGHTS


PROJECT No:	202009.02
DRAWN BY:	AK
CHECKED BY:	AK
DATE ISSUED:	07.10.22

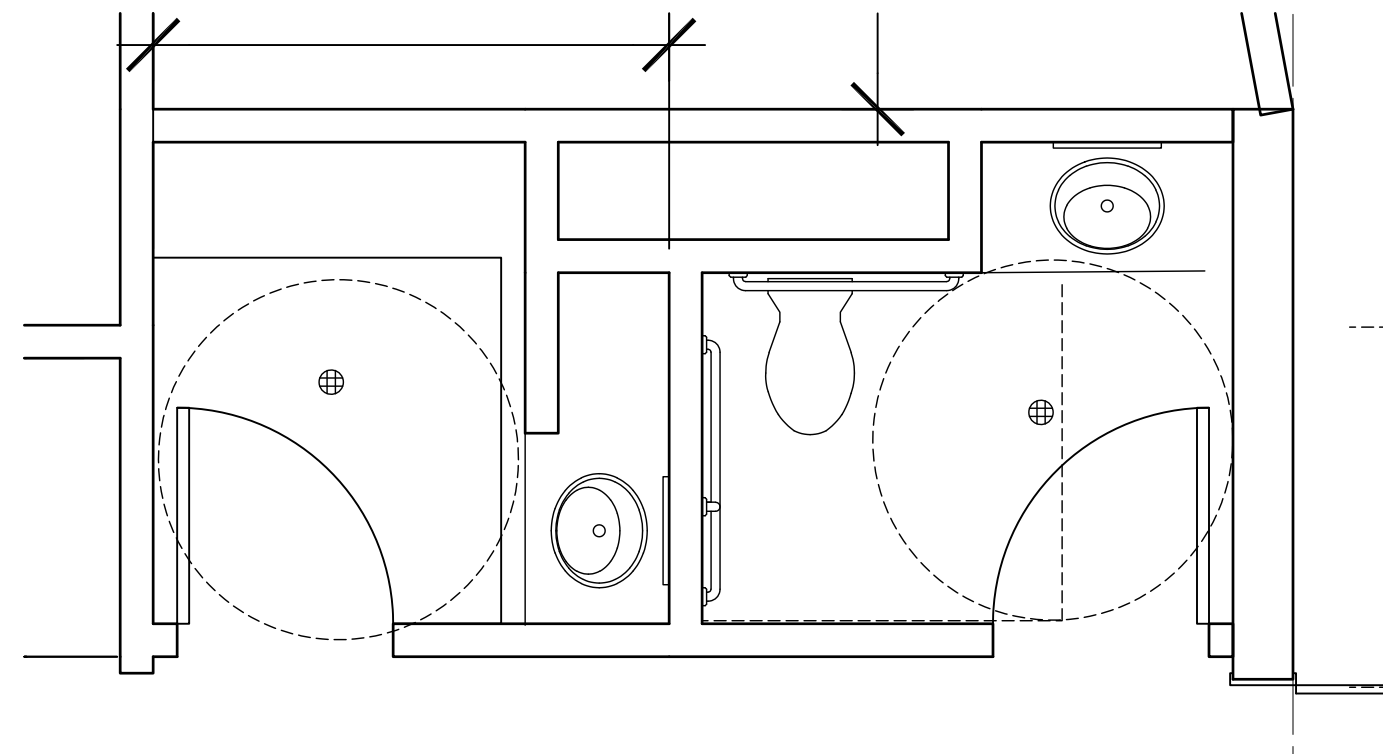


1 SECOND FLOOR TOILET ROOMS
3/8" = 1'-0"

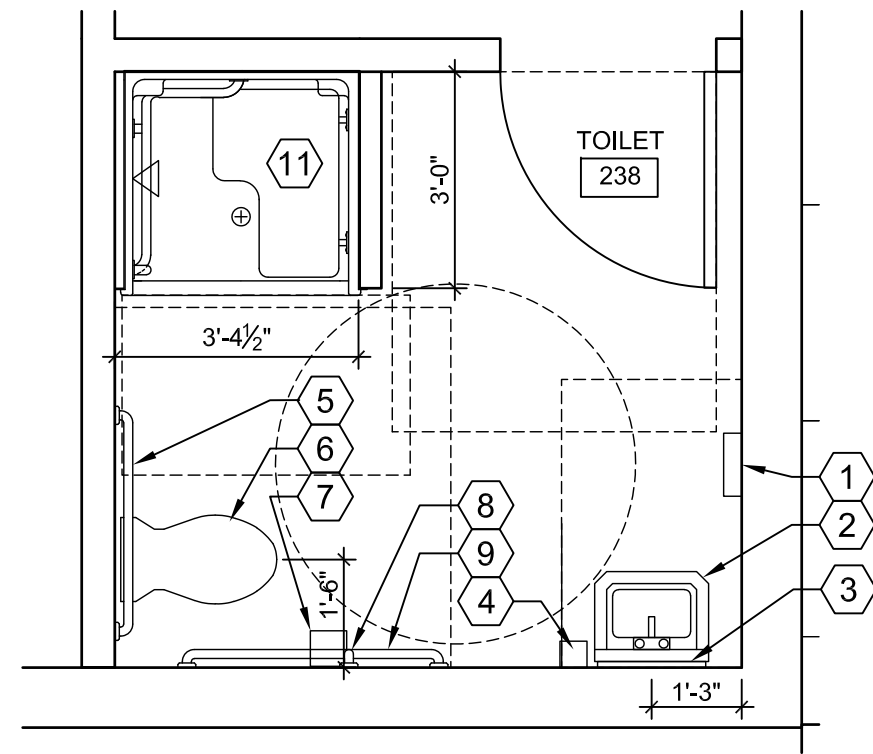

2 TOILET 238
3/8" = 1'-0"

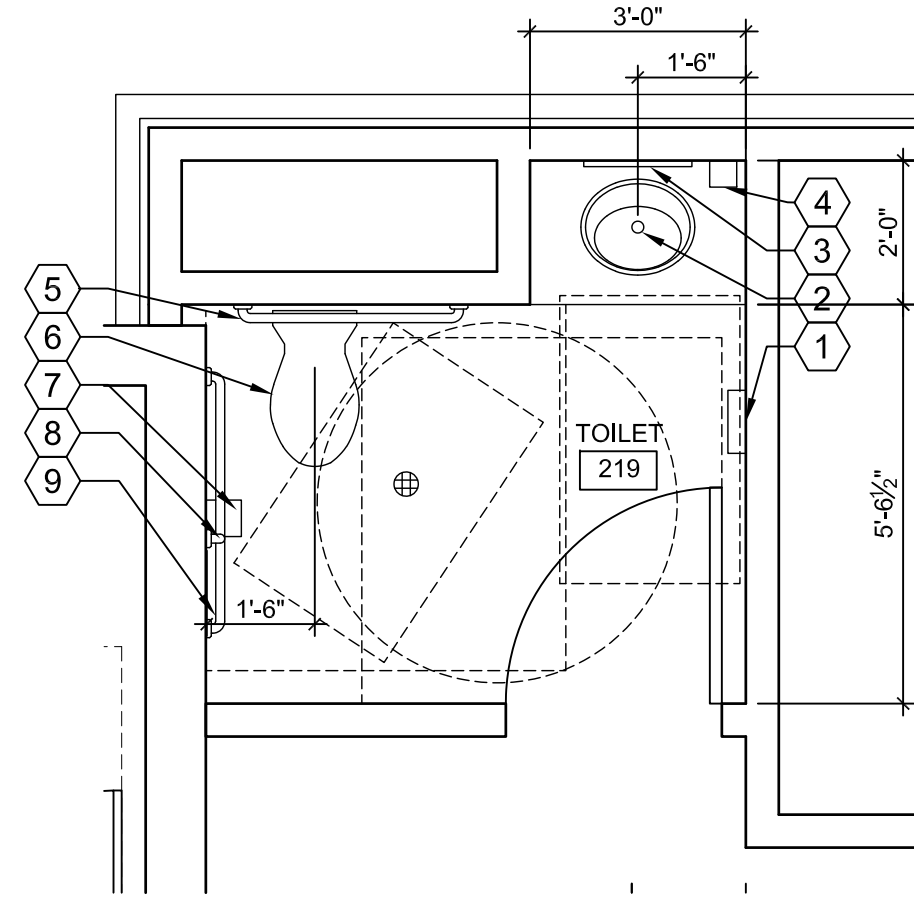


3 TOILET 219
3/8" = 1'-0"

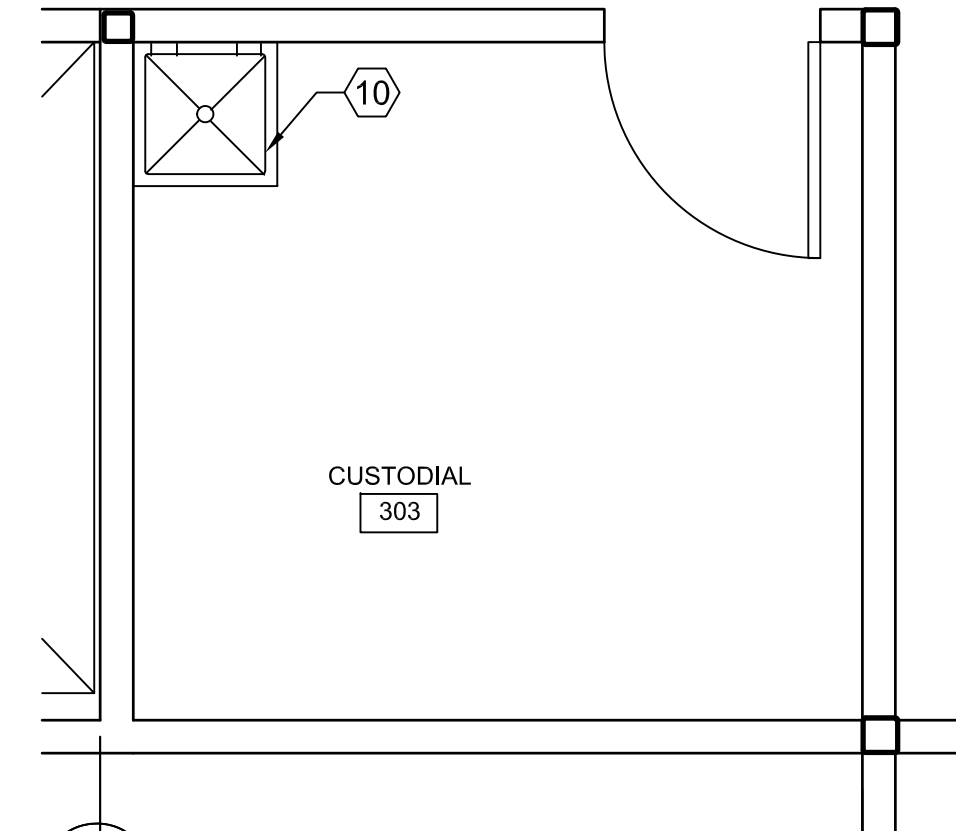

3 CUSTODIAL 303
3/8" = 1'-0"

TOILET ACCESSORY & PLUMBING LEGEND


- 1 SURFACE MOUNTED PAPER TOWEL DISPENSER
OWNER PROVIDED/OWNER INSTALLED
- 2 NEW SINK w/ SHROUD AND FAUCET TO MATCH
BUILDING STANDARD
- 3 MIRROR
BOBRICK #B-165 1830
- 4 SOAP DISPENSER
BOBRICK #B-2012
- 5 36" GRAB BAR
BOBRICK #B-5806X36
- 6 NEW ACCESSIBLE TOILET TO MATCH BUILDING
STANDARD
- 7 TOILET TISSUE DISPENSER
OWNER PROVIDED/OWNER INSTALLED
- 8 18" GRAB BAR
BOBRICK #B-5806X18
- 9 42" GRAB BAR
BOBRICK #B-5806X42
- 10 NEW JANITOR MOP SINK TO MATCH BUILDING
STANDARD
- 11 36 X 36 TRANSFER SHOWER
- 12 36X60 ACCESSIBLE ROLL IN SHOWER
- 13 30 X 60 SHOWER
- 14 BATH TUB
- 15 STANDARD TOILET
- 16 URINAL
- 17 ADA URINAL
- 18 NAPKIN DISPENSER
- 19 TOILET PARTITION

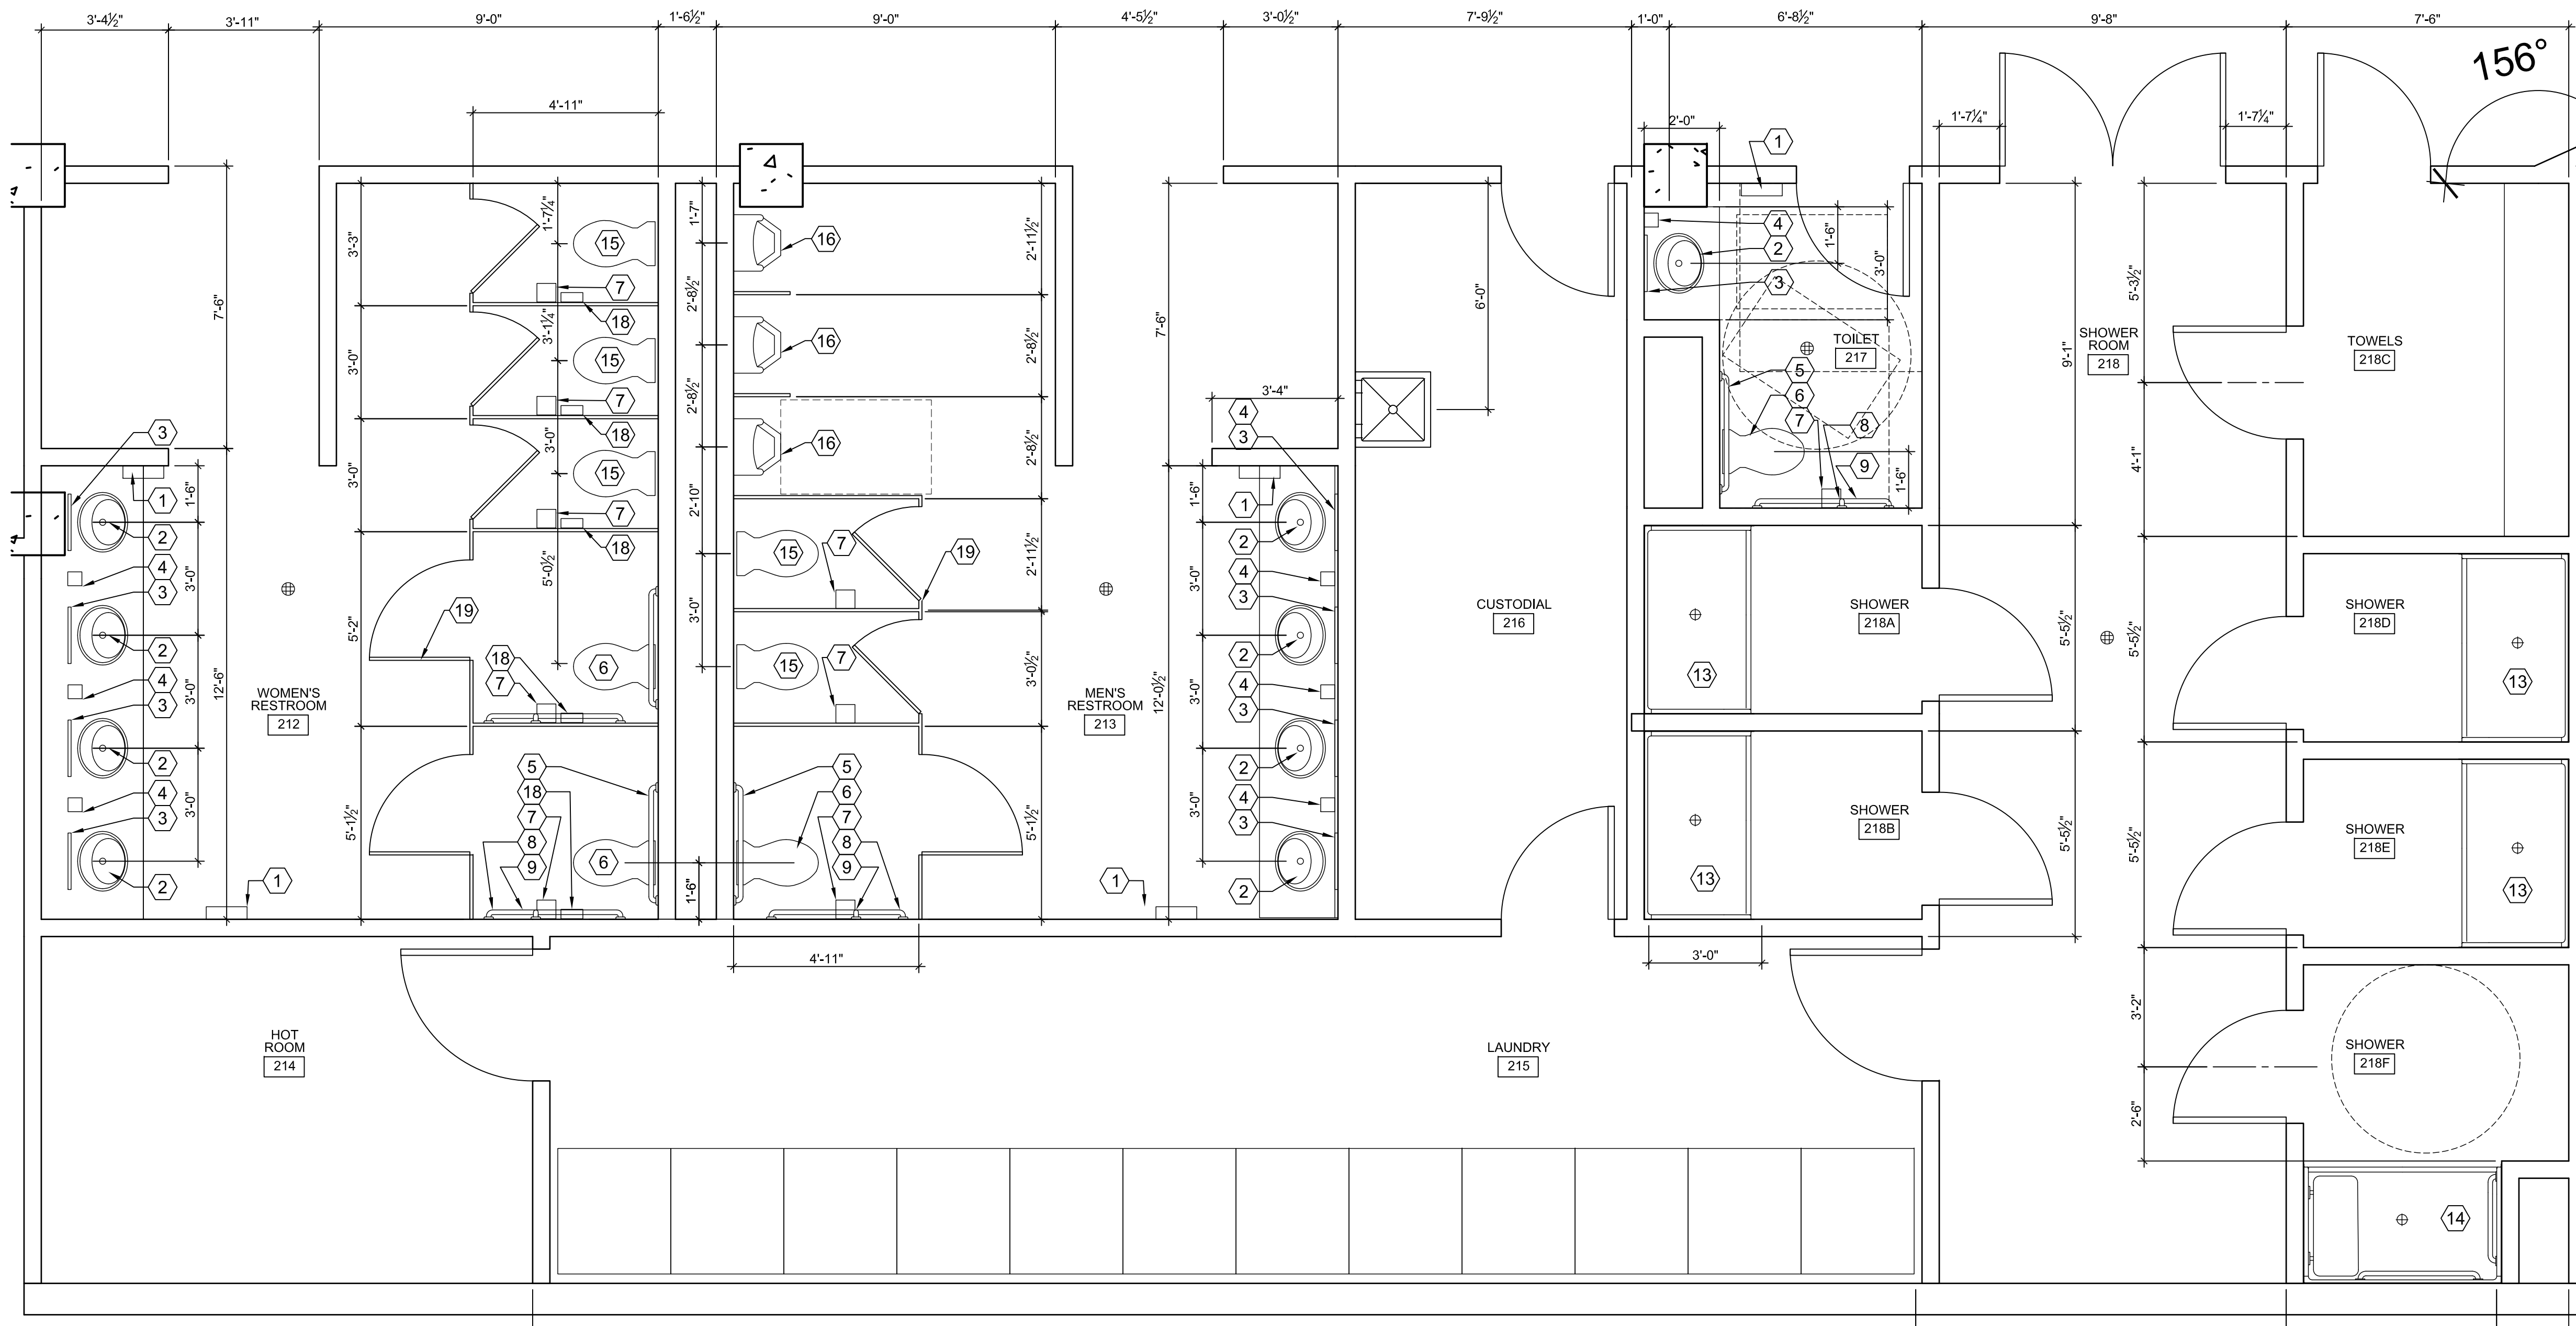

3 SECOND FLOOR ENLARGED PLAN
3/8" = 1'-0"

DESIGN DEVELOPMENT


REV	ISSUED FOR	DATE

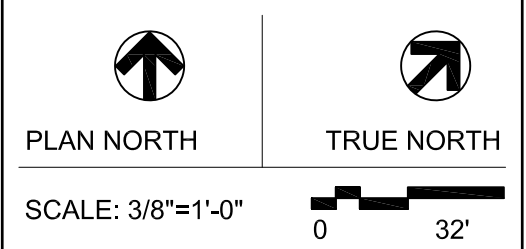


LIGHTHOUSE MISSION RE-BUILD

SECOND AND THIRD FLOOR ENLARGED PLANS

PROJECT No: 202009.02
DRAWN BY: AK
CHECKED BY: AK
DATE ISSUED: 07.10.22

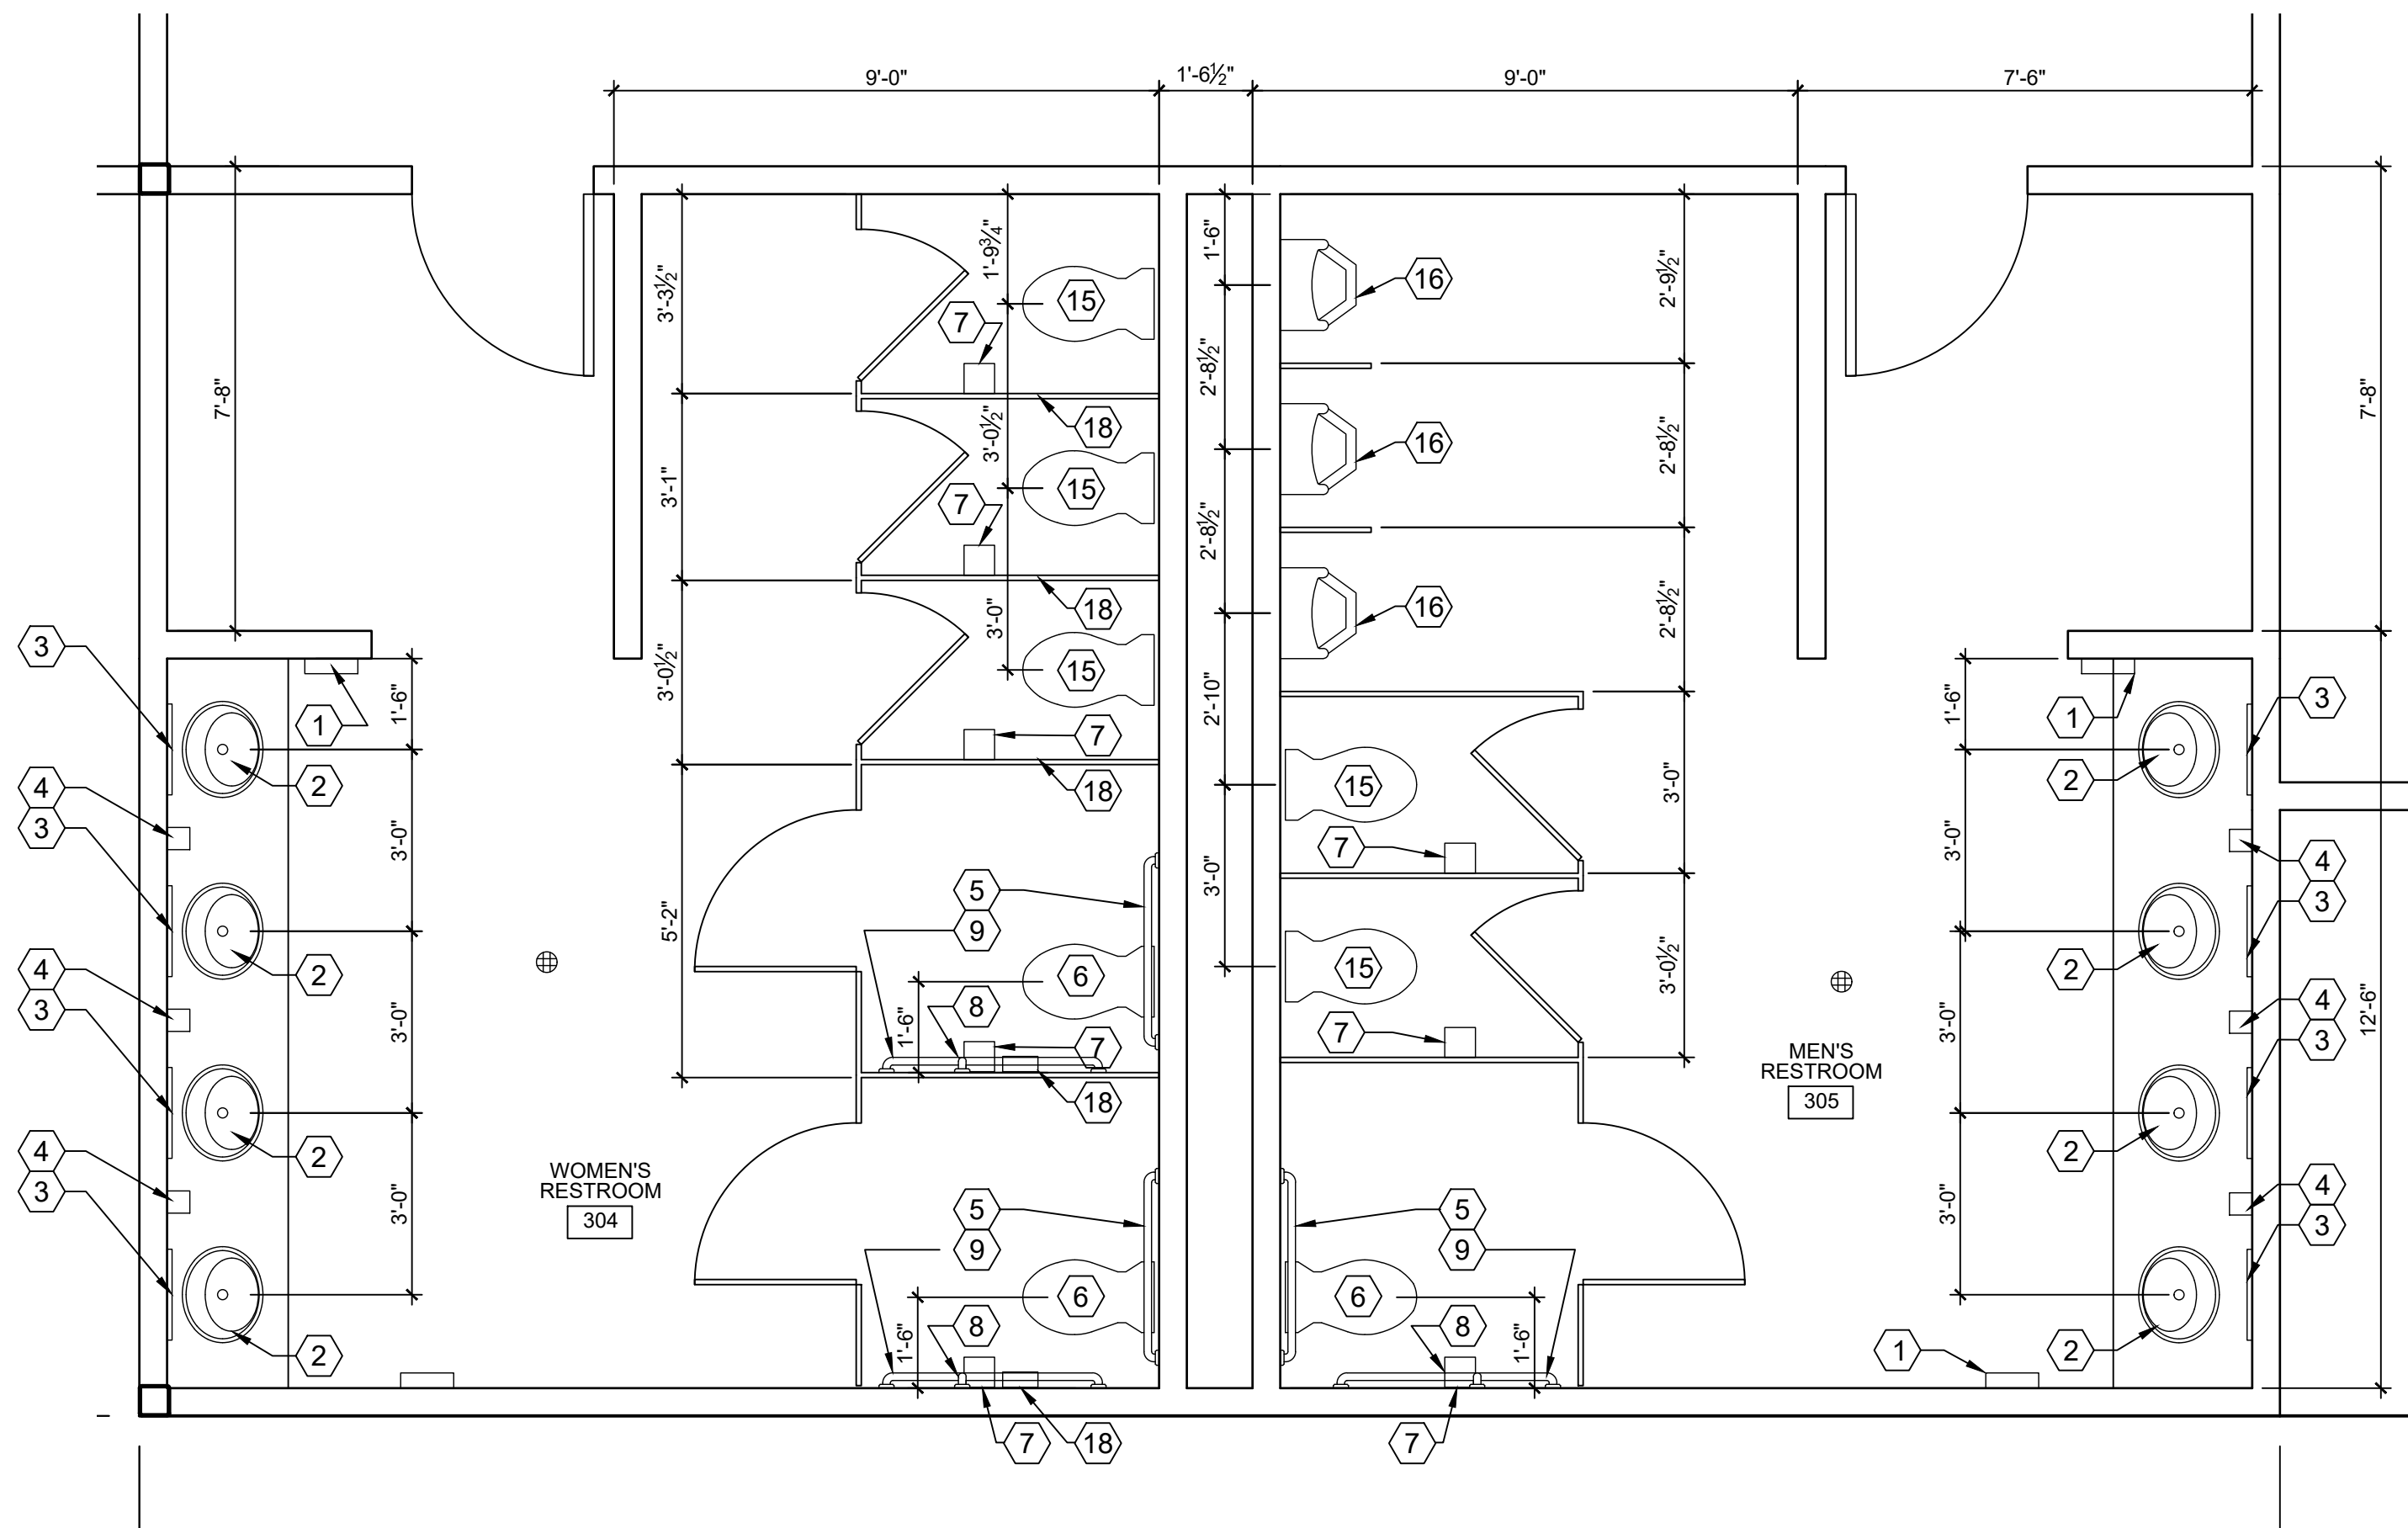


1 THIRD FLOOR ENLARGED RESTROOMS 304 AND 305
3/8" = 1'-0"

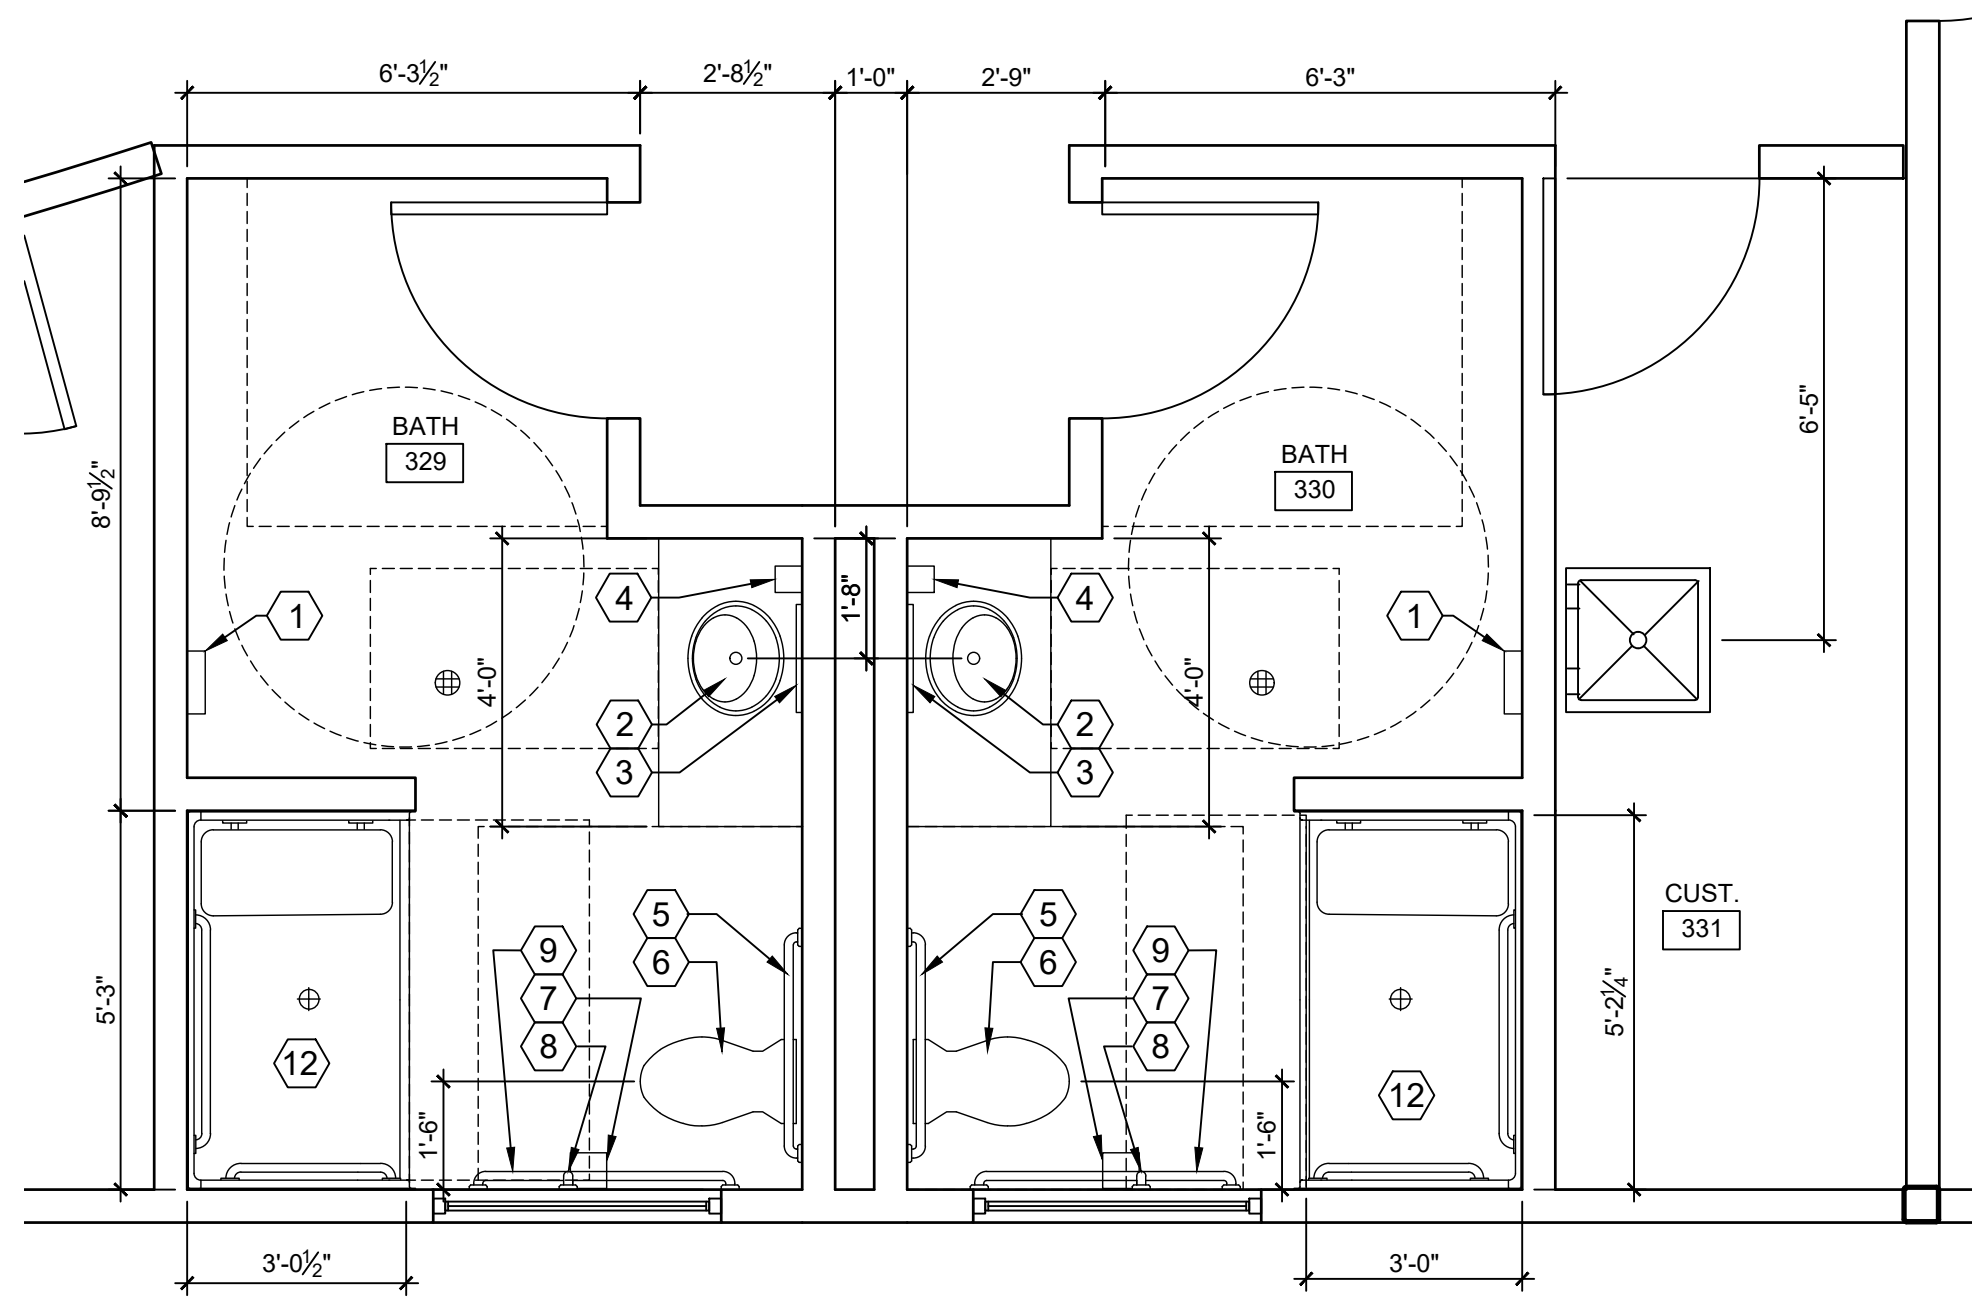


2 THIRD FLOOR BATH ROOMS 329 AND 330
3/8" = 1'-0"

TOILET ACCESSORY & PLUMBING LEGEND


- 1 SURFACE MOUNTED PAPER TOWEL DISPENSER
OWNER PROVIDED/OWNER INSTALLED
- 2 NEW SINK w/ SHROUD AND FAUCET TO MATCH
BUILDING STANDARD
- 3 MIRROR
BOBRICK #B-165 1830
- 4 SOAP DISPENSER
BOBRICK #B-2012
- 5 36" GRAB BAR
BOBRICK #B-5806X36
- 6 NEW ACCESSIBLE TOILET TO MATCH BUILDING
STANDARD
- 7 TOILET TISSUE DISPENSER
OWNER PROVIDED/OWNER INSTALLED
- 8 18" GRAB BAR
BOBRICK #B-5806X18
- 9 42" GRAB BAR
BOBRICK #B-5806X42
- 10 NEW JANITOR MOP SINK TO MATCH BUILDING
STANDARD
- 11 36 X 36 TRANSFER SHOWER
- 12 36X60 ACCESSIBLE ROLL IN SHOWER
- 13 30 X 60 SHOWER
- 14 BATH TUB
- 15 STANDARD TOILET
- 16 URINAL
- 17 ADA URINAL
- 18 NAPKIN DISPENSER

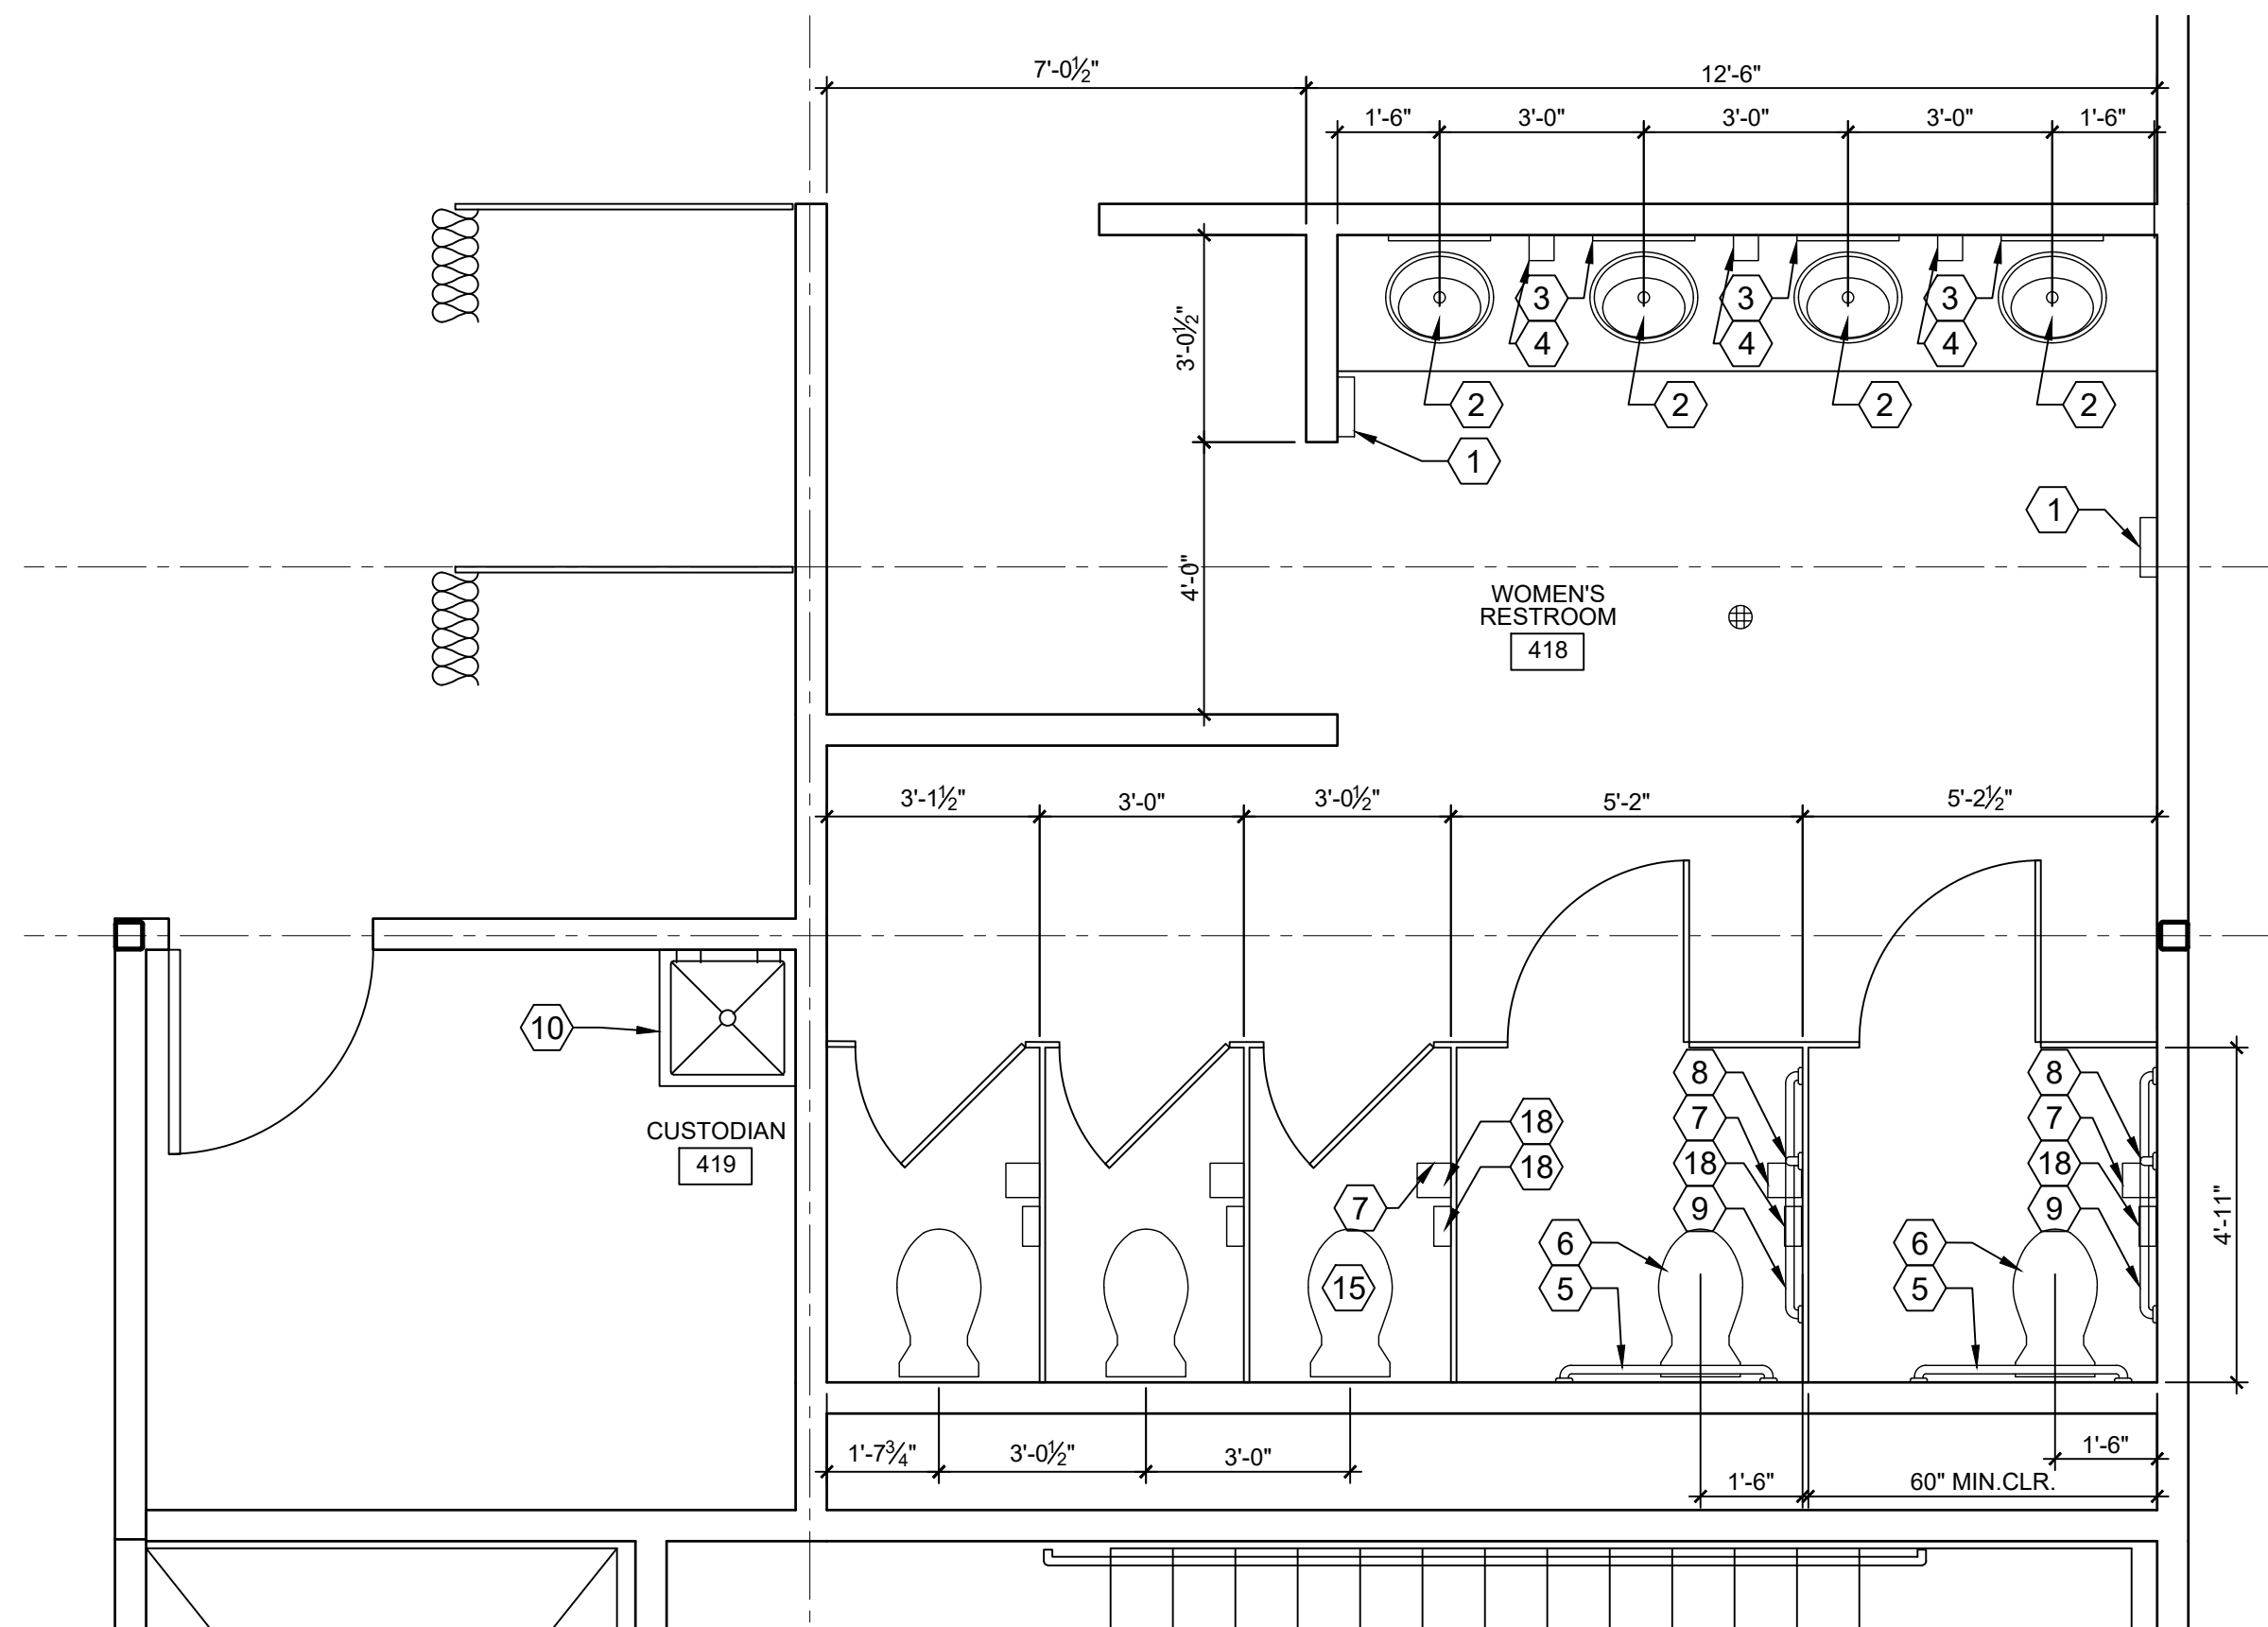

3 WOMEN'S RESTROOM 418 AND CUSTODIAN 419
3/8" = 1'-0"

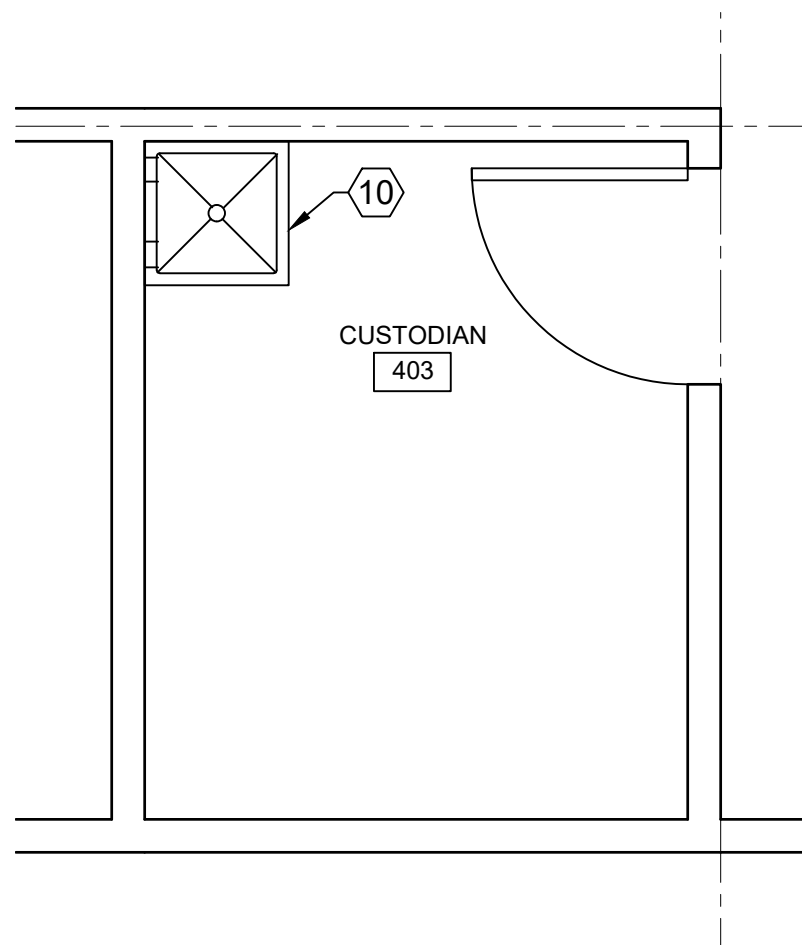


4 CUSTODIAN 403
3/8" = 1'-0"

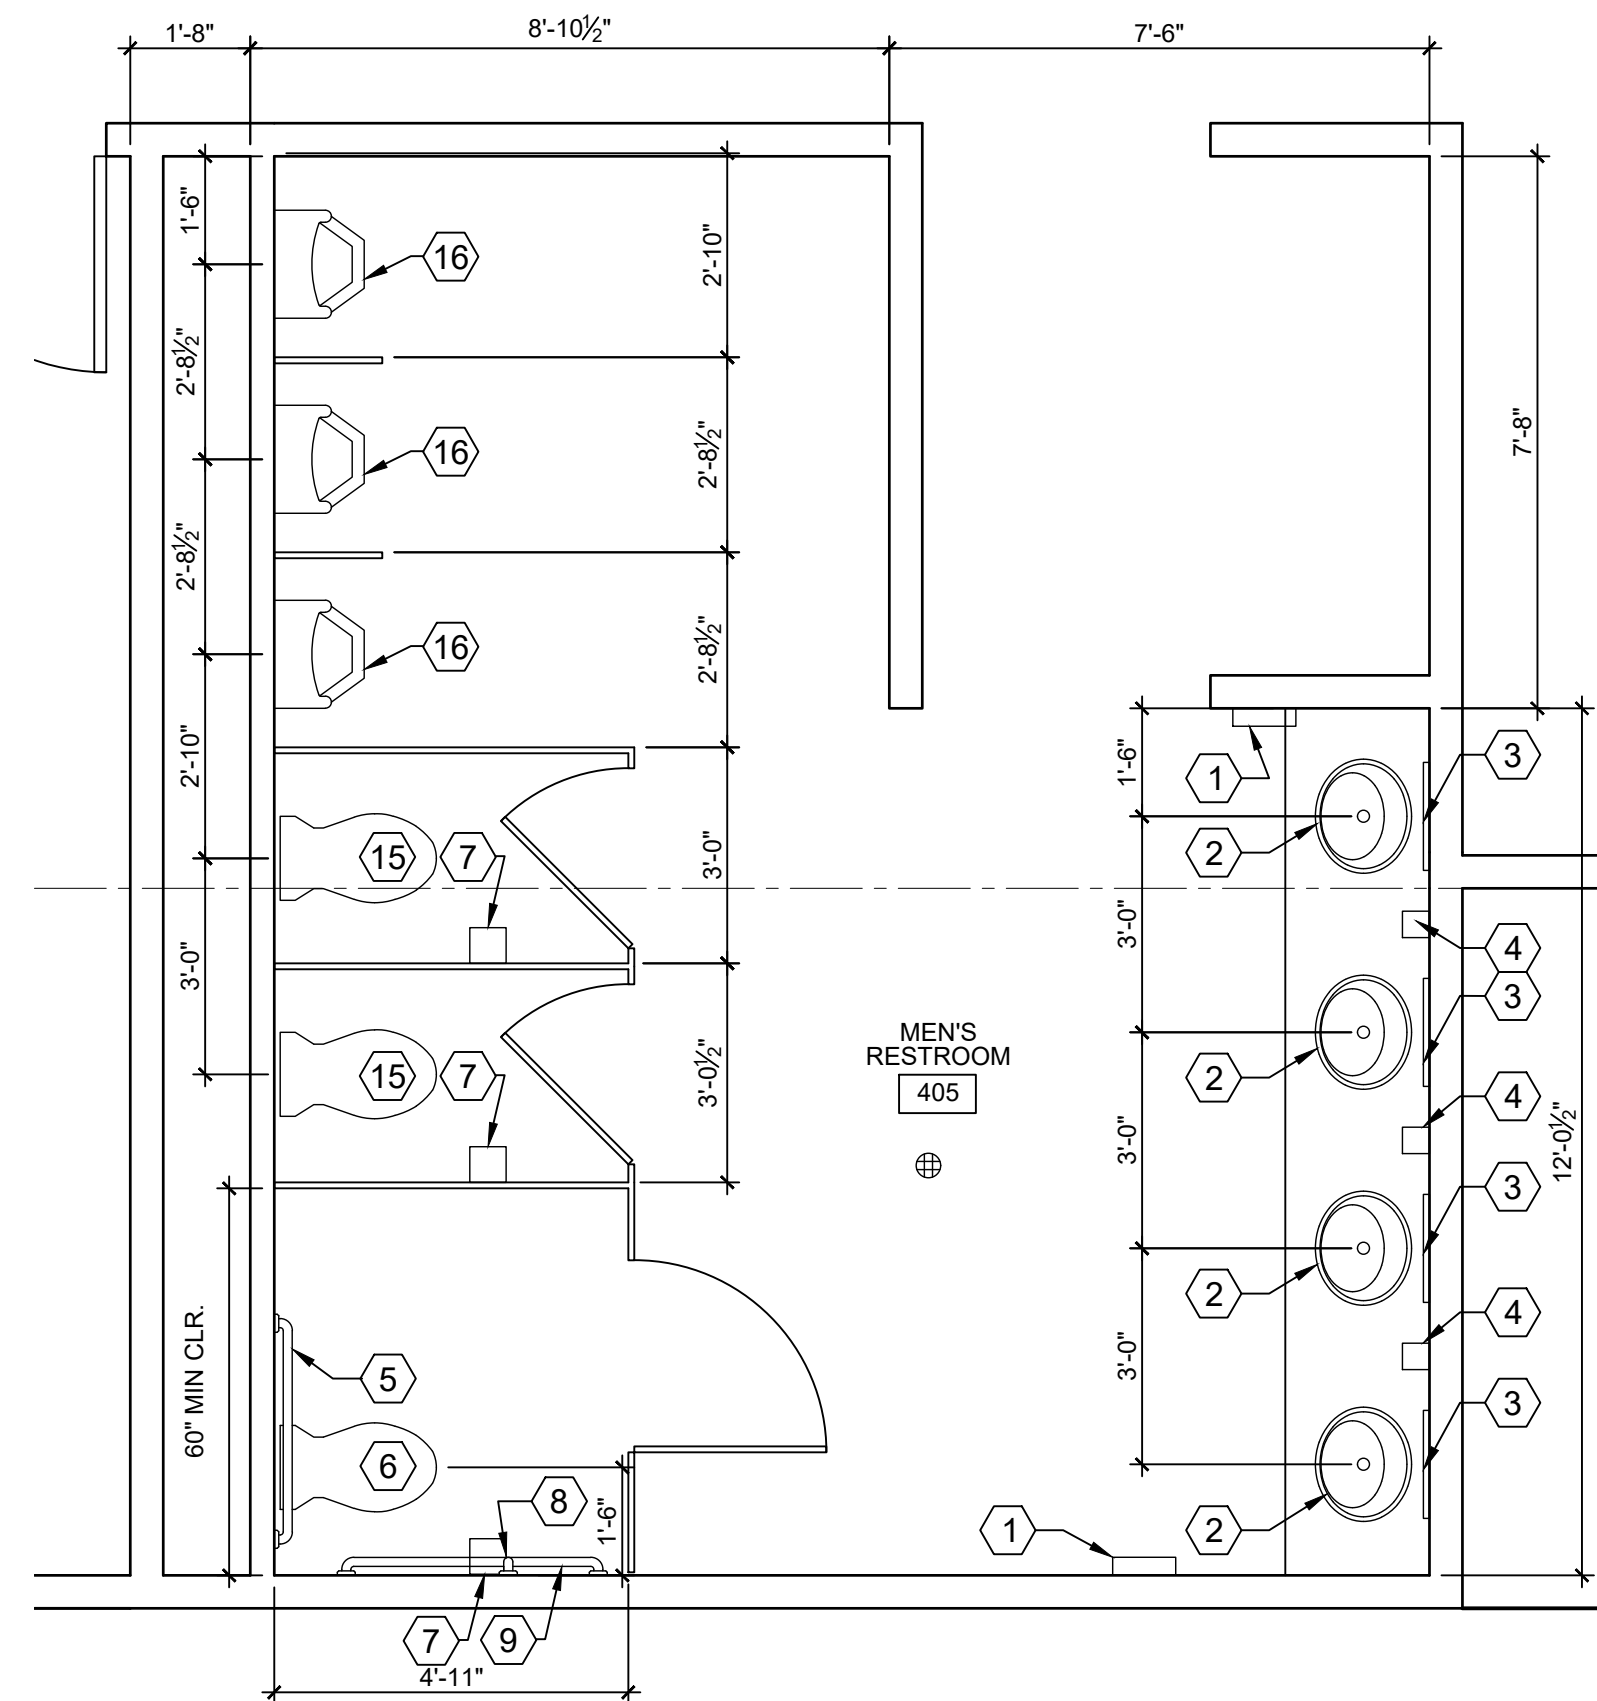

5 MEN'S RESTROOM 405
3/8" = 1'-0"

DESIGN DEVELOPMENT

REV	ISSUED FOR	DATE

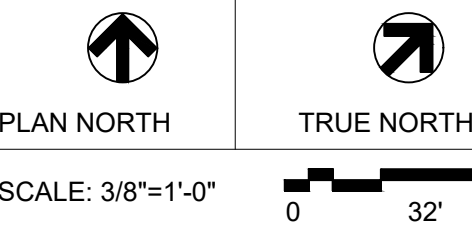

LIGHTHOUSE MISSION RE-BUILD


THIRD AND FOURTH FLOOR ENLARGED PLANS

PROJECT No: 202009.02
DRAWN BY: AK
CHECKED BY: AK
DATE ISSUED: 07.10.22


A2.23

TOILET ACCESSORY &
PLUMBING LEGEND

- 1 SURFACE MOUNTED PAPER TOWEL DISPENSER
OWNER PROVIDED/OWNER INSTALLED
- 2 NEW SINK w/ SHROUD AND FAUCET TO MATCH
BUILDING STANDARD
- 3 MIRROR
BOBRICK #B-165 1830
- 4 SOAP DISPENSER
BOBRICK #B-2012
- 5 36" GRAB BAR
BOBRICK #B-5806X36
- 6 NEW ACCESSIBLE TOILET TO MATCH BUILDING
STANDARD
- 7 TOILET TISSUE DISPENSER
OWNER PROVIDED/OWNER INSTALLED
- 8 18" GRAB BAR
BOBRICK #B-5806X18
- 9 42" GRAB BAR
BOBRICK #B-5806X42
- 10 NEW JANITOR MOP SINK TO MATCH BUILDING
STANDARD
- 11 36 X 36 TRANSFER SHOWER
- 12 36X60 ACCESSIBLE ROLL IN SHOWER
- 13 30 X 60 SHOWER
- 14 BATH TUB
- 15 STANDARD TOILET
- 16 URINAL
- 17 ADA URINAL
- 18 NAPKIN DISPENSER

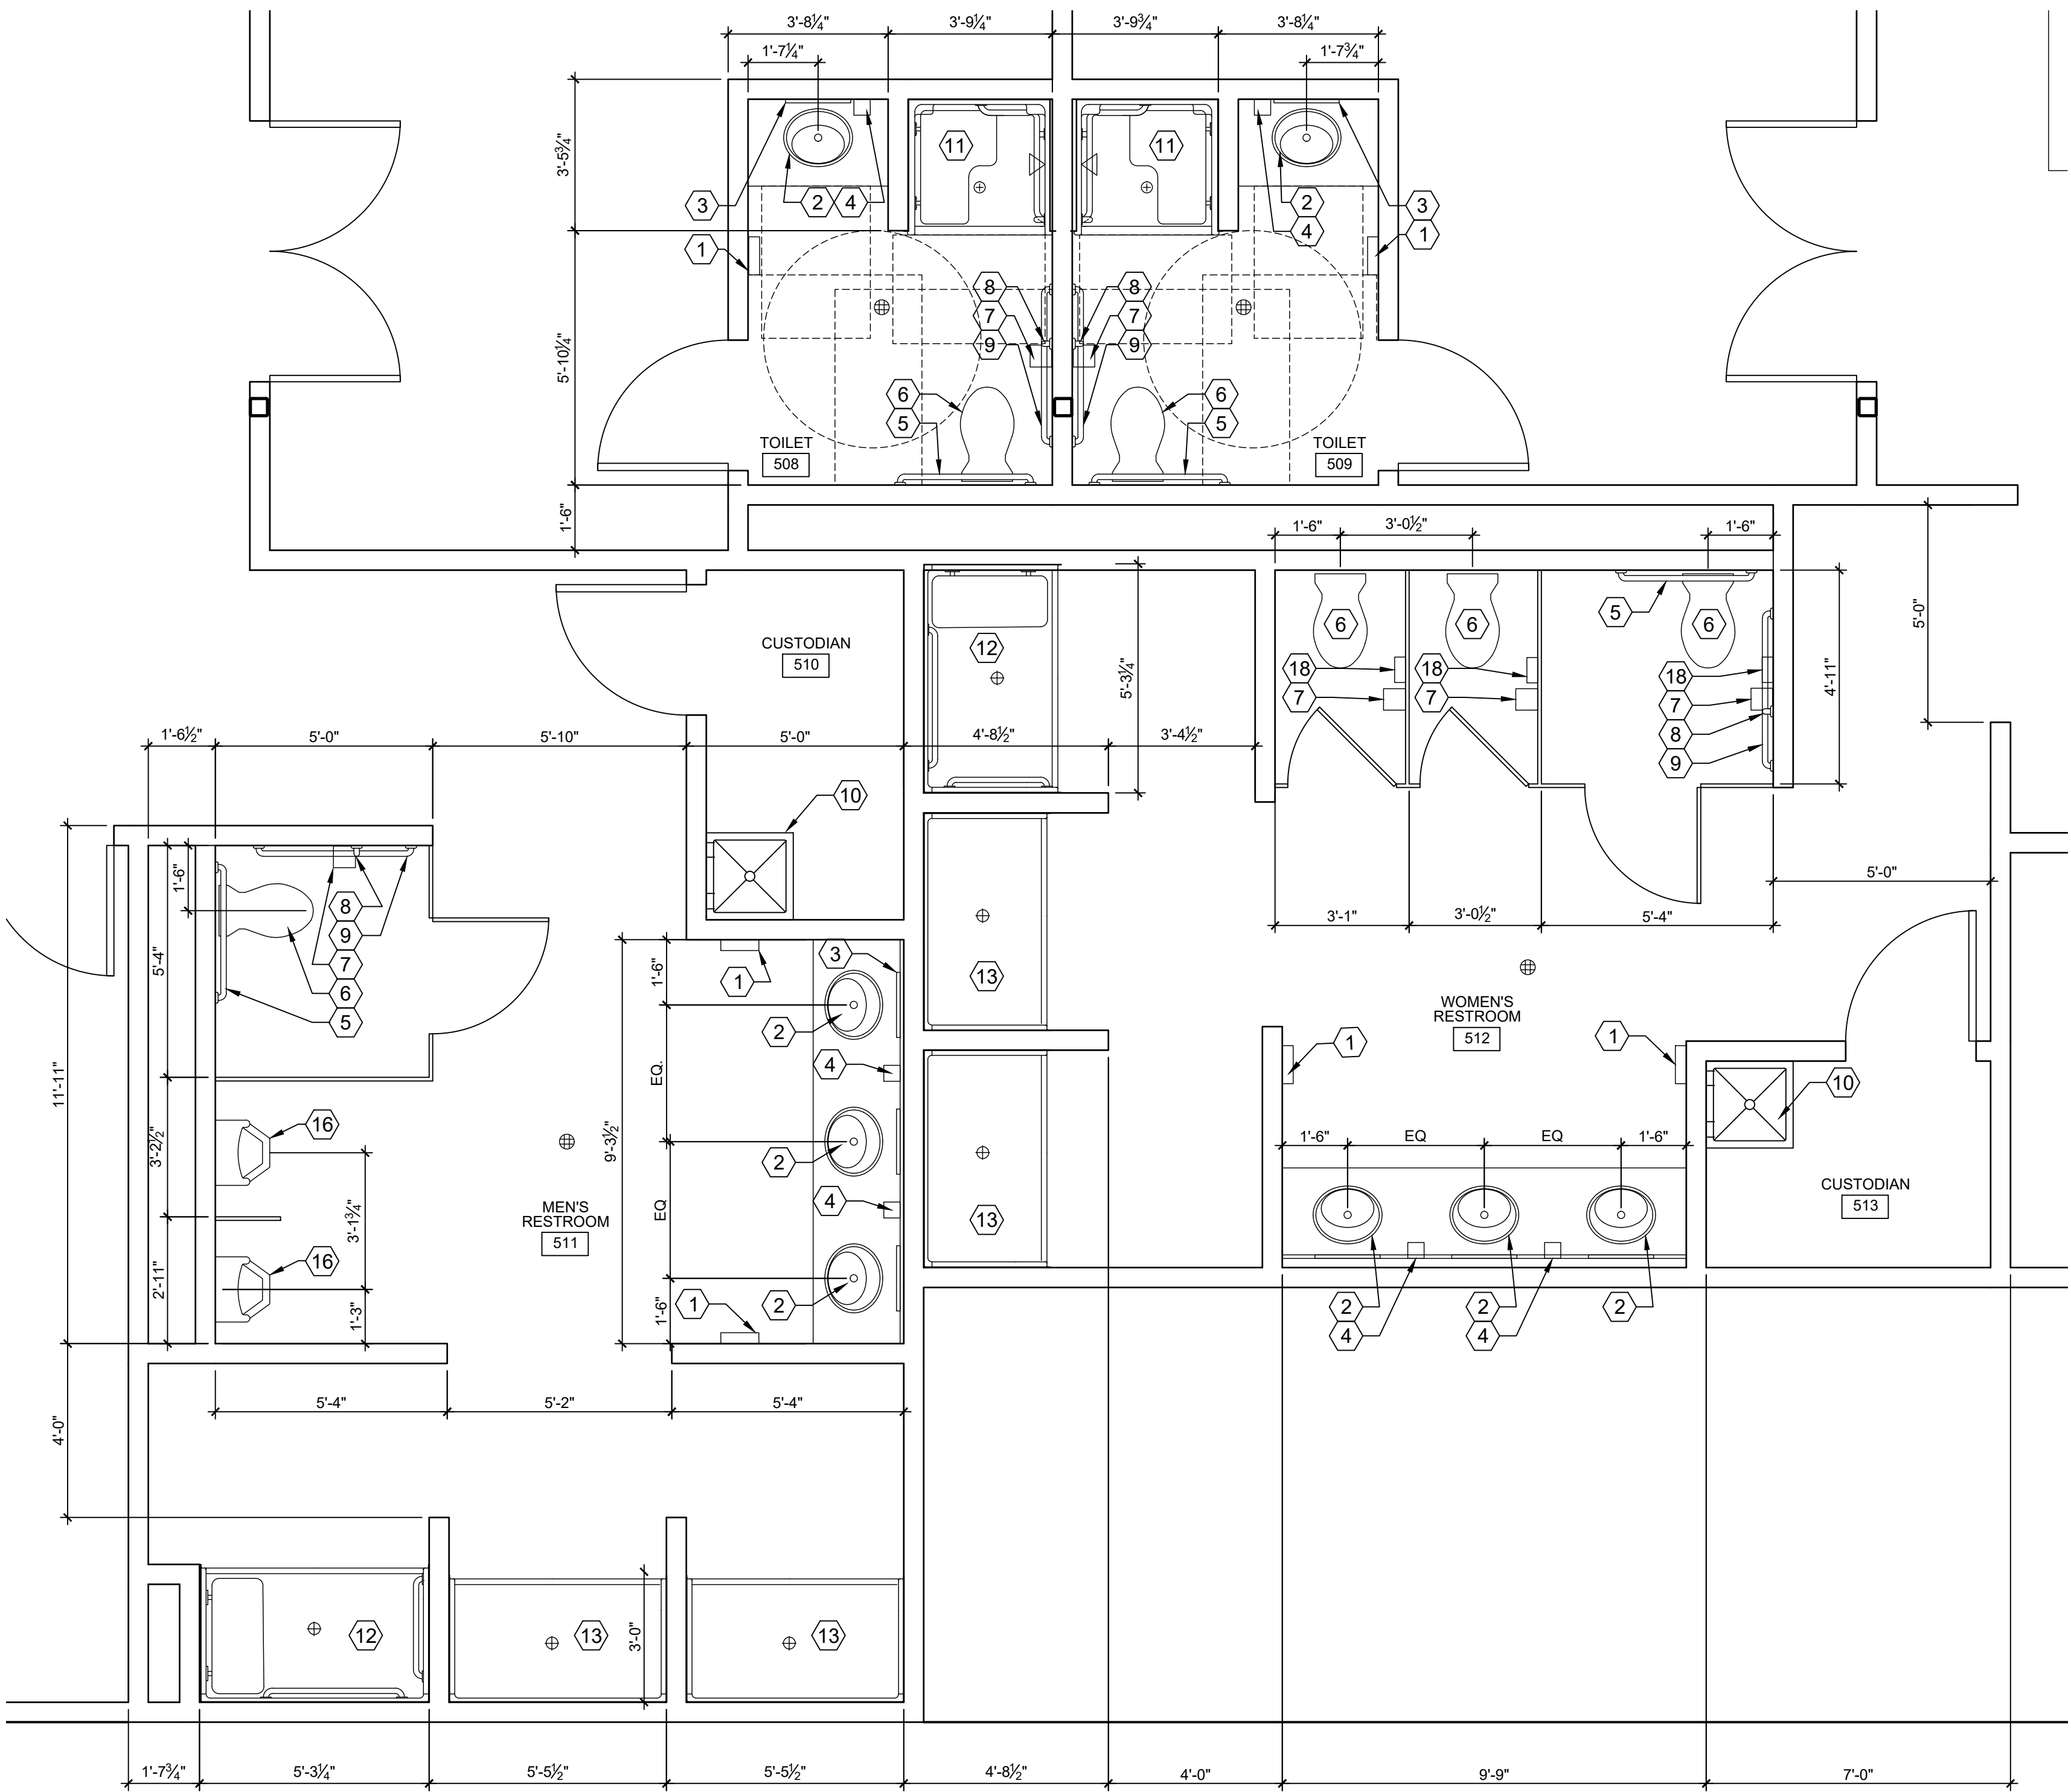

1 FIFTH FLOOR ENLARGED RESTROOM PLANS
3/8" = 1'-0"

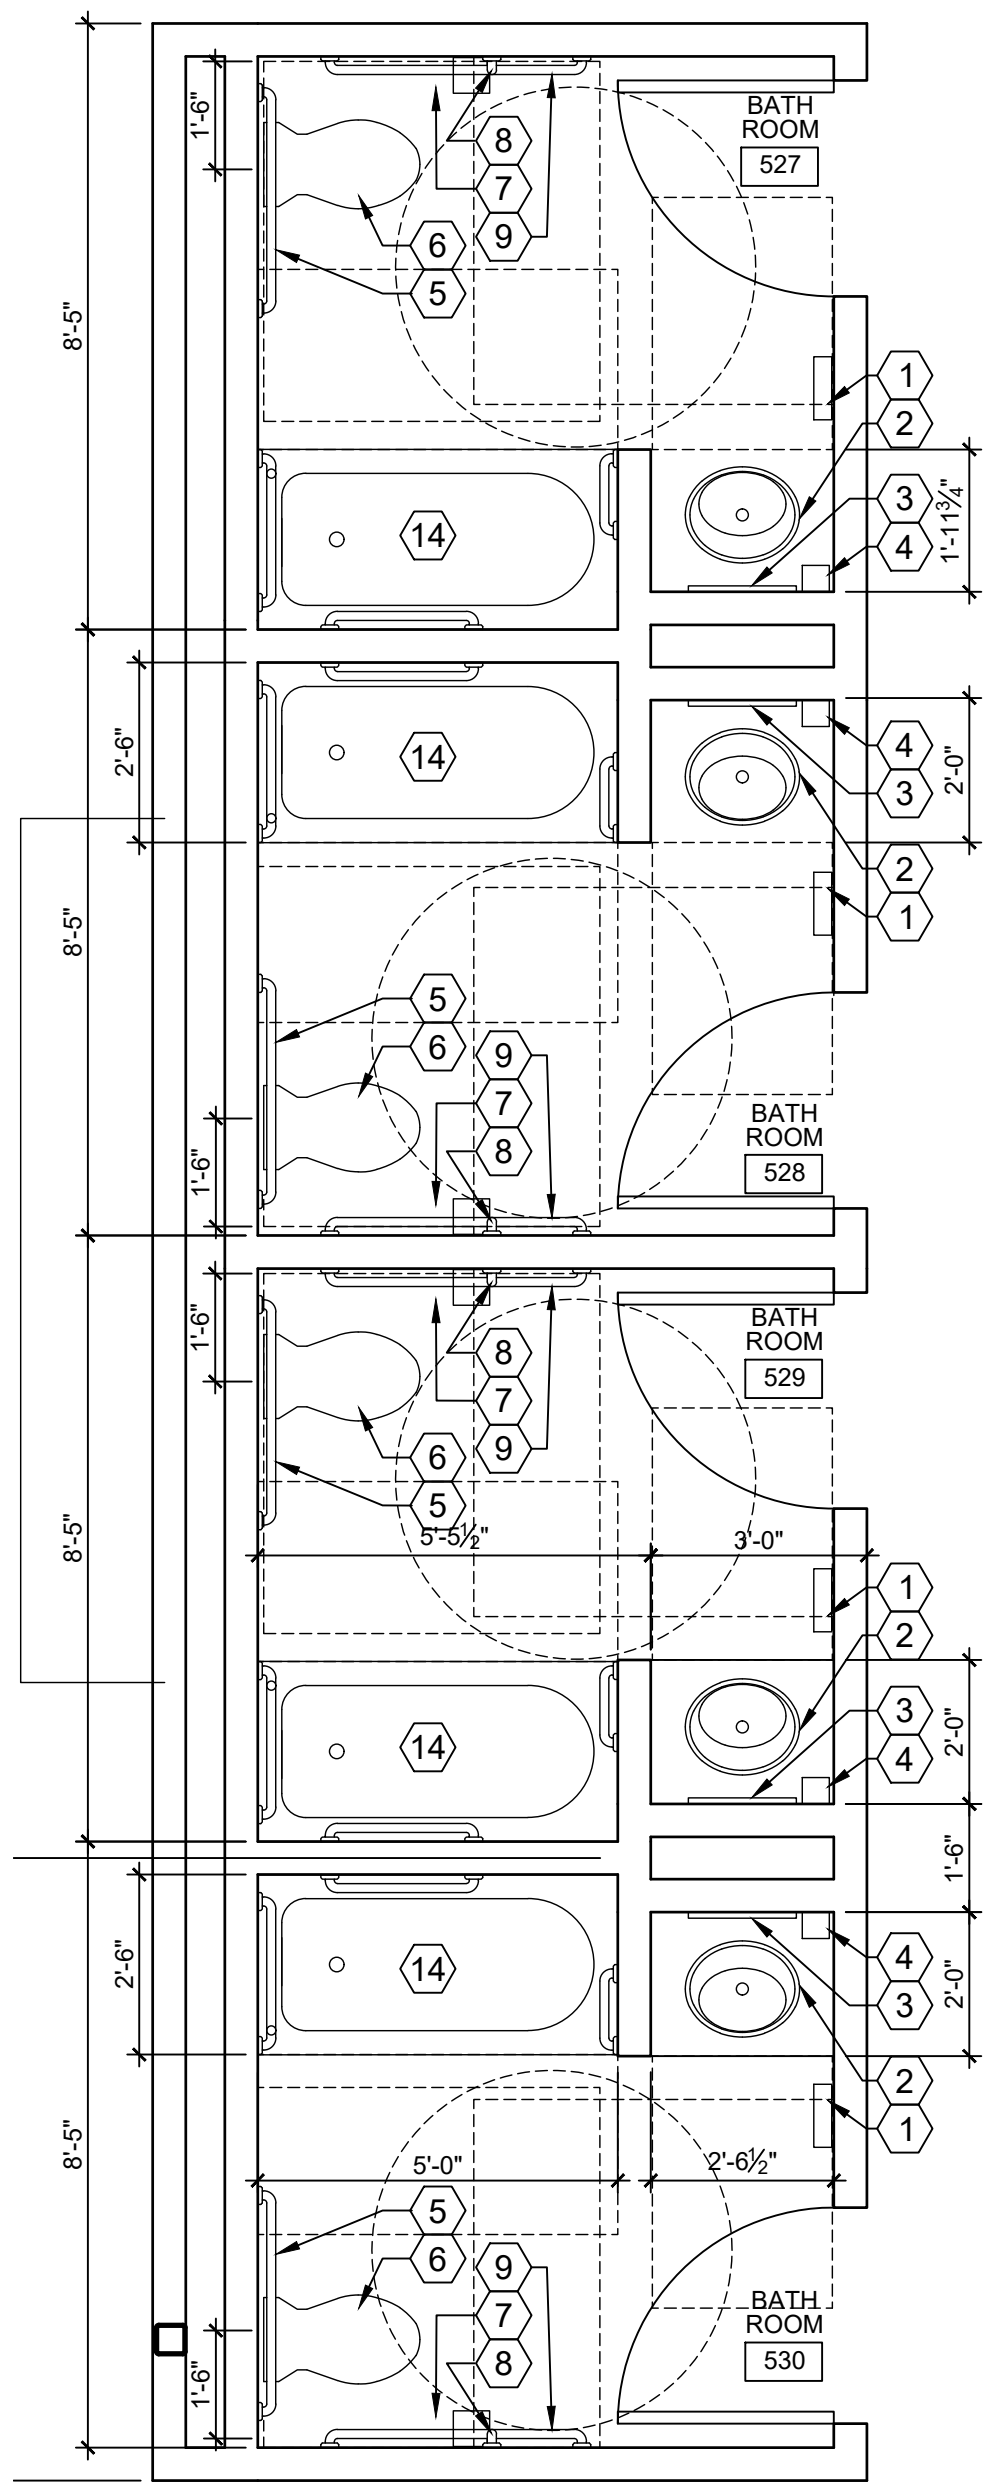

2 ENLARGED BATHROOM PLANS 527, 528, 529, 530
3/8" = 1'-0"

DESIGN
DEVELOPMENT


REV	ISSUED FOR	DATE

PLAN NORTH	TRUE NORTH
SCALE: 3/8"=1'-0"	0 32'

LIGHTHOUSE
MISSION
RE-BUILD

FIFTH FLOOR
ENLARGED FLOOR
PLANS

PROJECT No:	202009.02
DRAWN BY:	AK
CHECKED BY:	AK
DATE ISSUED:	07.10.22

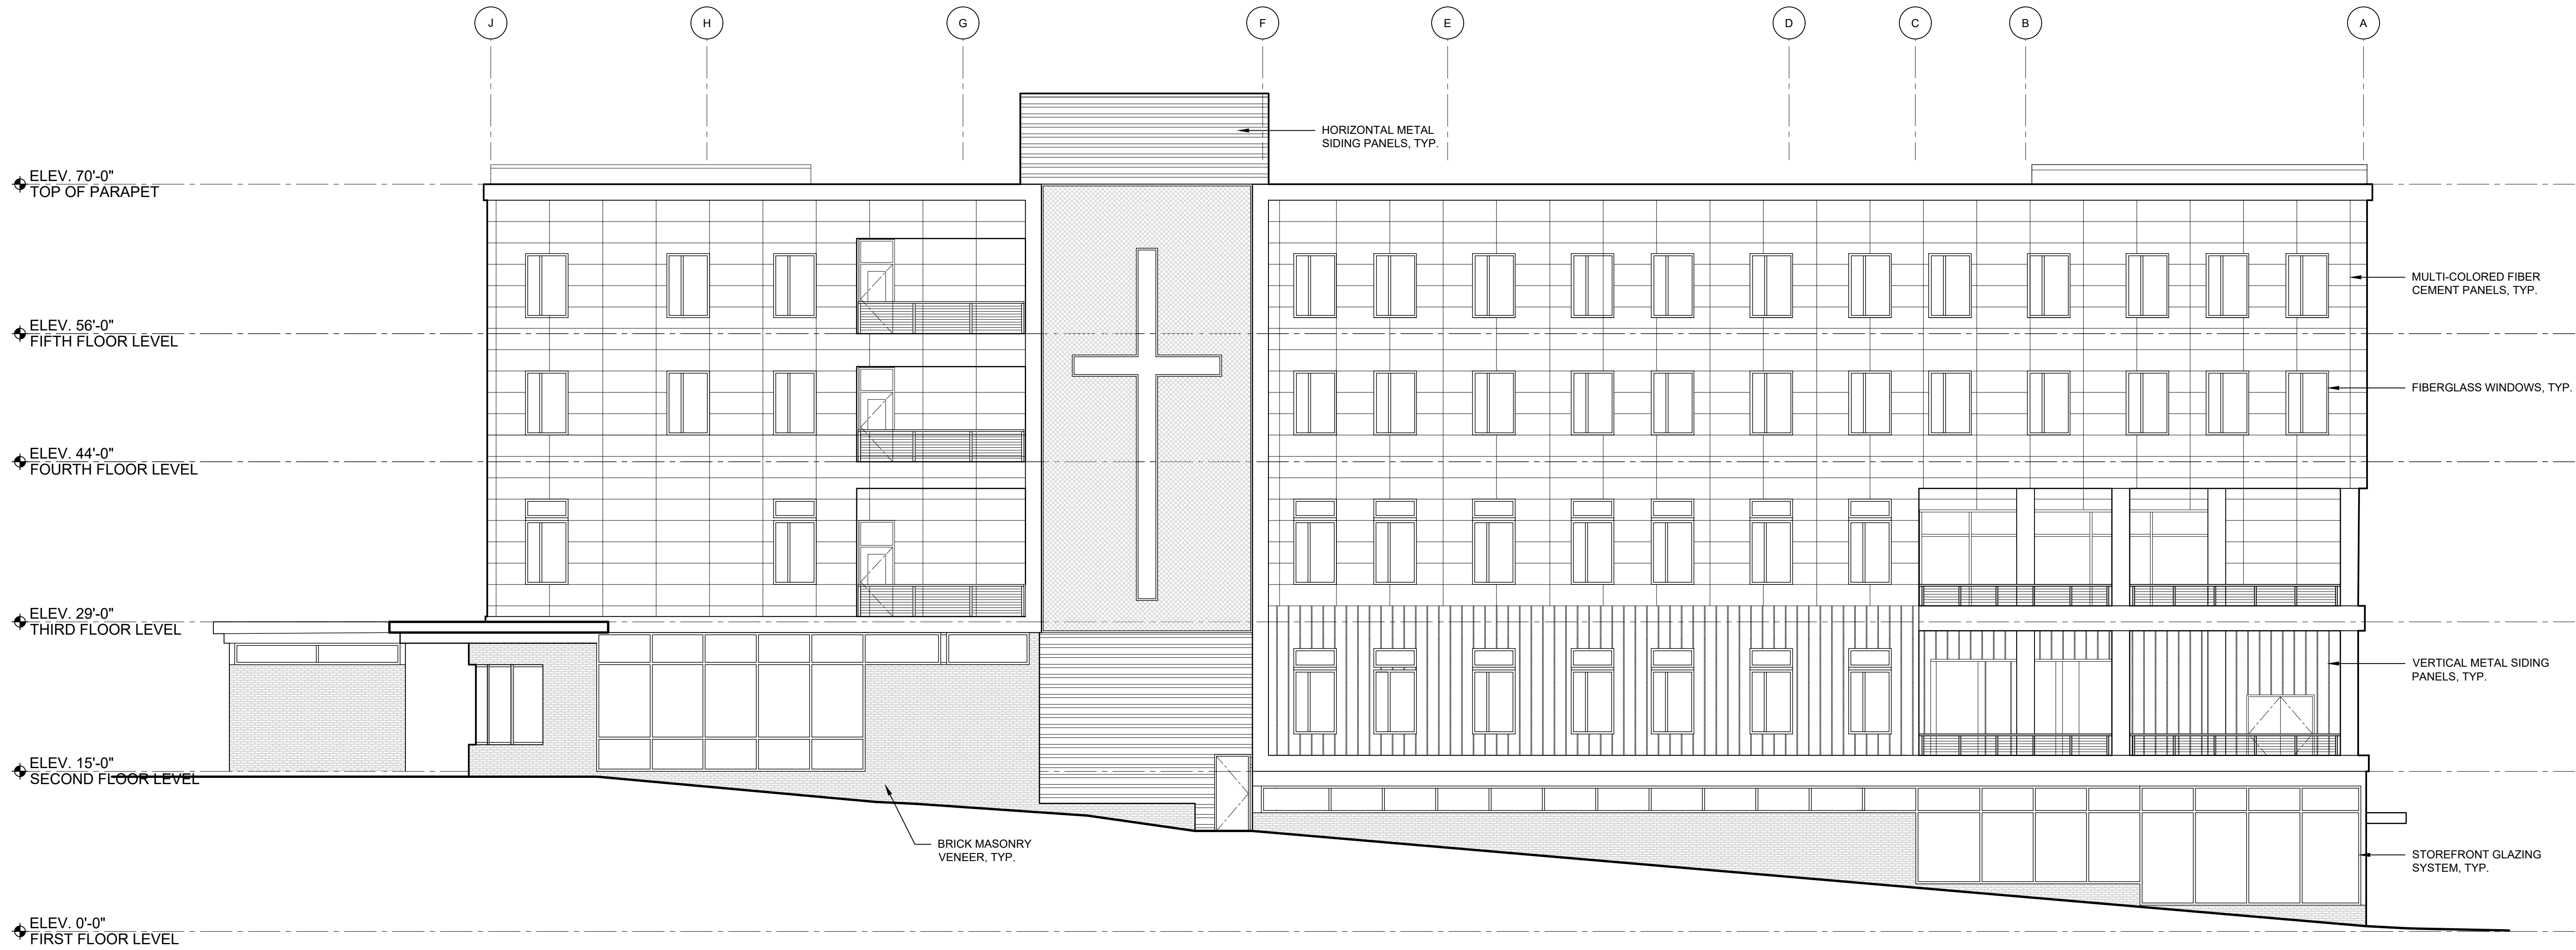

1 NORTH ELEVATION
1/8" = 1'-0"



2 WEST ELEVATION
1/8" = 1'-0"



ARCHITECTURE | INTERIOR DESIGN
zervasgroup.com
209 Prospect Street
Bellingham, WA 98225
360.734.4744

DESIGN DEVELOPMENT

REV	ISSUED FOR	DATE


PLAN NORTH


TRUE NORTH

SCALE: 1/8"=1'-0"


0 8'


LIGHTHOUSE MISSION RE-BUILD

EXTERIOR ELEVATIONS

PROJECT No: 202009.02
DRAWN BY: AK
CHECKED BY: AK
DATE ISSUED: 07.10.22

A3.01

© 2019

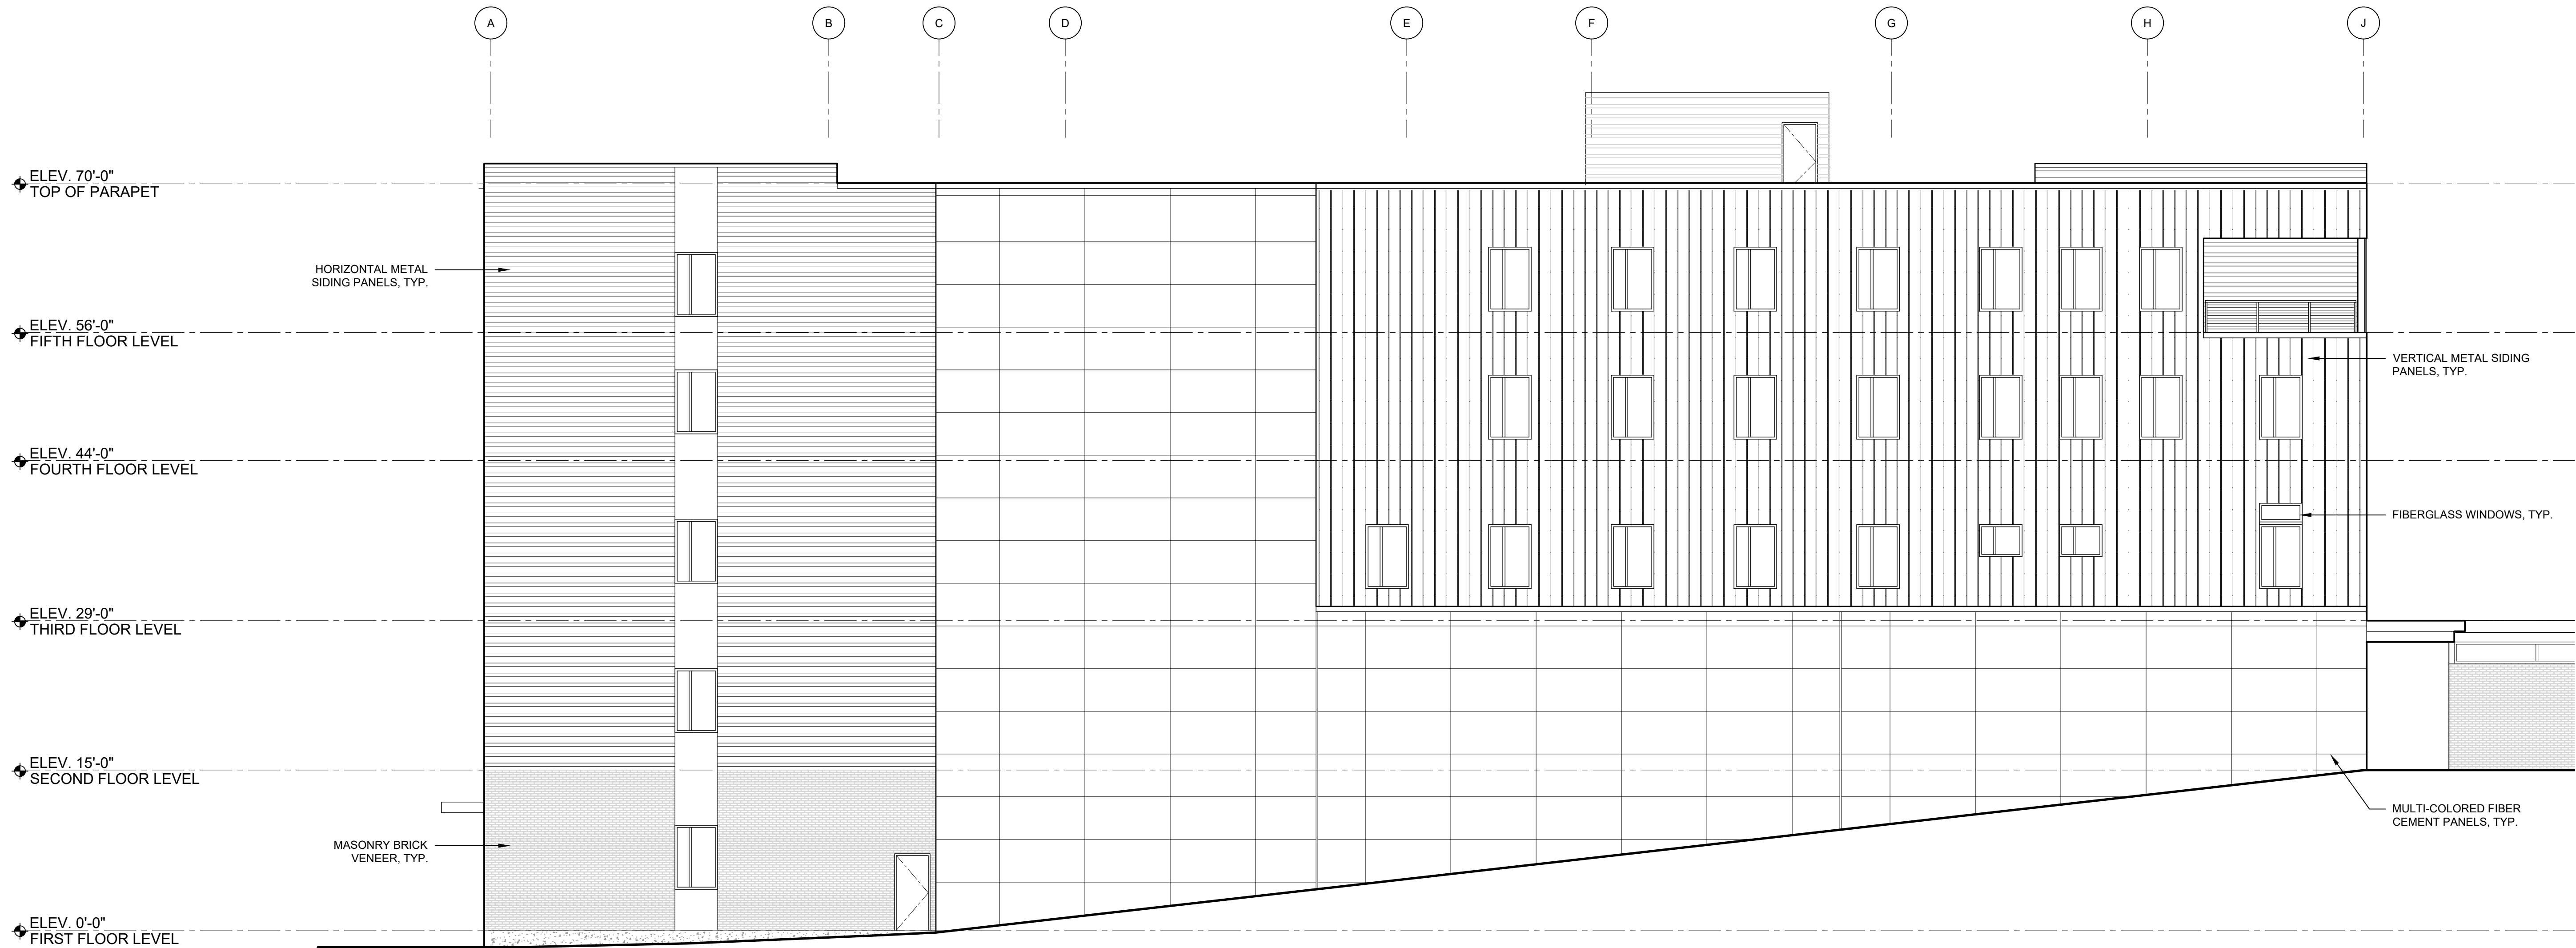

1 SOUTH ELEVATION
1/8" = 1'-0"




2 EAST ELEVATION
1/8" = 1'-0"



ARCHITECTURE | INTERIOR DESIGN
zervasgroup.com
209 Prospect Street
Bellingham, WA 98225
360.734.4744

DESIGN DEVELOPMENT

REV	ISSUED FOR	DATE

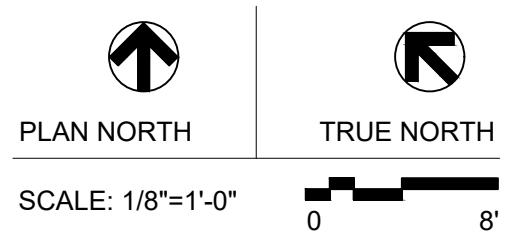

LIGHTHOUSE MISSION RE-BUILD

EXTERIOR ELEVATIONS



PROJECT No: 202009.02
DRAWN BY: AK
CHECKED BY: AK
DATE ISSUED: 07.10.22

A3.02

© 2019



ARCHITECTURE | INTERIOR DESIGN
zervasgroup.com
209 Prospect Street
Bellingham, WA 98225
360.734.4744

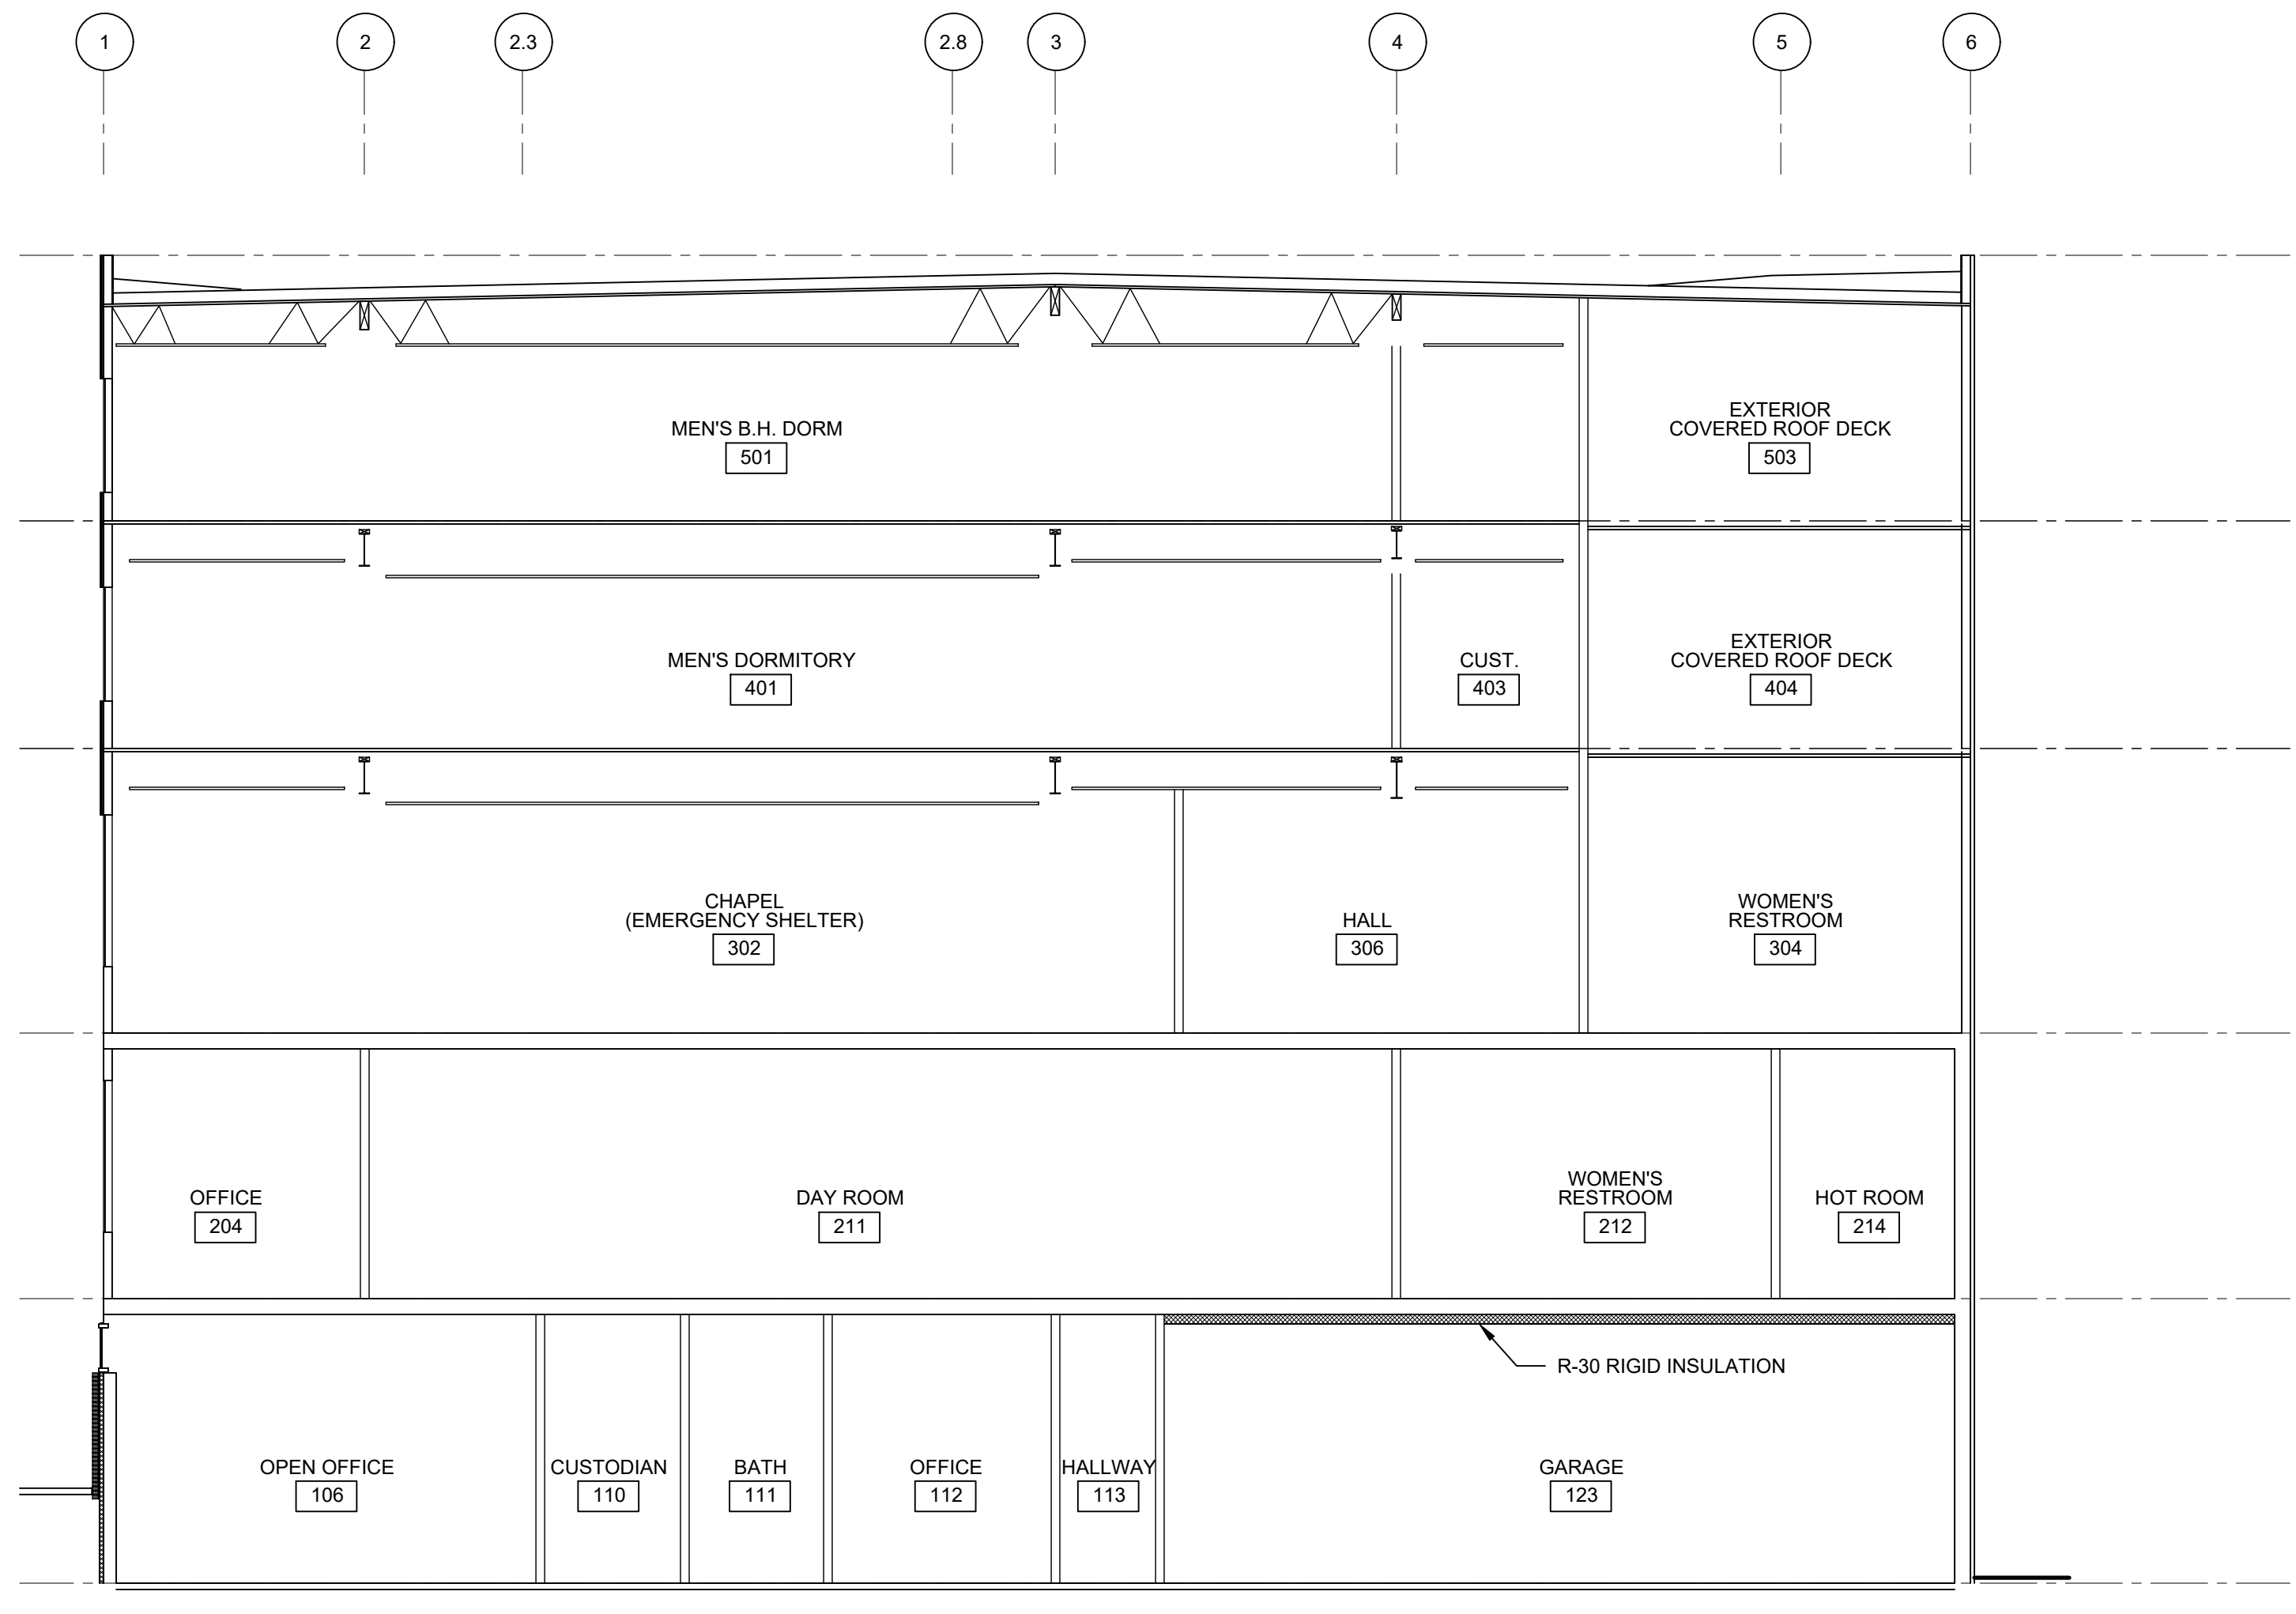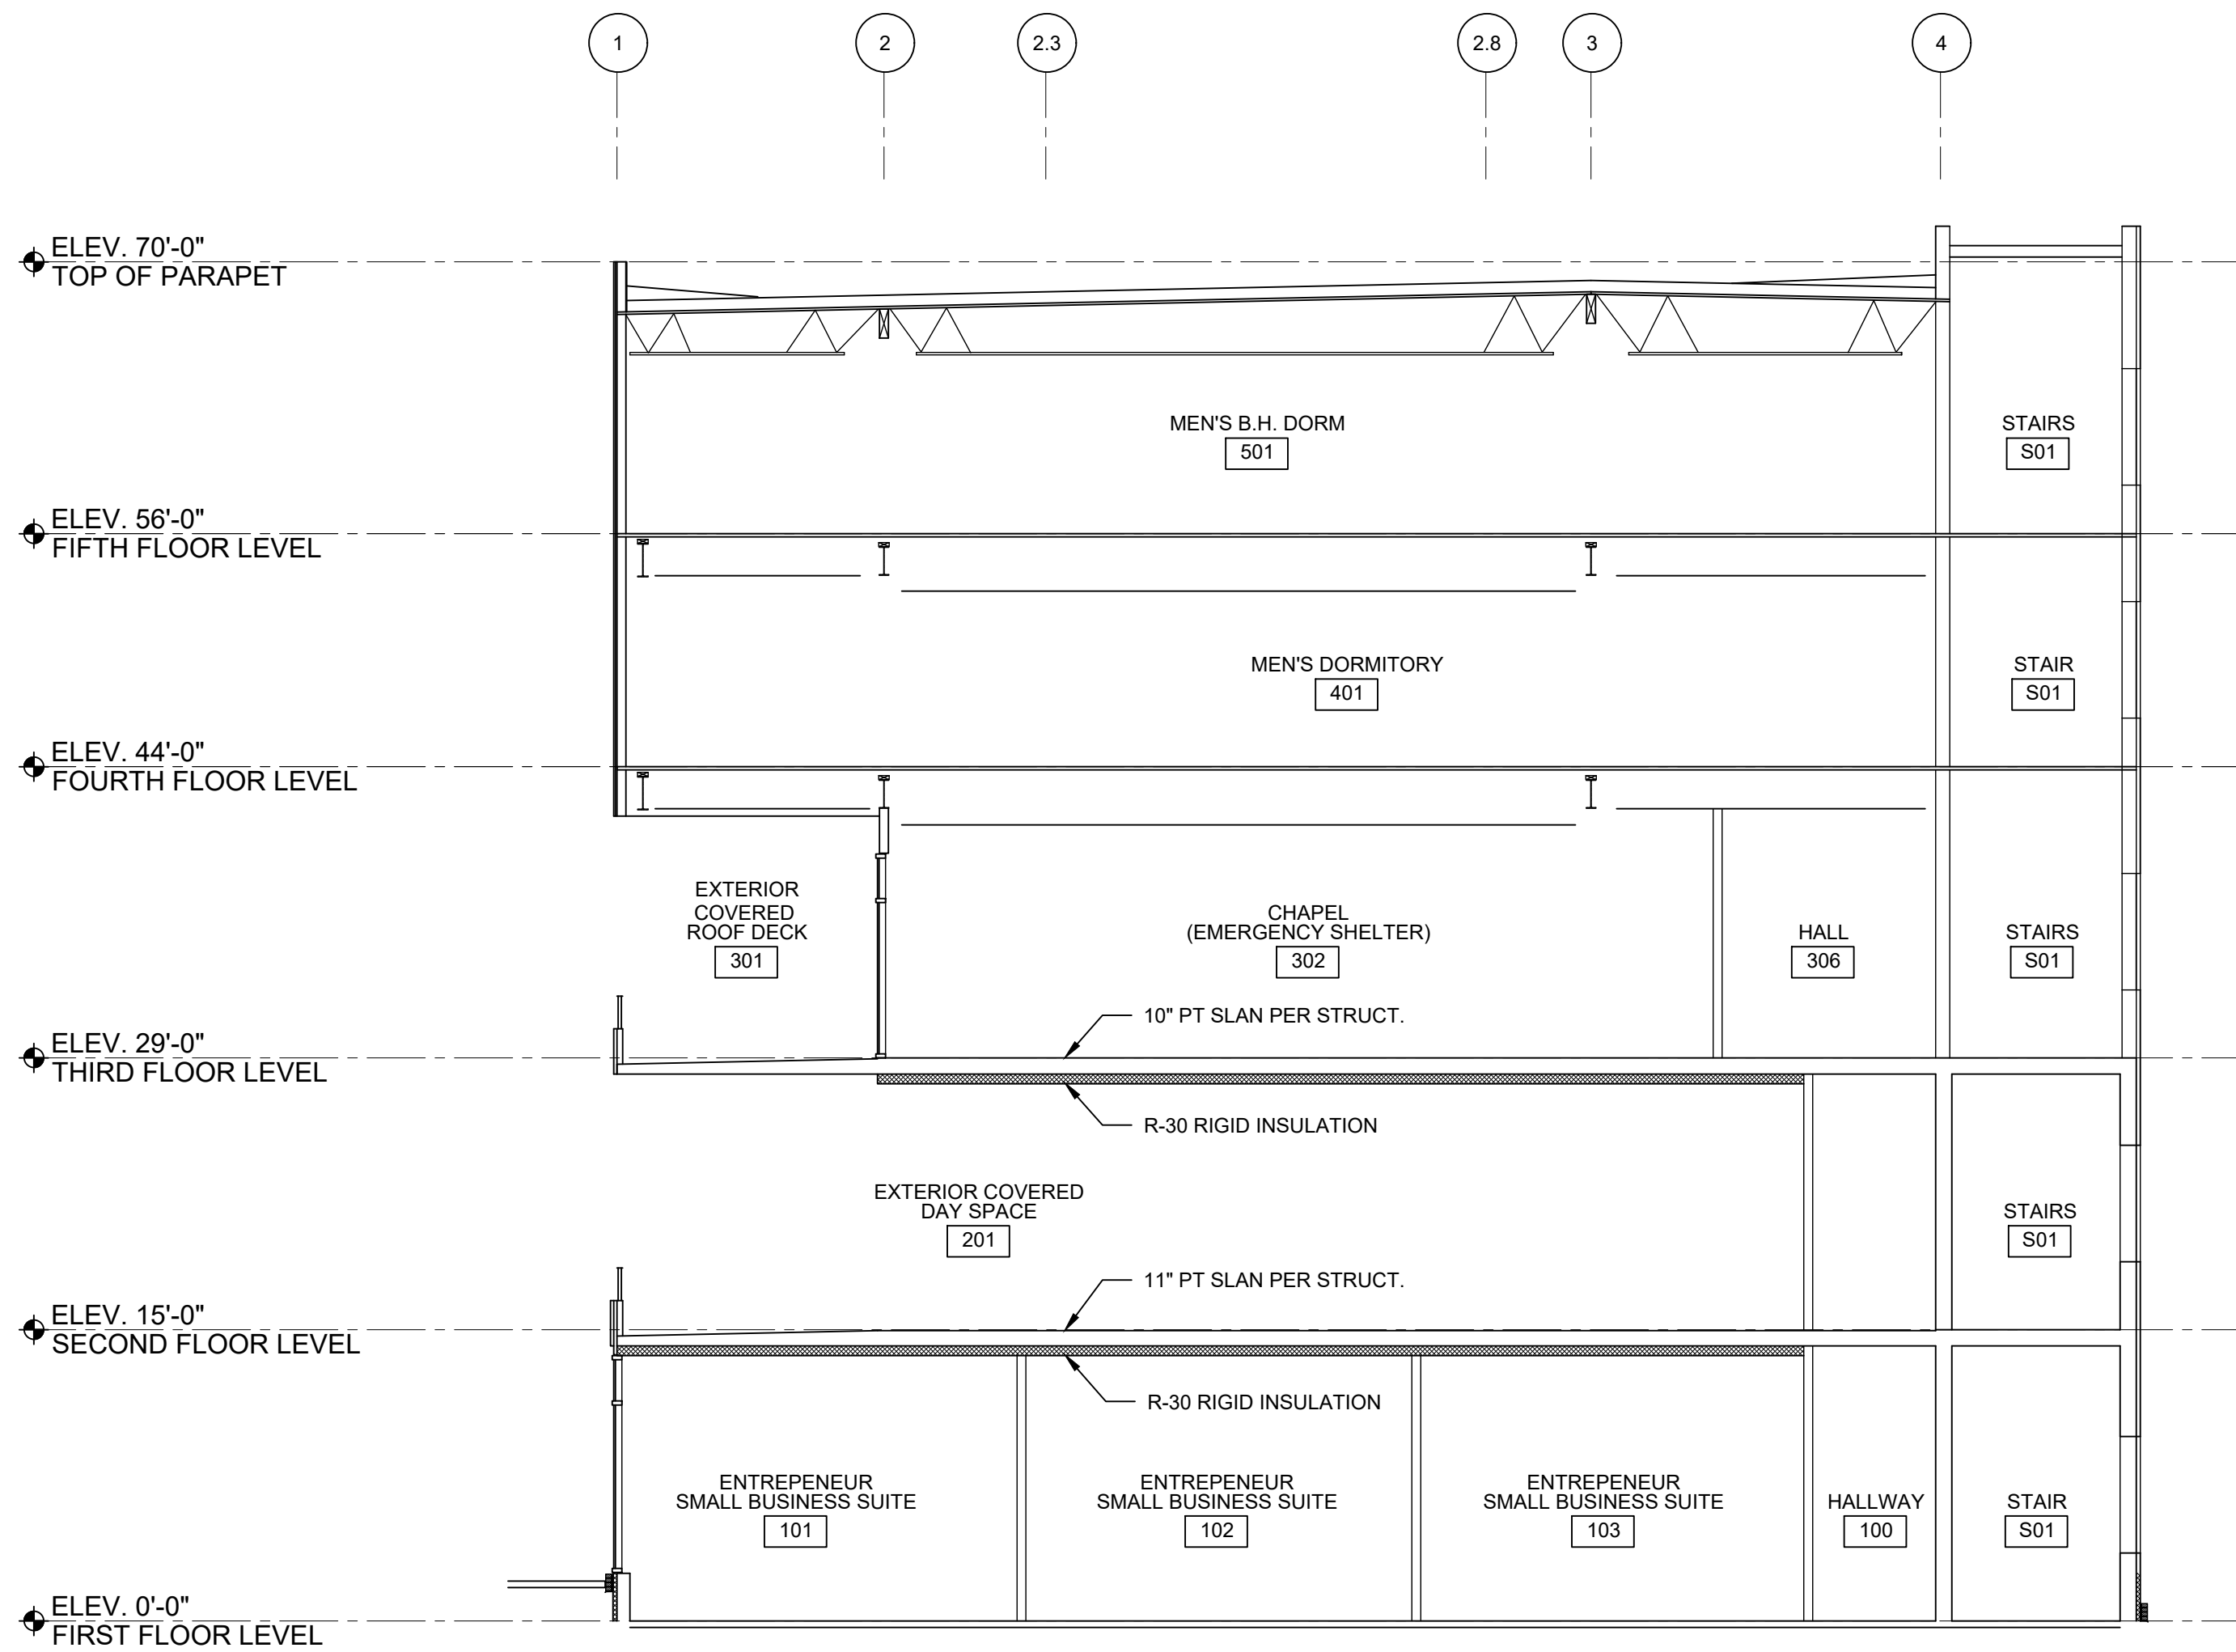

- 1 HOUR RATED WOOD FRAMED ROOF/CEILING:
- MEMBRANE ROOFING
 - 1/4" GYPSUM COVER BOARD
 - R-38 CONT. RIGID INSULATION
 - VAPOR BARRIER
 - SHEATHING PER STRUCT.
 - TRUSSES PER STRUCTURAL
 - 1 LAYER 1/2"25 GA. RESILIENT CHANNELS @ 16" O.C.
 - 1 LAYER 5/8" TYPE X GWB

ELEV. 70'-0" TOP OF PARAPET

- 1 HOUR RATED WOOD FRAMED FLOOR/CEILING:
- 2" CONCRETE, FINISH PER SCHEDULE
 - PLYWOOD SUBFLOOR PER STRUCT.
 - TRUSSES PER STRUCTURAL
 - 1 LAYER 3-1/2" UNFACED GLASS FIBER
 - 1 LAYER 25 GA. RESILIENT CHANNELS @ 16" O.C.
 - 1 LAYER 5/8" TYPE X GWB


ELEV. 56'-0" FIFTH FLOOR LEVEL

ELEV. 44'-0" FOURTH FLOOR LEVEL

ELEV. 29'-0" THIRD FLOOR LEVEL

ELEV. 15'-0" SECOND FLOOR LEVEL

ELEV. 0'-0" FIRST FLOOR LEVEL

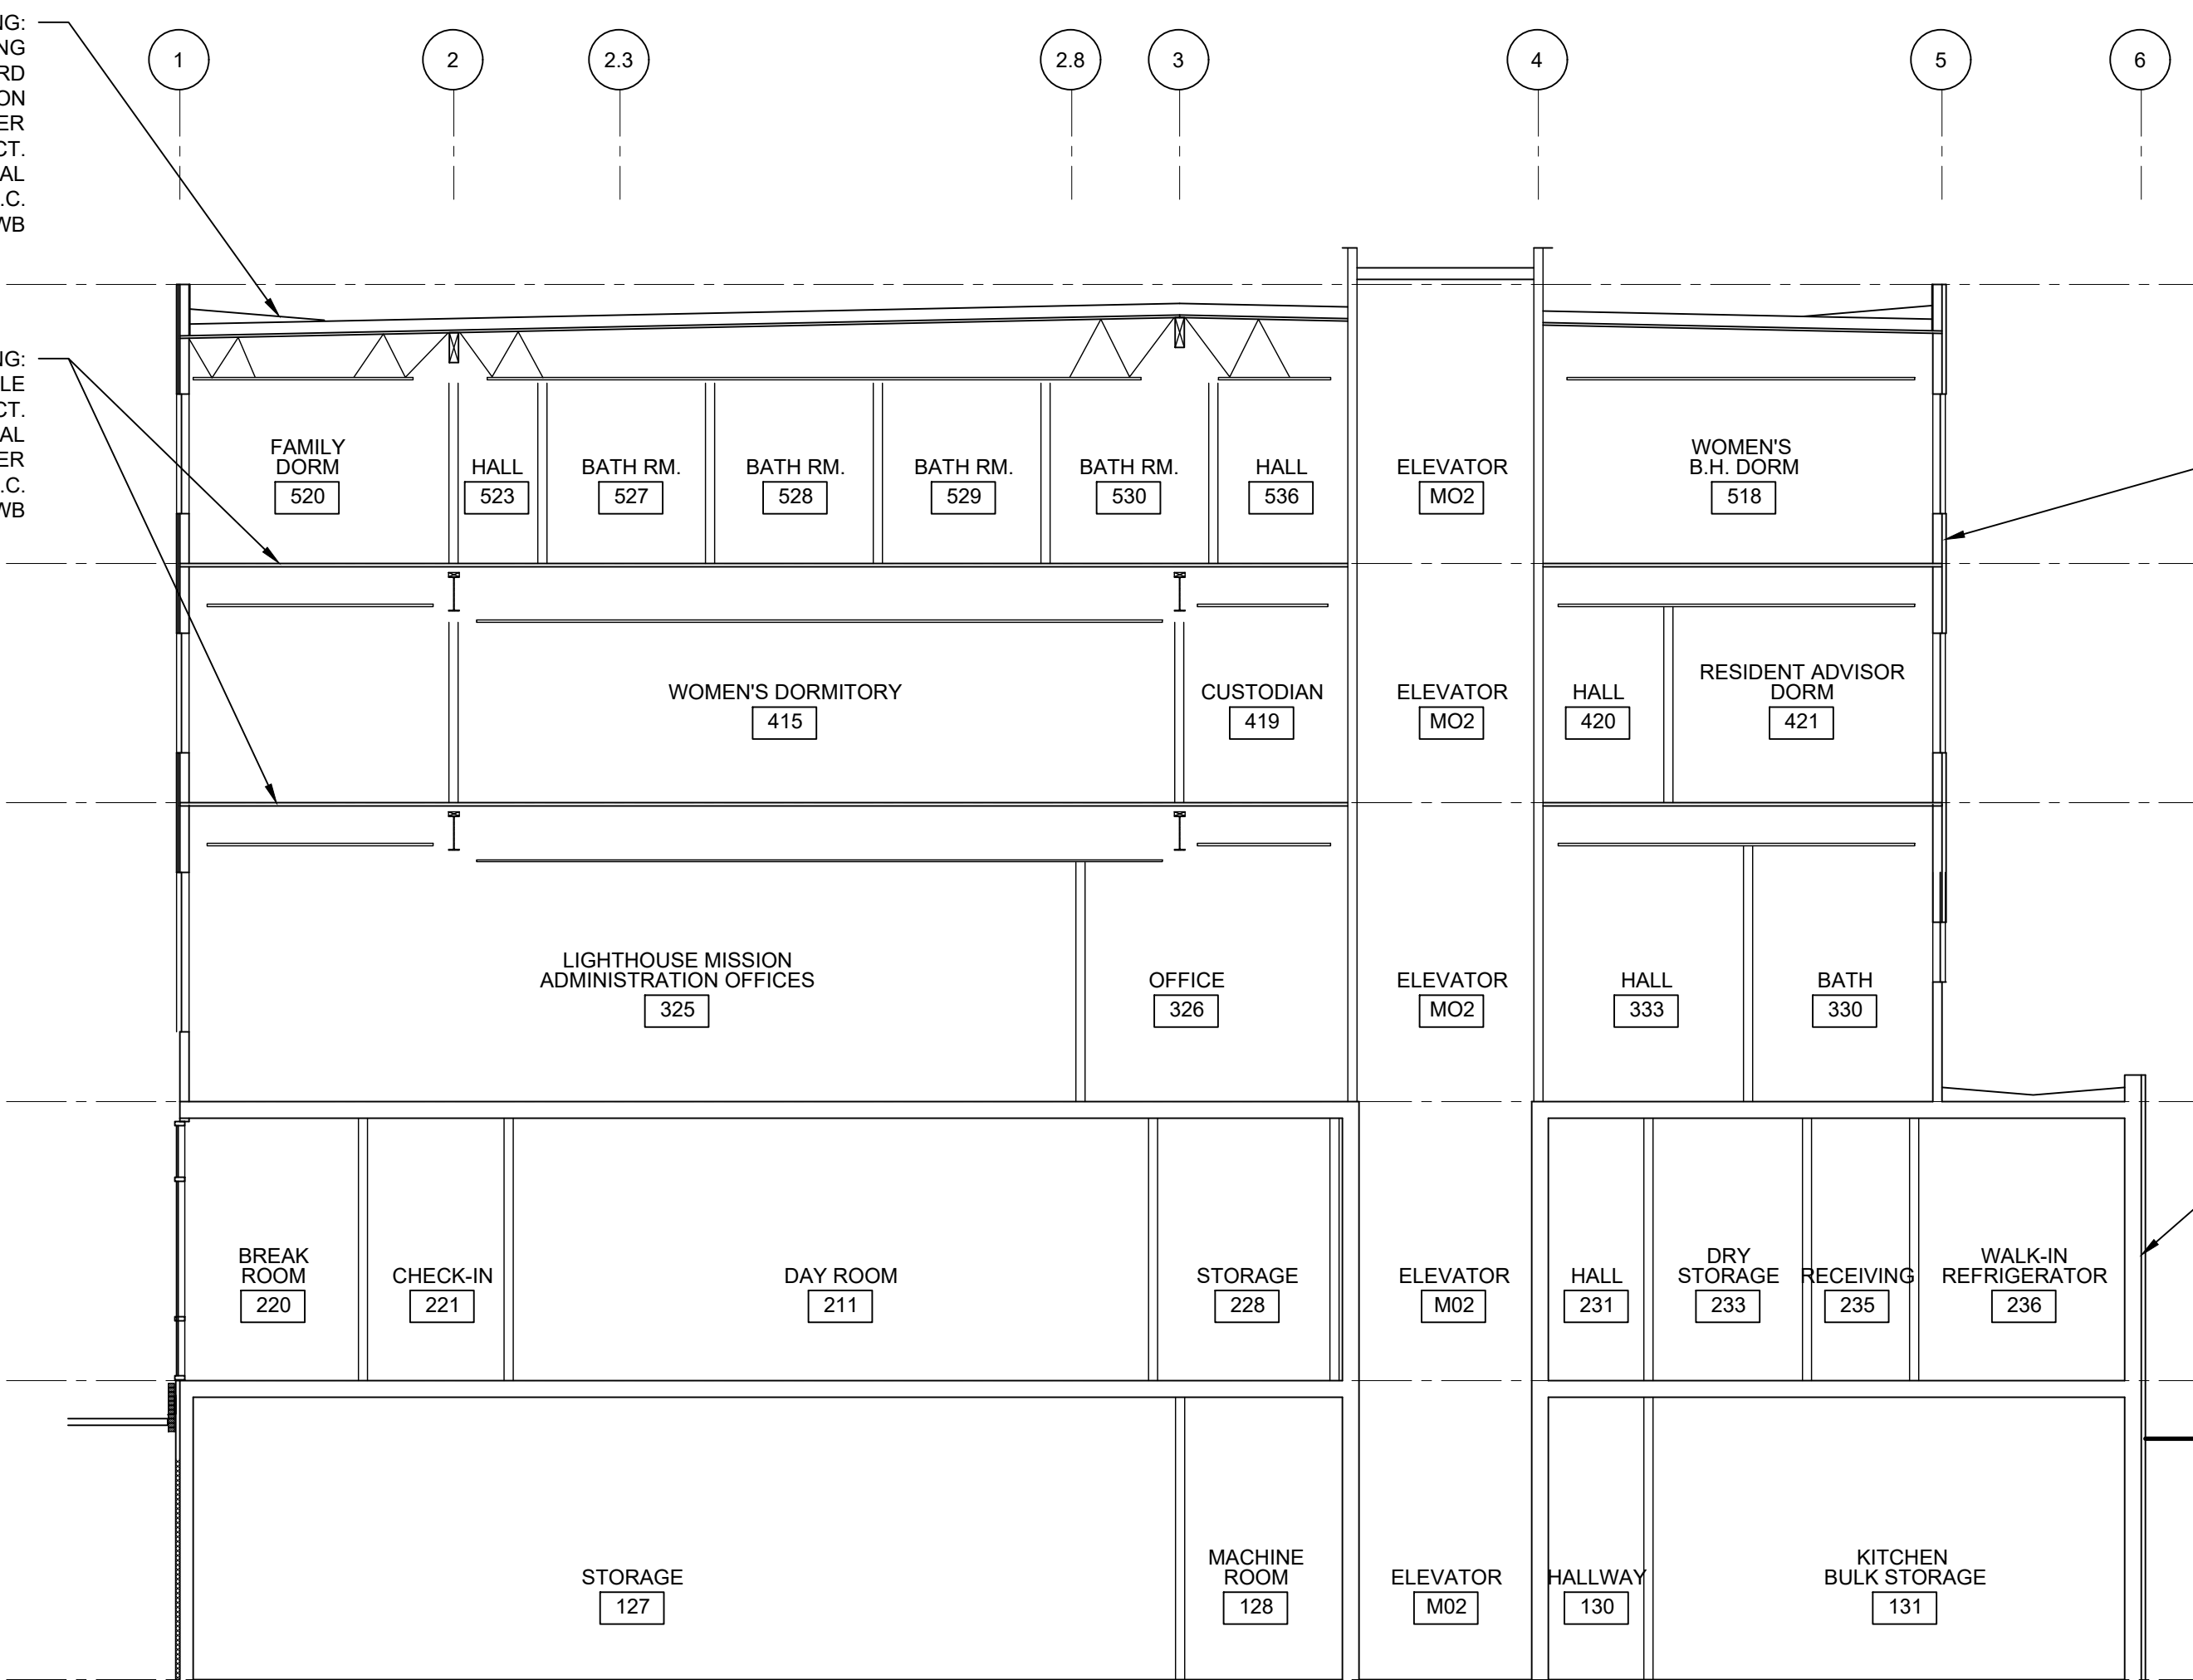


- TYP. WOOD FRAMED EXTERIOR WALL:
- SIDING PER ELEVATIONS
 - FURRING PER MFR
 - CONT. 2.5" (R-10) MINERAL WOOL INSULATION W/ COMPOSITE (THERMALLY BROKEN) SUBFRAMING SYSTEM
 - CONT. FLUID APPLIED AIR BARRIER, SEAL ALL PENETRATIONS
 - SHEATHING PER STRUCTURAL
 - 2X6 WOOD STUDS @ 16" O.C.
 - R-21 BATT INSULATION
 - 6-MIL VAPOR RETARDER, SEAL ALL PENETRATIONS
 - 5/8" GWB, SEE FINISH PLANS FOR ADDITIONAL FINISHES

- TYP. CONCRETE EXTERIOR WALL:
- 4" BRICK VENEER
 - 1" AIR SPACE
 - CONT. 2.5" (R-10) MINERAL WOOL INSULATION W/ COMPOSITE (THERMALLY BROKEN) SUBFRAMING SYSTEM
 - CONT. FLUID APPLIED AIR BARRIER, SEAL ALL PENETRATIONS
 - SHEATHING PER STRUCTURAL
 - 2X6 WOOD STUDS @ 16" O.C.
 - R-21 BATT INSULATION
 - 6-MIL VAPOR RETARDER, SEAL ALL PENETRATIONS
 - 5/8" GWB, SEE FINISH PLANS FOR ADDITIONAL FINISHES

DESIGN DEVELOPMENT

REV	ISSUED FOR	DATE

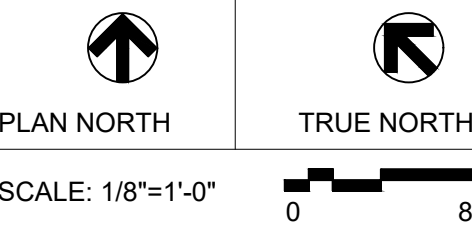


LIGHTHOUSE MISSION RE-BUILD

BUILDING SECTIONS

PROJECT No: 202009.02
DRAWN BY: AK
CHECKED BY: AK
DATE ISSUED: 07.10.22

A4.01

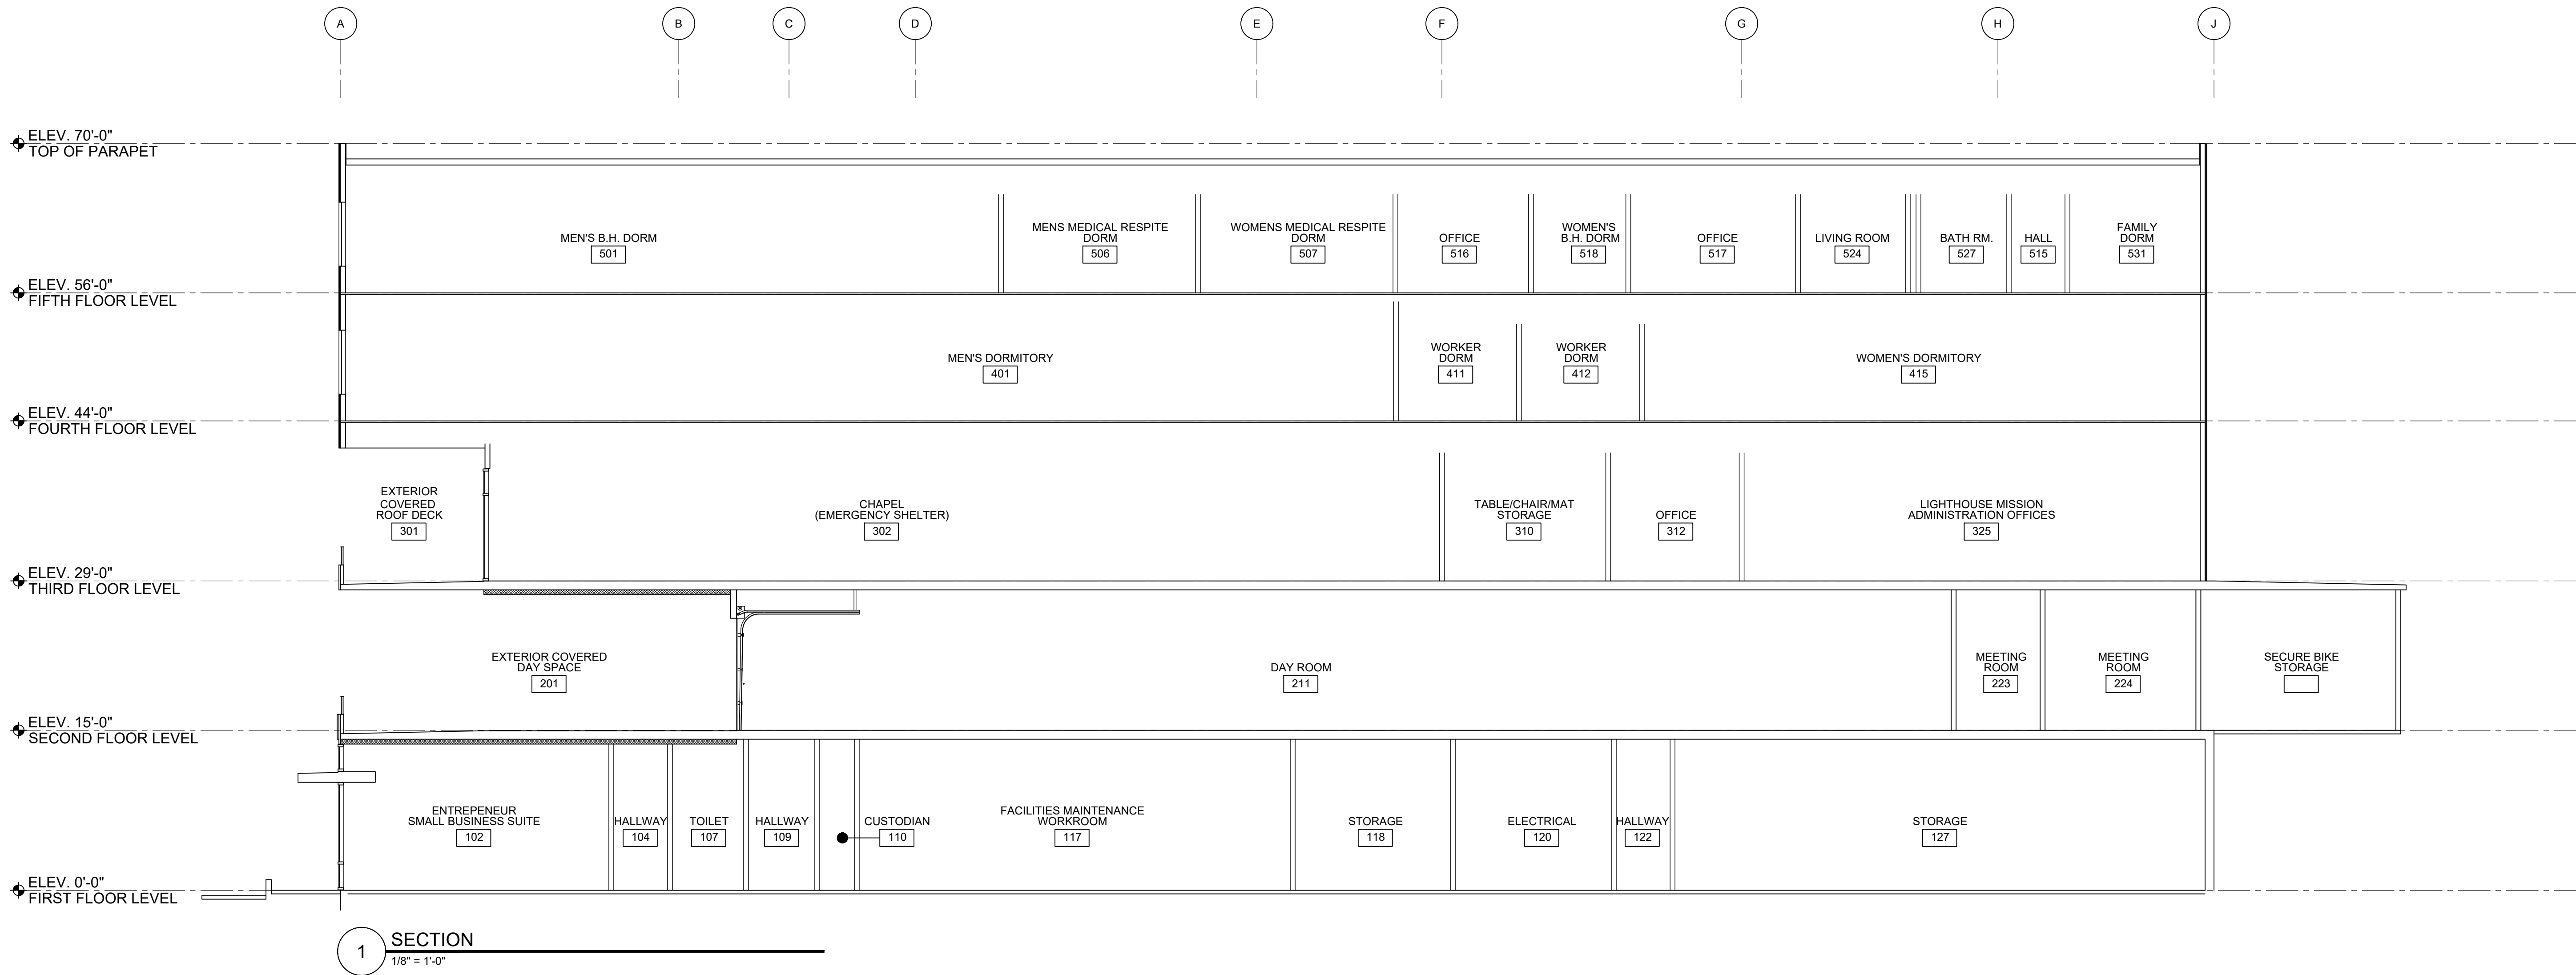

ARCHITECTURE | INTERIOR DESIGN
zervasgroup.com
209 Prospect Street
Bellingham, WA 98225
360.734.4744

DESIGN DEVELOPMENT

REV	ISSUED FOR	DATE


PLAN NORTH


TRUE NORTH

SCALE: 1/8"=1'-0"

0

8'

LIGHTHOUSE MISSION RE-BUILD

BUILDING SECTIONS

PROJECT No: 202009.02
DRAWN BY: AK
CHECKED BY: AK
DATE ISSUED: 07.10.22

A4.02


FINISH SCHEDULE: _____

SYM	FINISH	DESCRIPTION		REMARKS
B1	RUBBER BASE	MANUFACTURER:	TBD	CONCRETE
		COLOR:	TBD	
		SIZE:	6"H w/ TOE	
B2	INTEGRAL FLUID APPLIED BASE	MANUFACTURER:	TBD	
		COLOR:	TBD	
		SIZE:	6"H w/ TOE	
B3	INTEGRAL SHEET VINYL BASE	MANUFACTURER:	TBD	
		COLOR:	TBD	
		SIZE:	6"H w/ TOE	
B4	RUBBER BASE	MANUFACTURER:	TBD	CARPET
		COLOR:	TBD	
		SIZE:	6"H w/ TOE	
LVP	LUXURY VINYL PLANK	MANUFACTURER	TBD	
		STYLE	TBD	
		COLOR	TBD	
SV1	SHEET VINYL	MANUFACTURER	TBD	CLINIC
		STYLE	TBD	
		COLOR	TBD	
SV2	SHEET VINYL	MANUFACTURER	TBD	SHELTER KITCHENETTE
		STYLE	TBD	
		COLOR	TBD	
F1	FLUID APPLIED FLOOR	MANUFACTURER	TBD	
		STYLE	TBD	
		COLOR	TBD	
SC	SEALED CONCRETE	MANUFACTURER	TBD	
		STYLE	TBD	
		COLOR	TBD	
EC	EPOXY PAINT OVER CONCRETE	MANUFACTURER	TBD	
		STYLE	TBD	
		COLOR	TBD	
CT1	CARPET TILE	MANUFACTURER	TBD	CHAPEL
		STYLE	TBD	
		COLOR	TBD	
CT2	CARPET TILE	MANUFACTURER	TBD	OFFICE
		STYLE	TBD	
		COLOR	TBD	
	WALK OFF TILE	MANUFACTURER	TBD	
		STYLE	TBD	
		COLOR	TBD	
SS1	SOLID SURFACE	MANUFACTURER	CORIAN	NEW COUNTERTOPS AND BACKSPLASH
		COLOR	TBD	
SS2	SOLID SURFACE	MANUFACTURER	CORIAN	NEW COUNTERTOPS AND BACKSPLASH
		COLOR	TBD	

CT3	SOLID SURFACE	MANUFACTURER	CORIAN	NEW COUNTERTOPS AND BACKSPLASH
		COLOR	TBD	
PL1	PLASTIC LAMINATE	MANUFACTURER	TBD	CASEWORK
		COLOR	TBD	
PL2	PLASTIC LAMINATE	MANUFACTURER	TBD	CASEWORK
		COLOR	TBD	
W1	FIBER REINFORCE D LAMINATE	MANUFACTURER	TBD	WAINSCOT, 4'-0" AFF, ADMIN AREA
		COLOR	TBD	
W2	FIBER REINFORCE D PANEL	MANUFACTURER	TBD	WAINSCOT, 4'-0" AFF, CLINIC
		COLOR	TBD	
W3	FIBER REINFORCE D PANEL	MANUFACTURER	TBD	WAINSCOT, 4'-0" AFF, DORMS, CHAPEL
		COLOR	TBD	
W4	FIBER REINFORCE D PANEL	MANUFACTURER	TBD	KITCHEN,8'-0" A.F.F.
		COLOR	TBD	
W5	FIBER REINFORCE D PANEL	MANUFACTURER	TBD	WALLCOVERING, FULL HEIGHT, RESTROOMS
		COLOR	TBD	
W6	THERMOPLASTIC RIGID SHEET	MANUFACTURER	ACROVYN	WALLCOVERING, FULL HEIGHT SERVICE AREAS
		COLOR	TBD	
W7	THERMOPLASTIC RIGID SHEET	MANUFACTURER	TBD	WAINSCOT, 4'-0" AFF, DAYROOM
		COLOR	TBD	
W8	PLYWOOD OVER GYP. BD.	MANUFACTURER	TBD	8'-0" A.F.F. UTILITY
		COLOR	TBD	
W9	THERMOPLASTIC RIGID SHEET	MANUFACTURER	TBD	WAINSCOT, 4'-0" AFF, FAMILY SPACES
		COLOR	TBD	
P1	PAINT	MANUFACTURER:	TBD	WALLS THROUGHOUT, U.N.O.
		COLOR:	TBD	
P2	PAINT	MANUFACTURER:	TBD	DOOR FRAMES
		COLOR:	TBD	
P3	PAINT	MANUFACTURER:	TBD	
		COLOR:	TBD	
P4	PAINT	MANUFACTURER:	TBD	
		COLOR:	TBD	
P5	PAINT	MANUFACTURER:	TBD	
		COLOR:	TBD	
P6	PAINT	MANUFACTURER:	TBD	
		COLOR:	TBD	
P7	PAINT	MANUFACTURER:	TBD	
		COLOR:	TBD	
P8	PAINT	MANUFACTURER:	TBD	
		COLOR:	TBD	




ARCHITECTURE | INTERIOR DESIGN
zervasgroup.com
209 Prospect Street
Bellingham, WA 98225
360.734.4744

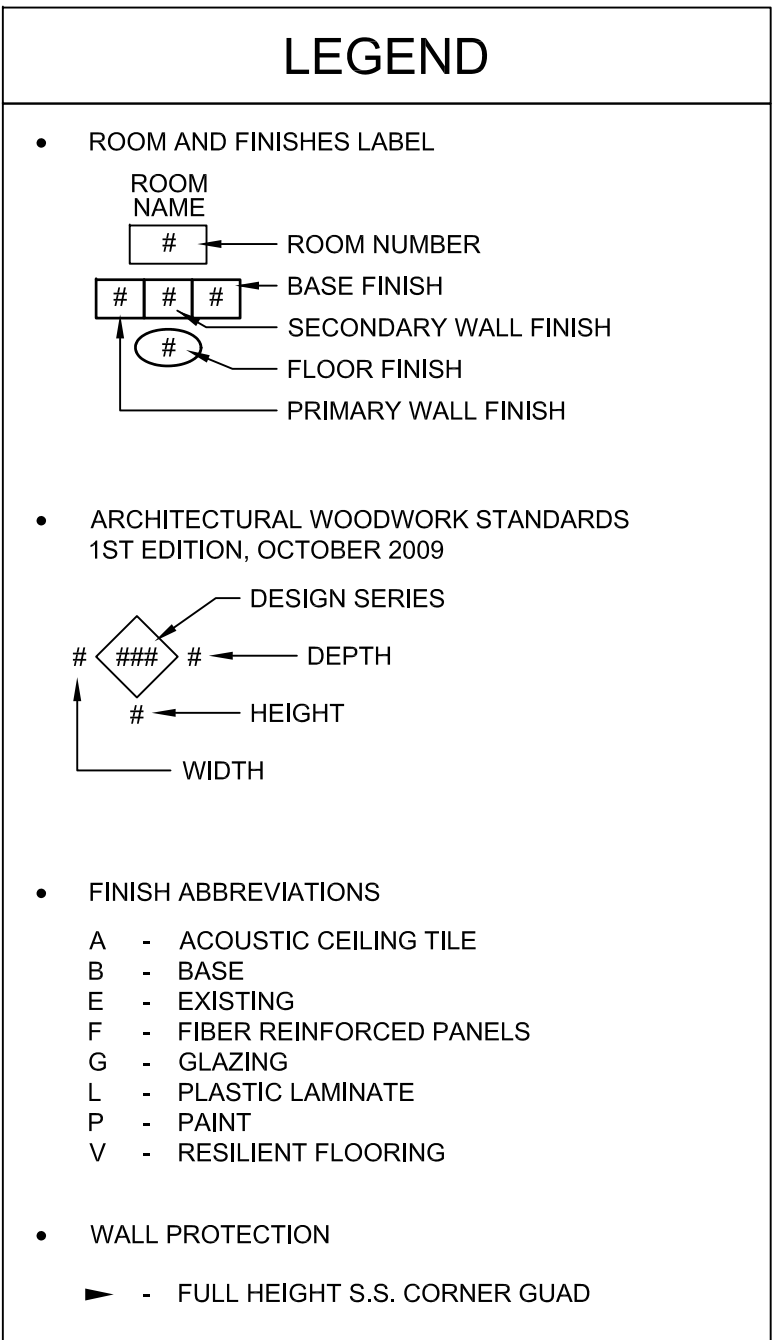

DESIGN DEVELOPMENT

REV	ISSUED FOR	DATE

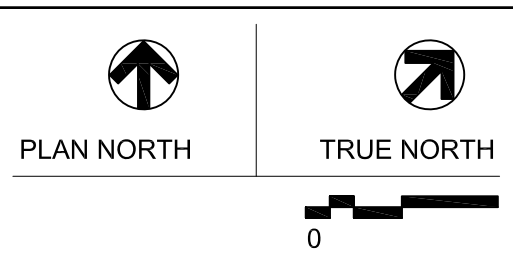

LIGHTHOUSE MISSION RE-BUILD


FINISH SCHEDULE AND FINISH NOTES

PROJECT No:	202009.02
DRAWN BY:	AK
CHECKED BY:	AK
DATE ISSUED:	07.10.22

A5.00




ARCHITECTURE | INTERIOR DESIGN
zervasgroup.com
209 Prospect Street
Bellingham, WA 98225
360.734.4744

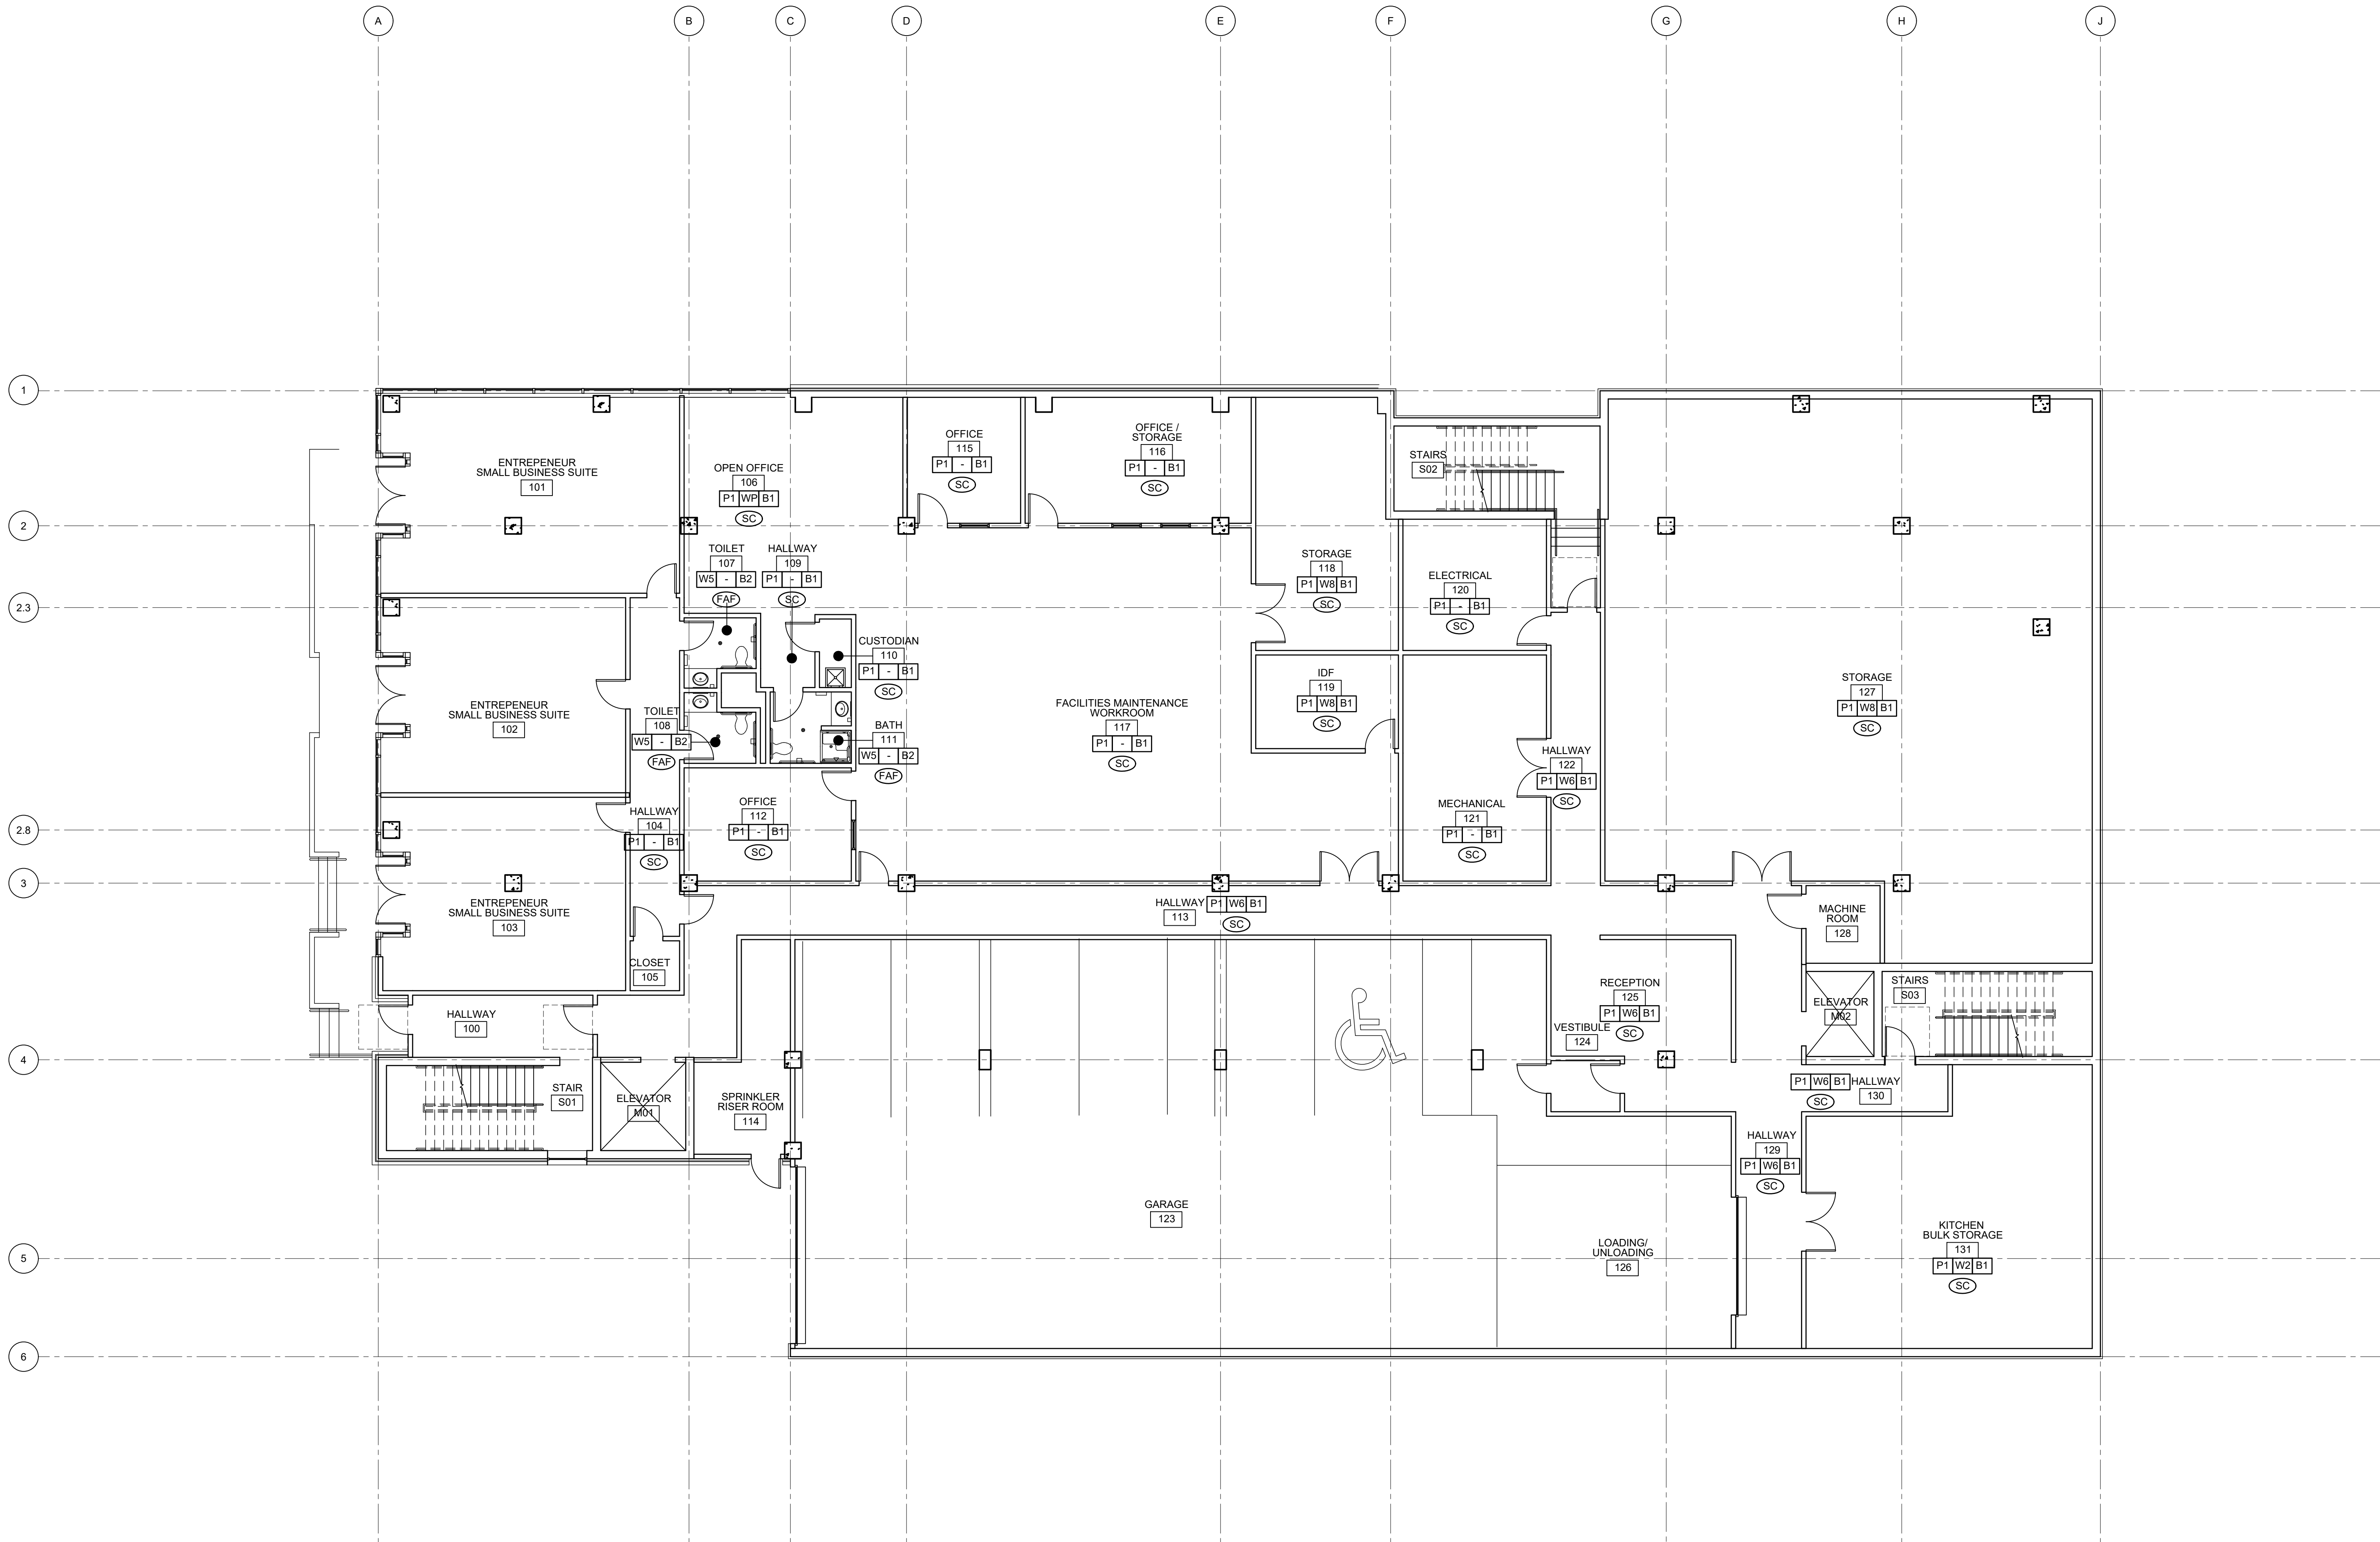

DESIGN DEVELOPMENT

REV	ISSUED FOR	DATE

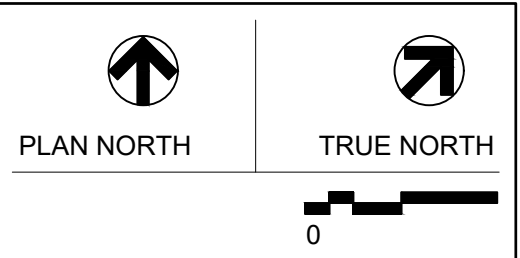


LIGHTHOUSE MISSION RE-BUILD

FIRST FLOOR FINISH PLAN


PROJECT No: 202009.02
DRAWN BY: AK
CHECKED BY: AK
DATE ISSUED: 07.10.22

A5.01

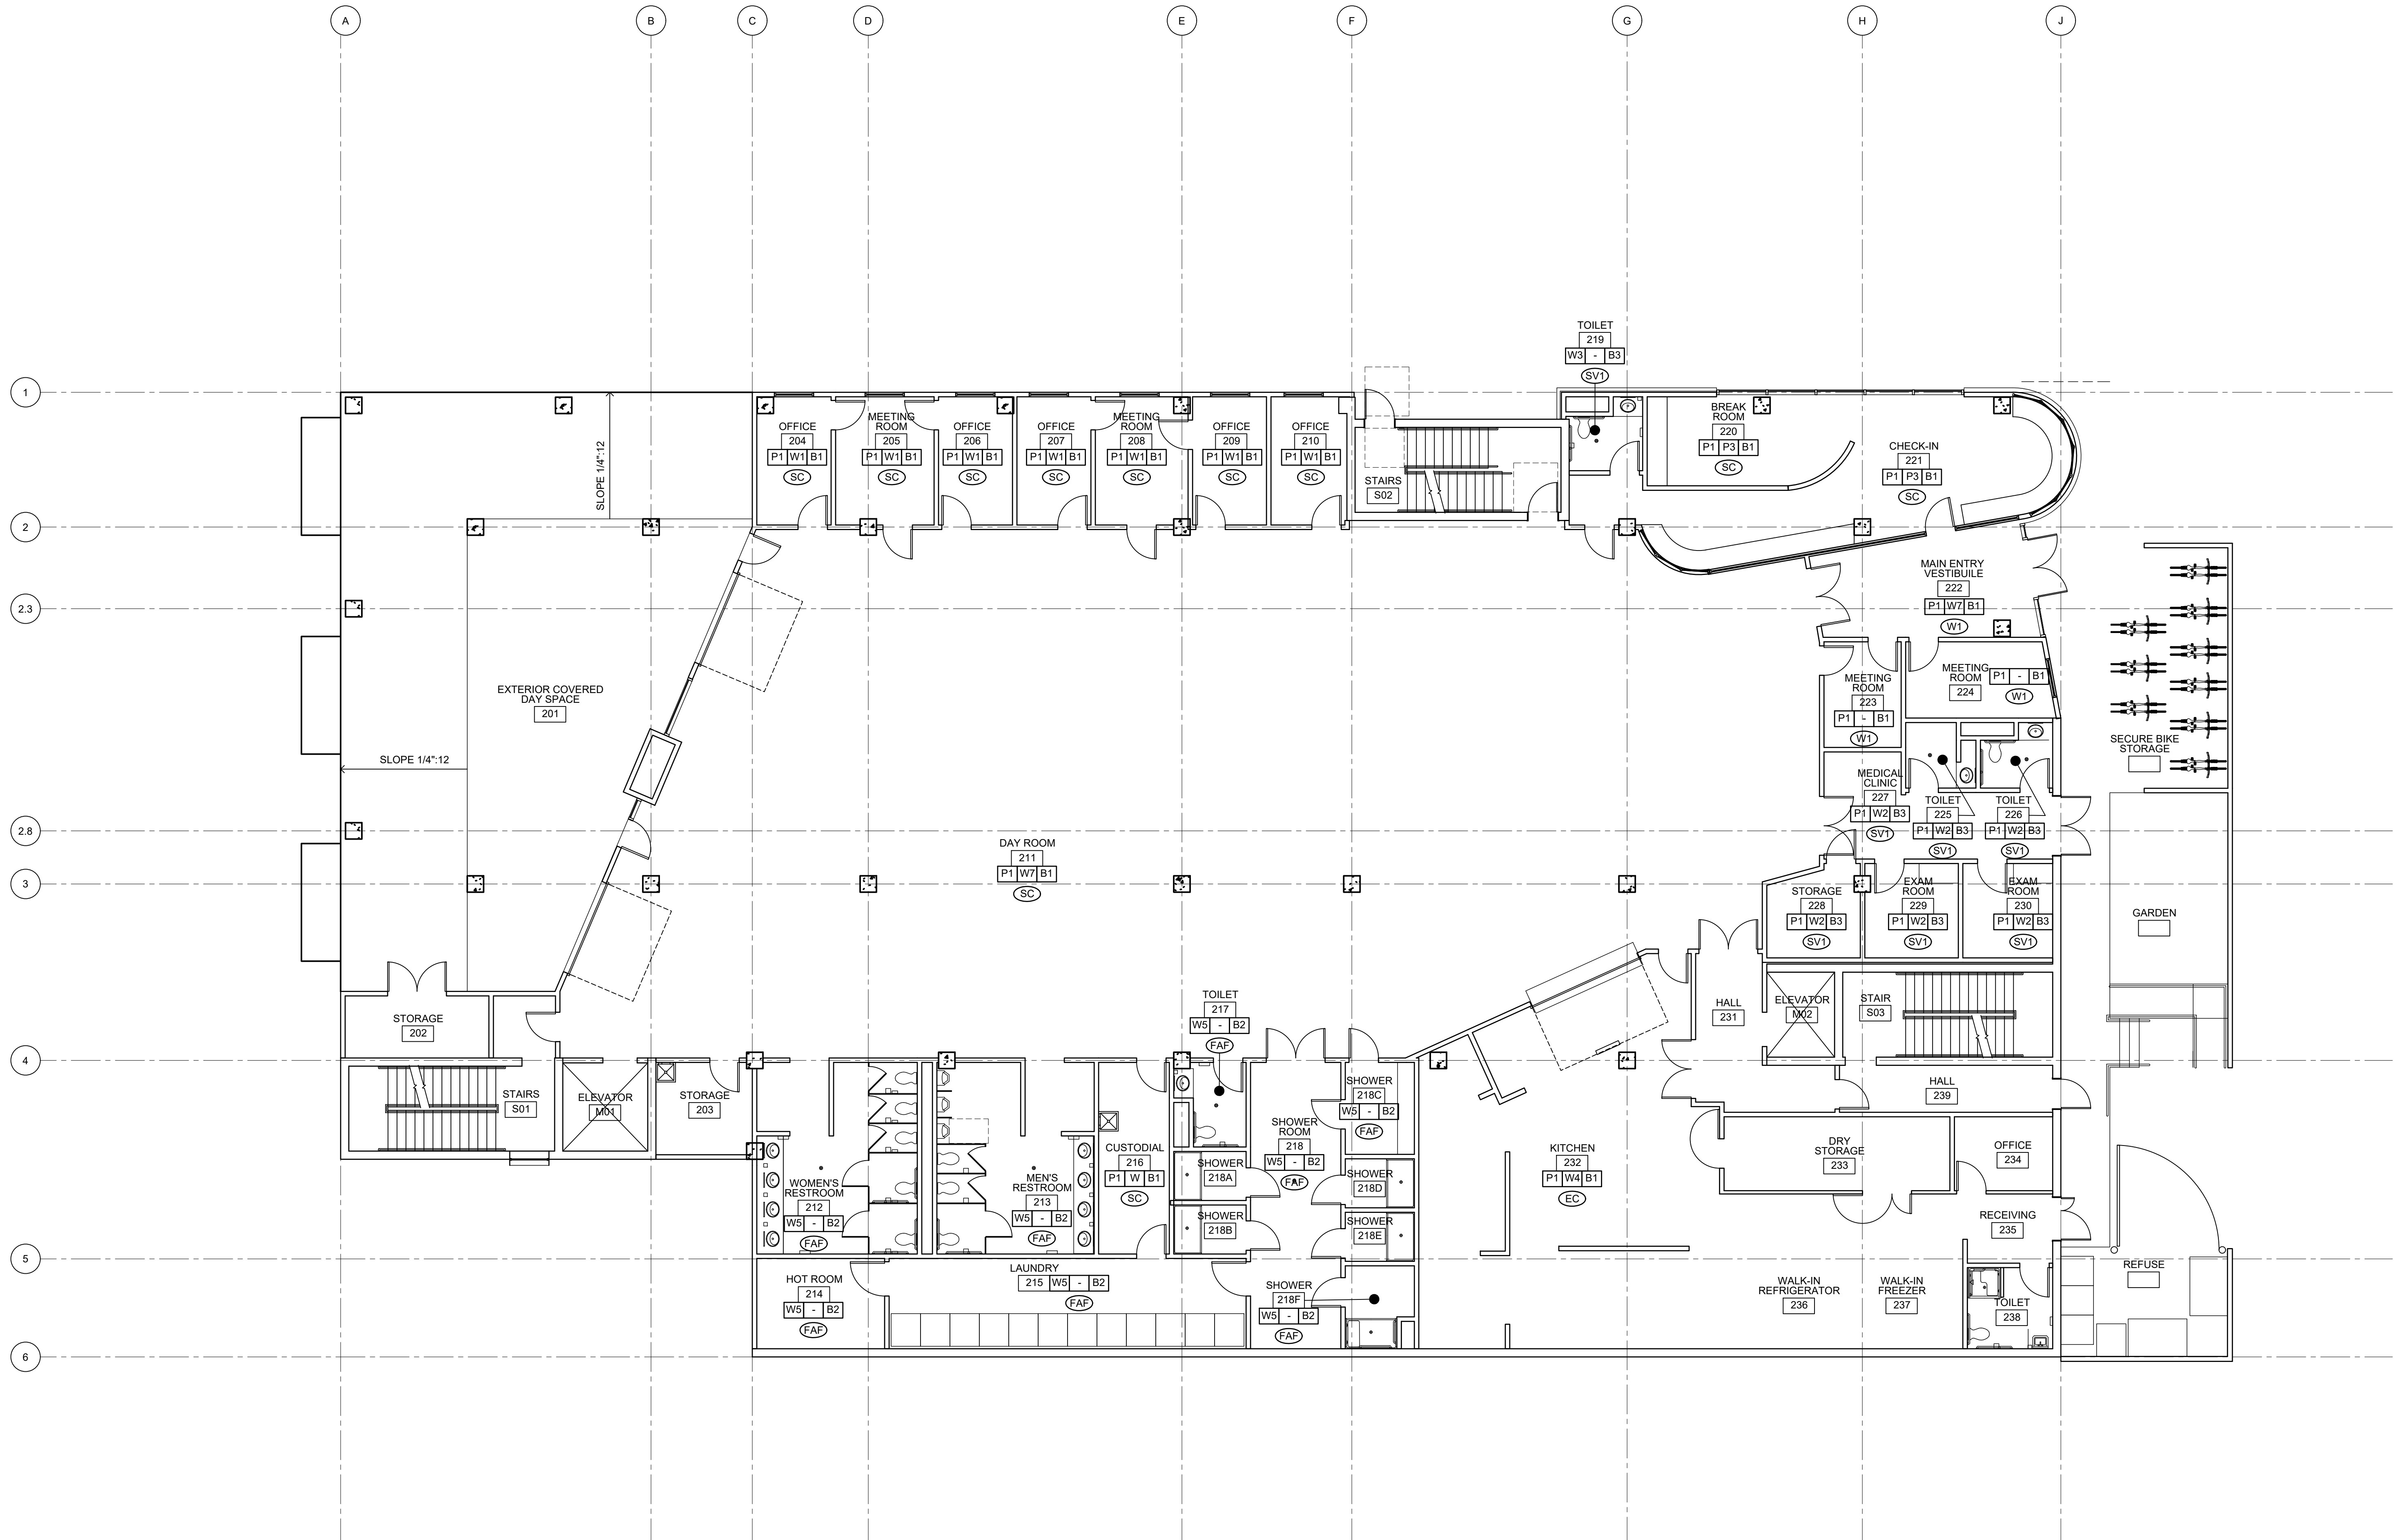

DESIGN
DEVELOPMENT

REV	ISSUED FOR	DATE

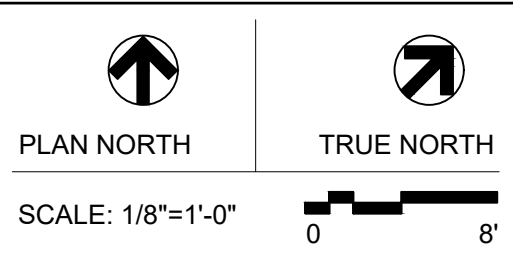

LIGHTHOUSE
MISSION
RE-BUILD


SECOND FLOOR
FINISH PLAN

PROJECT No: 202009.02
DRAWN BY: AK
CHECKED BY: AK
DATE ISSUED: 07.10.22

A5.02



ARCHITECTURE | INTERIOR DESIGN
zervasgroup.com
209 Prospect Street
Bellingham, WA 98225
360.734.4744

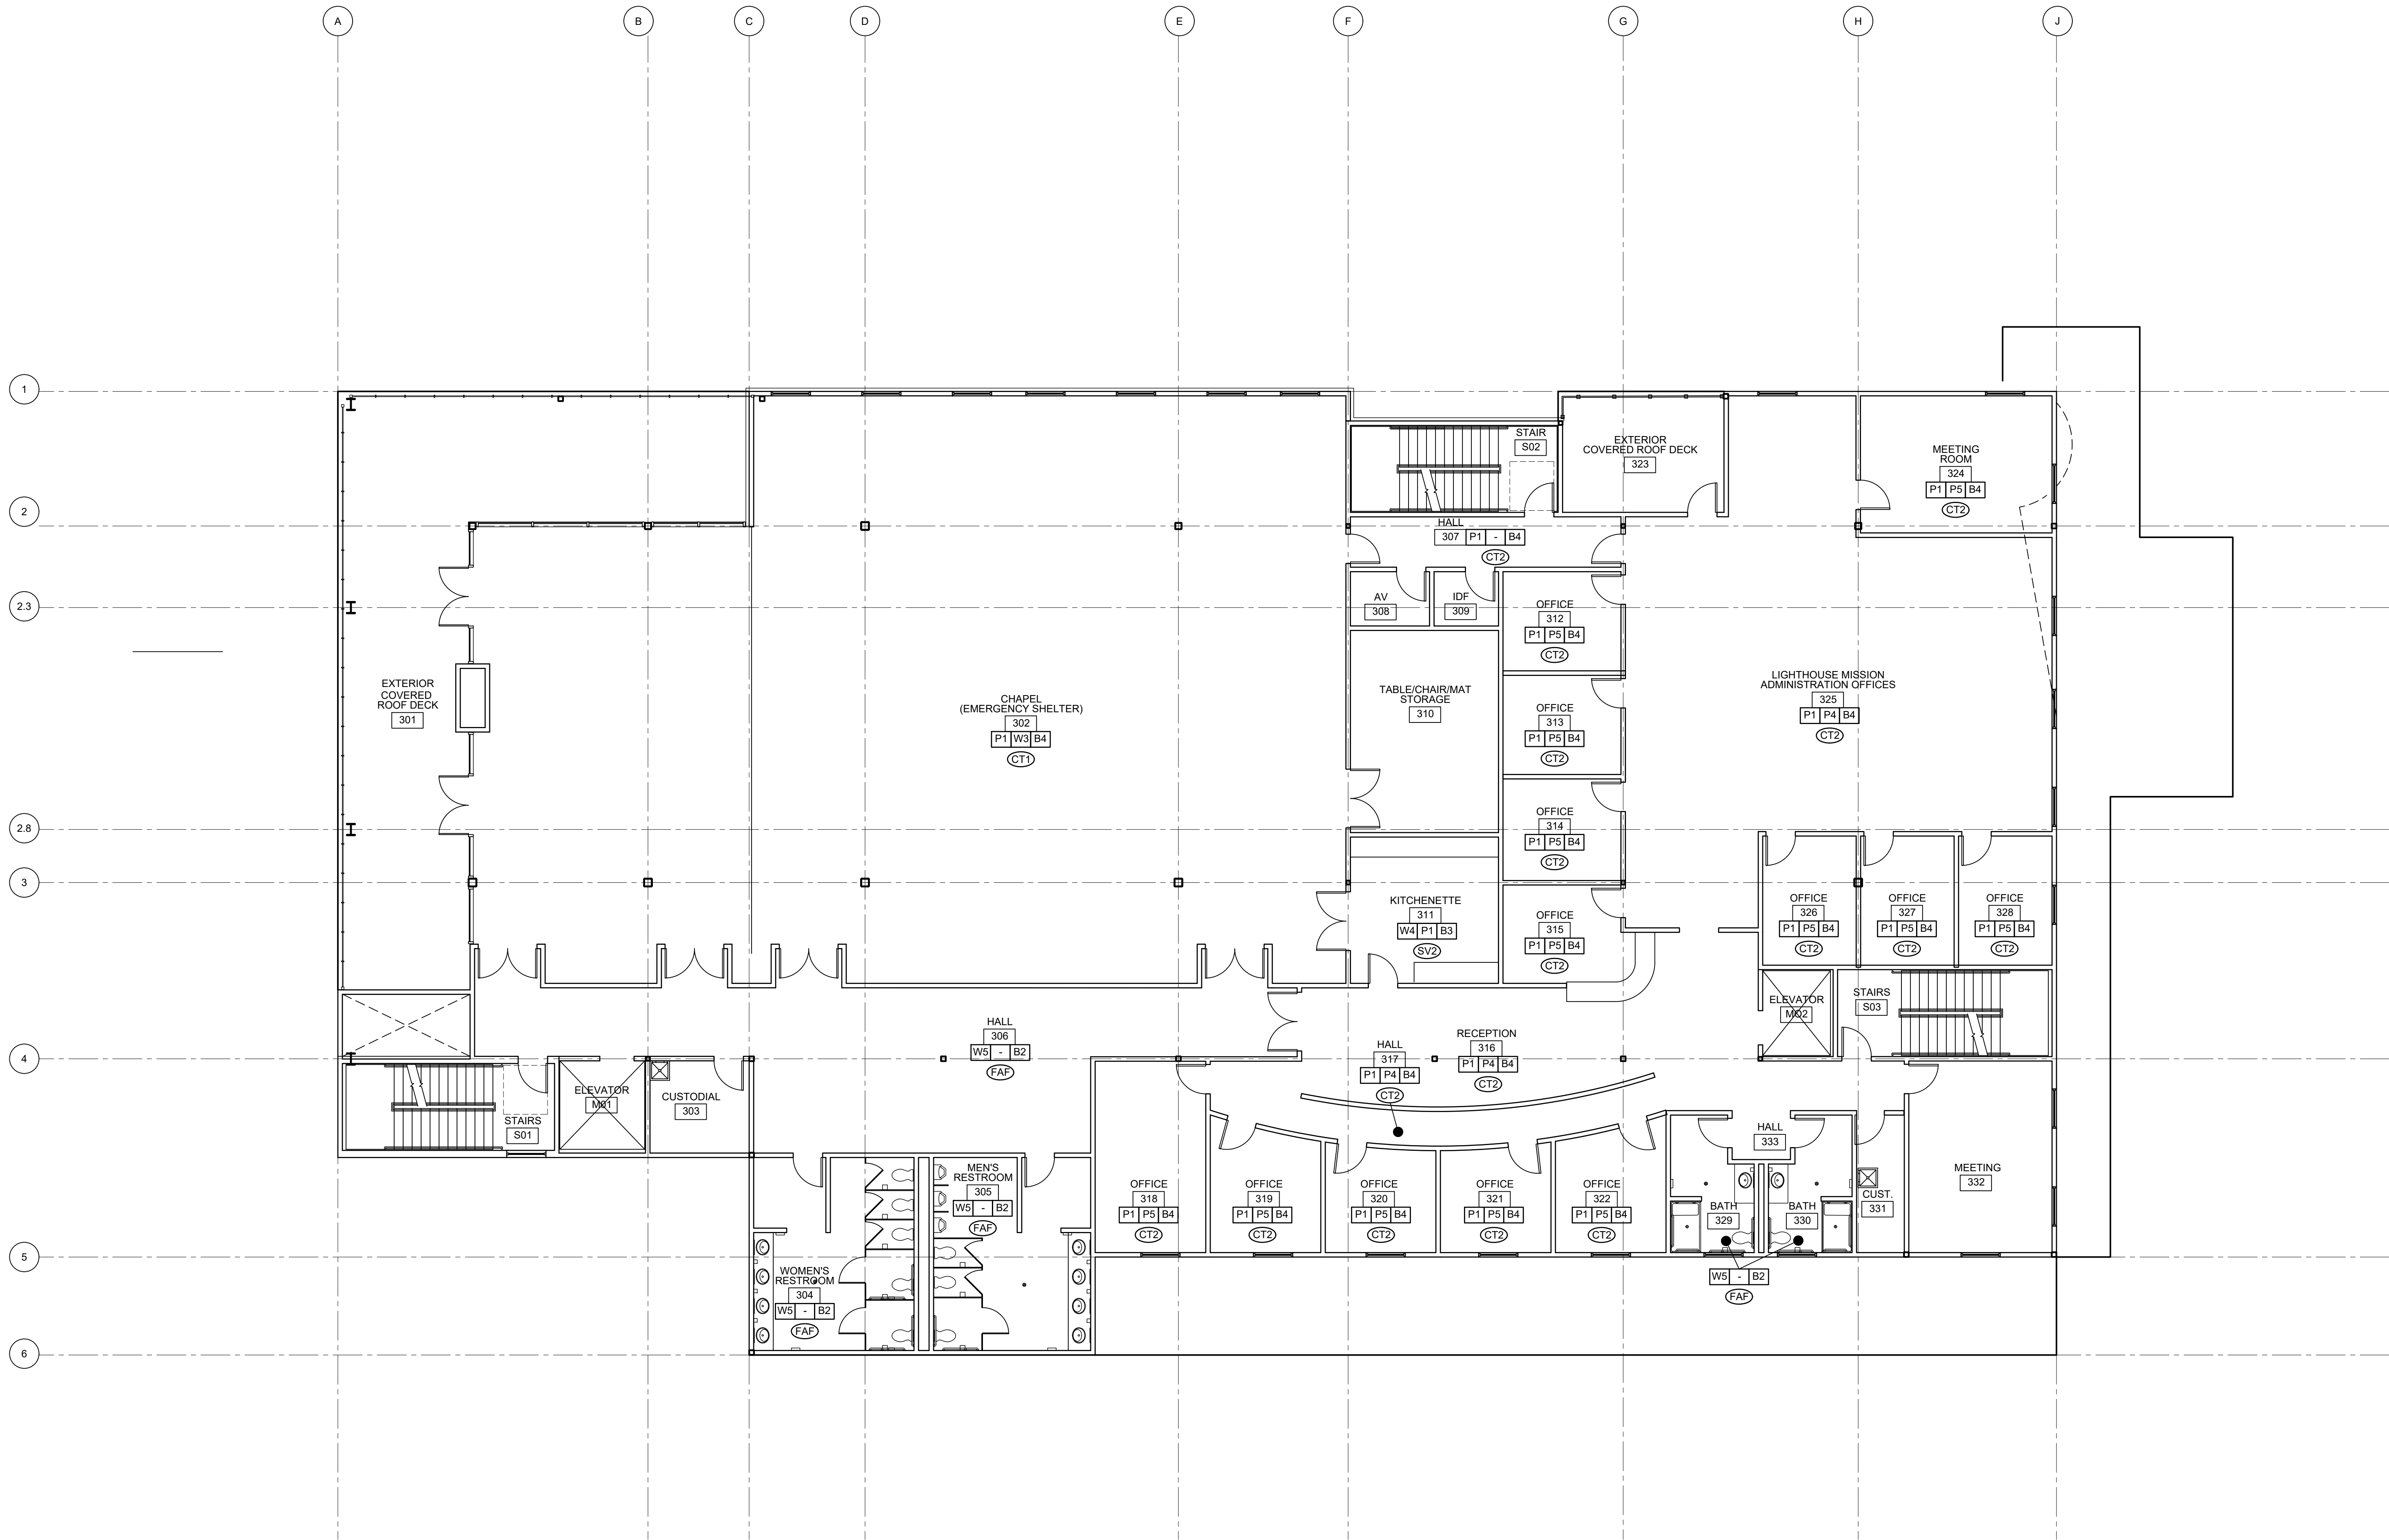

DESIGN DEVELOPMENT

REV	ISSUED FOR	DATE


PLAN NORTH


TRUE NORTH

SCALE: 1/8"=1'-0"



LIGHTHOUSE MISSION RE-BUILD


THIRD FLOOR FINISH PLAN

PROJECT No: 202009.02
DRAWN BY: AK
CHECKED BY: AK
DATE ISSUED: 07.10.22

A5.03



ARCHITECTURE | INTERIOR DESIGN
zervasgroup.com
209 Prospect Street
Bellingham, WA 98225
360.734.4744

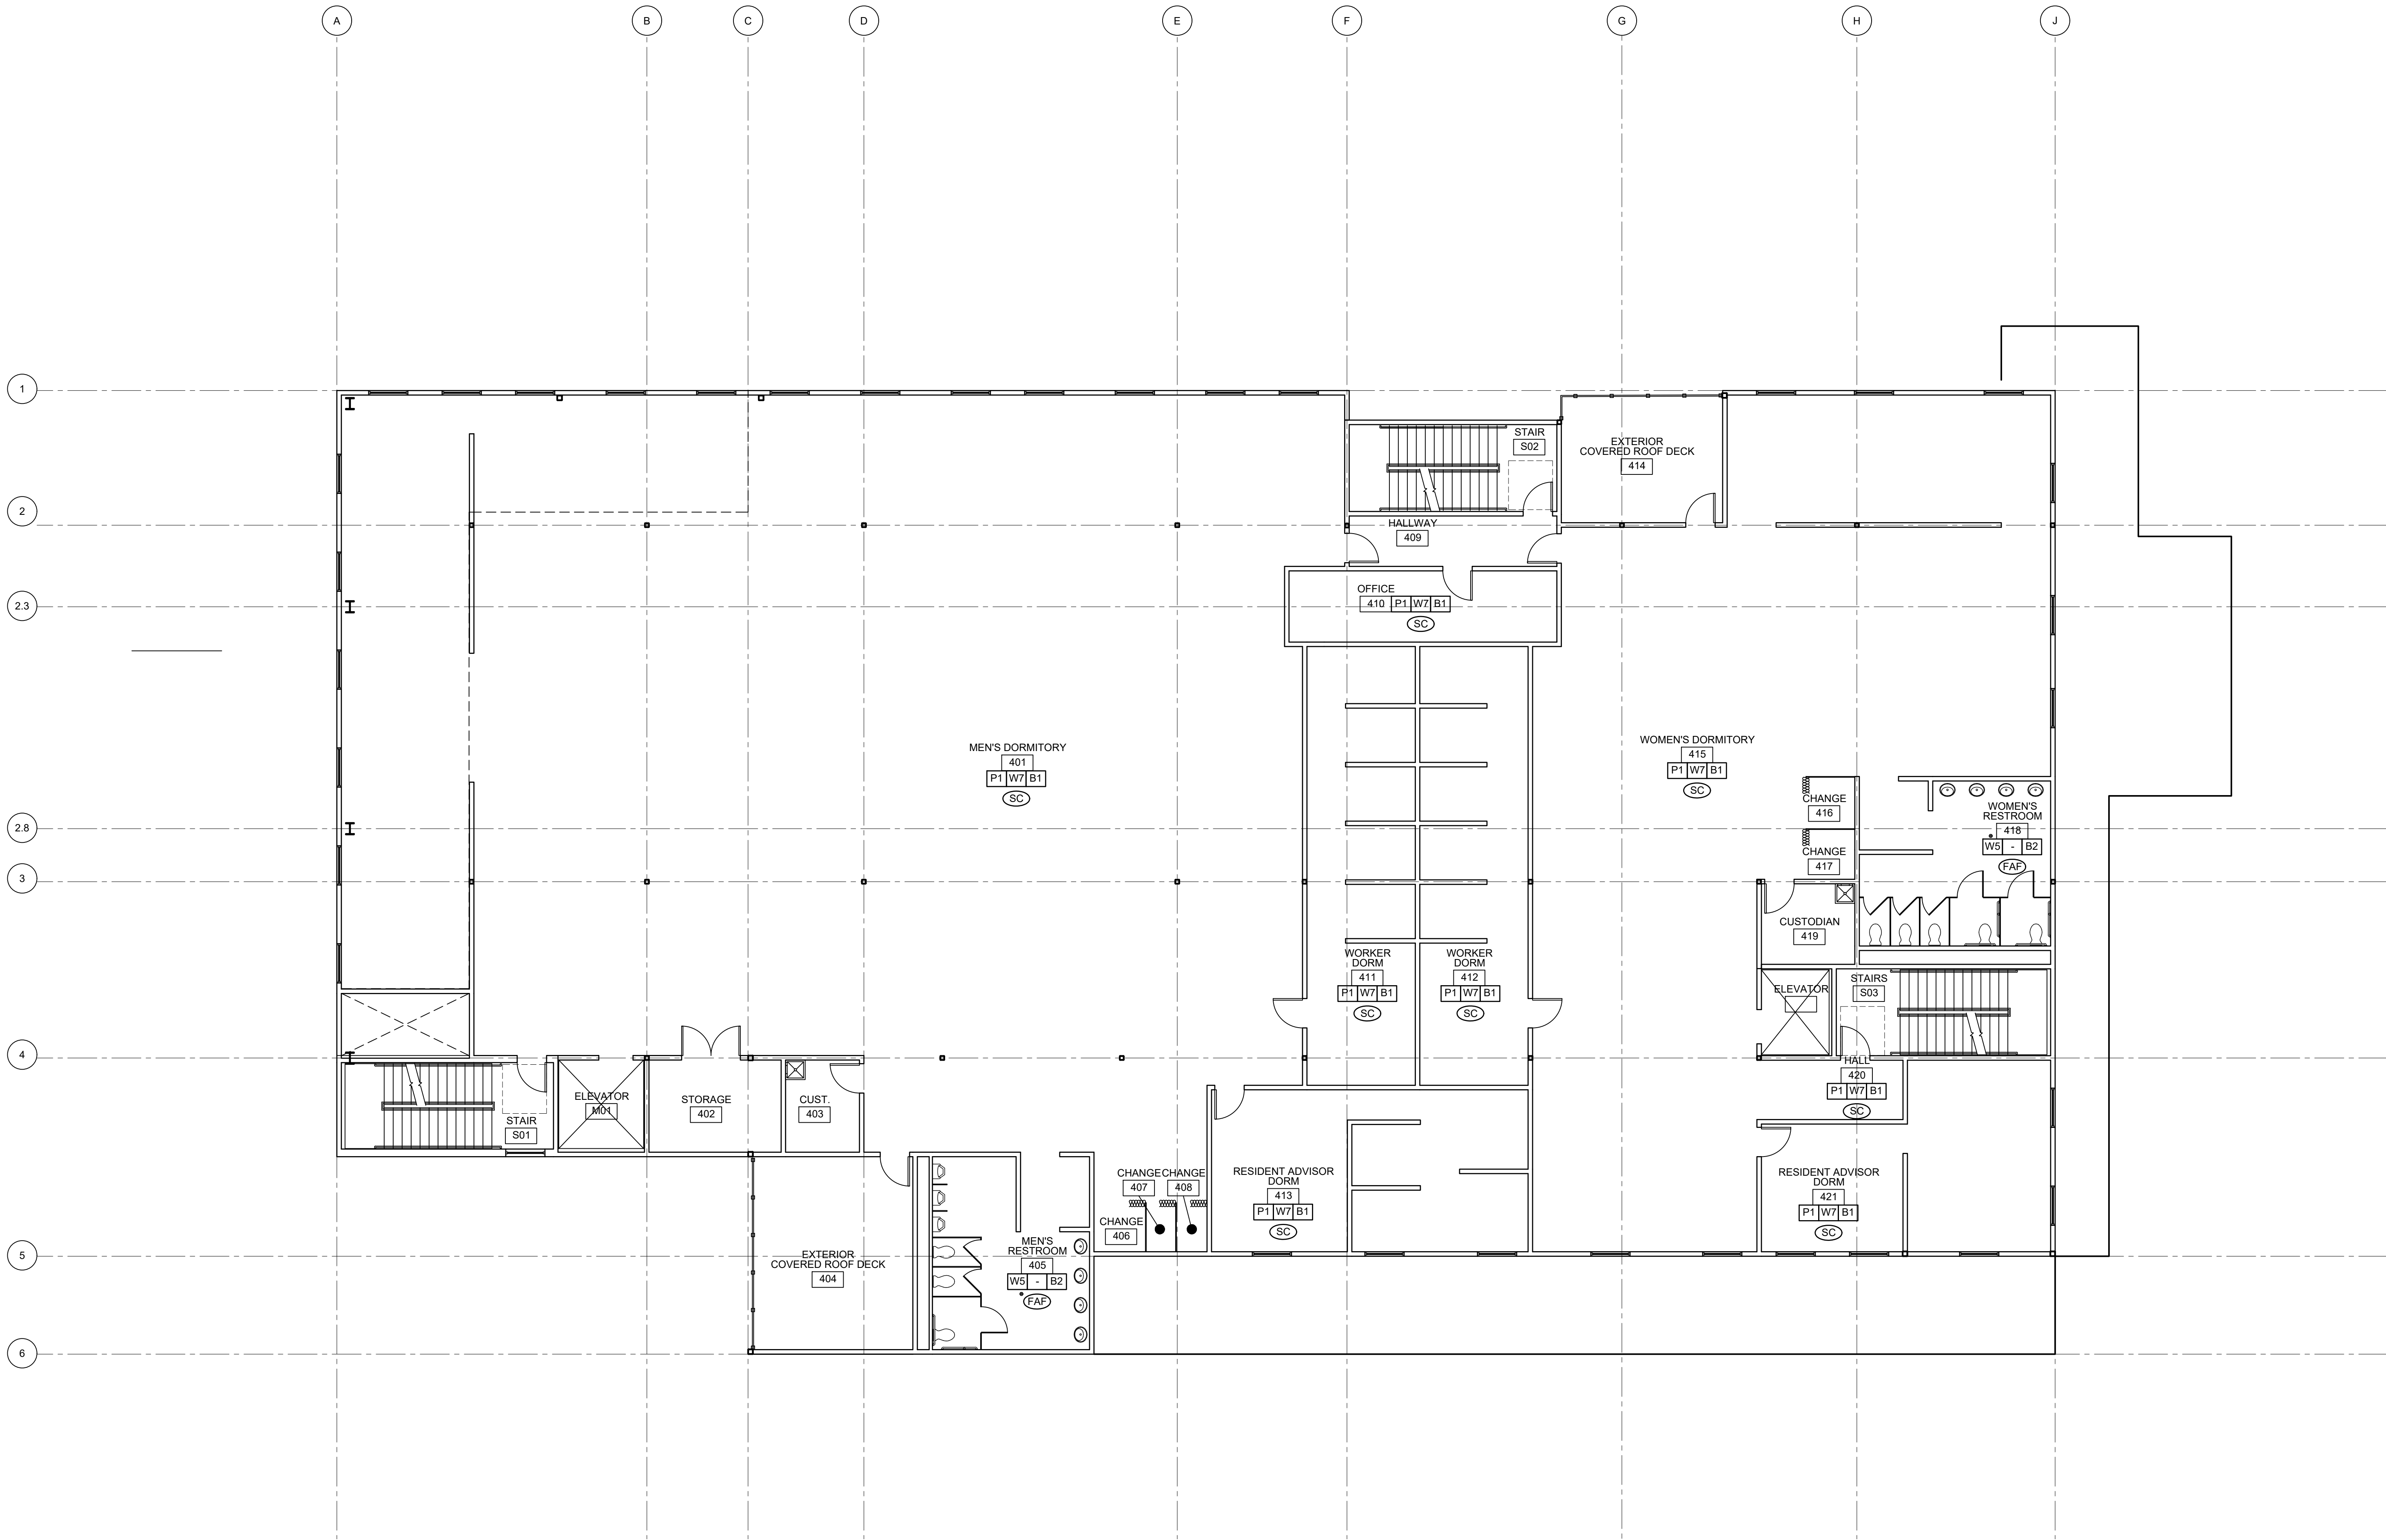

DESIGN DEVELOPMENT

REV	ISSUED FOR	DATE


PLAN NORTH


TRUE NORTH

SCALE: 1/8"=1'-0"


0 8'

LIGHTHOUSE MISSION RE-BUILD


FOURTH FLOOR FINISH PLAN

PROJECT No: 202009.02
DRAWN BY: AK
CHECKED BY: AK
DATE ISSUED: 07.10.22

A5.04



REV	ISSUED FOR	DATE

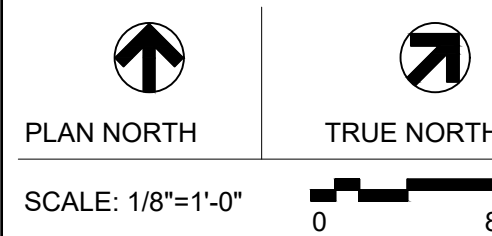

LIGHTHOUSE
MISSION
RE-BUILD


FIFTH FLOOR FINISH PLAN

PROJECT No:	202009.02
DRAWN BY:	AK
CHECKED BY:	AK
DATE ISSUED:	07.10.22


A5.05




ARCHITECTURE | INTERIOR DESIGN
zervasgroup.com
209 Prospect Street
Bellingham, WA 98225
360.736.4764

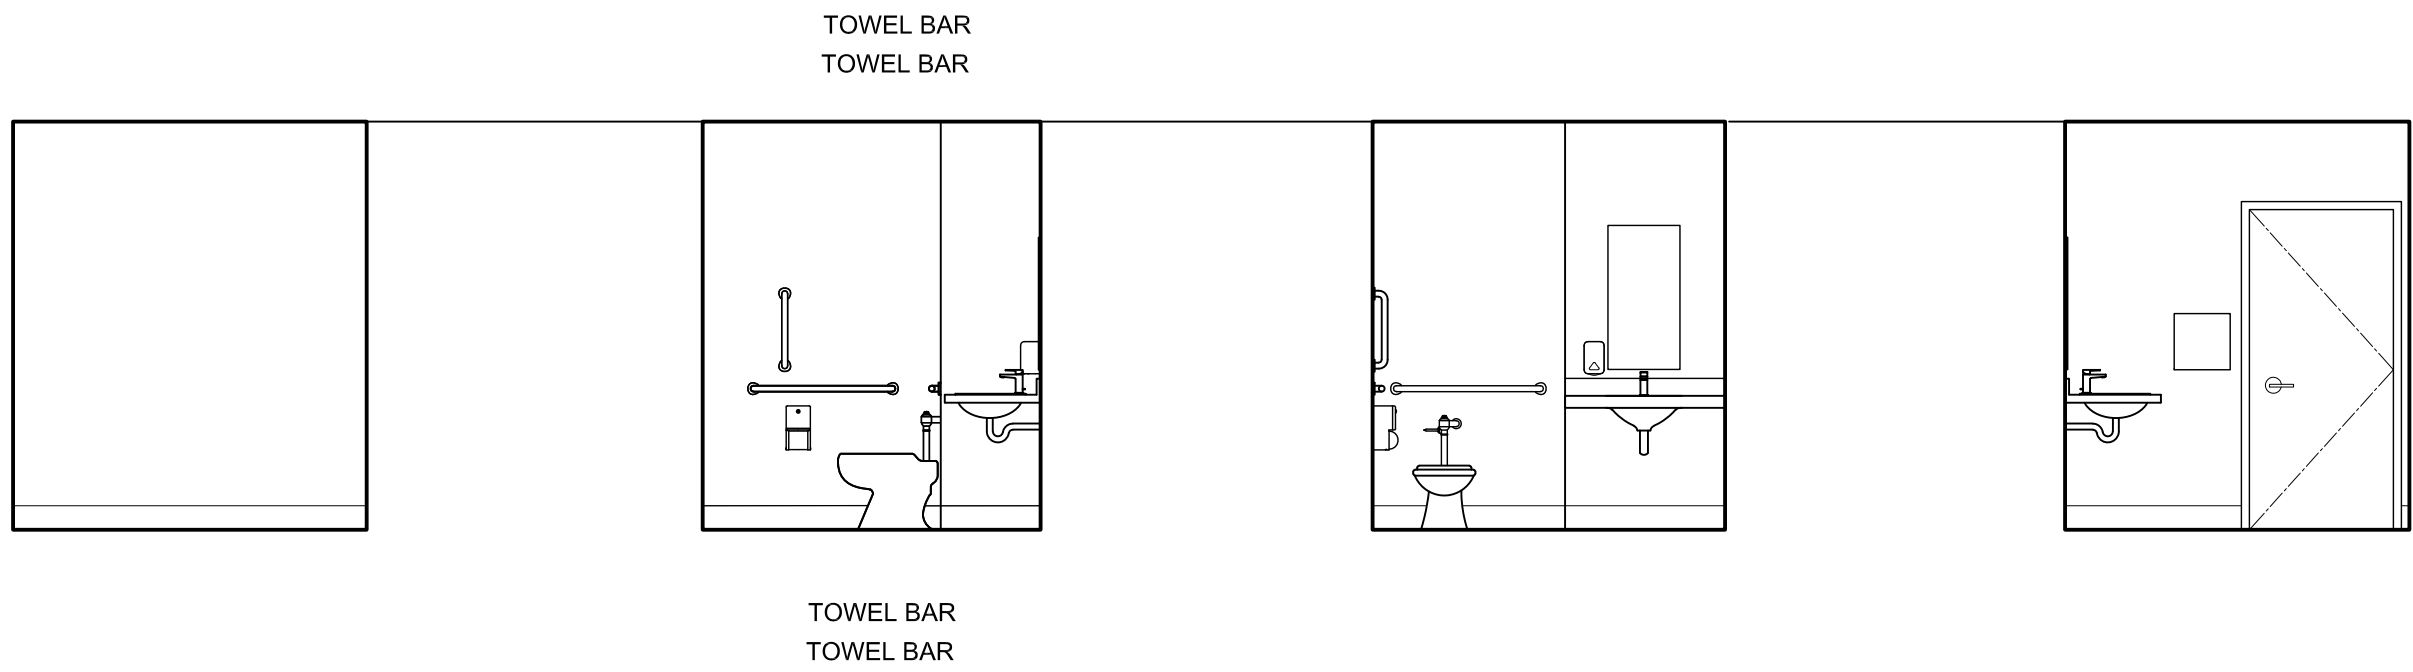


1 TOILET 107, 108 (O.H.)
1/4" = 1'-0"

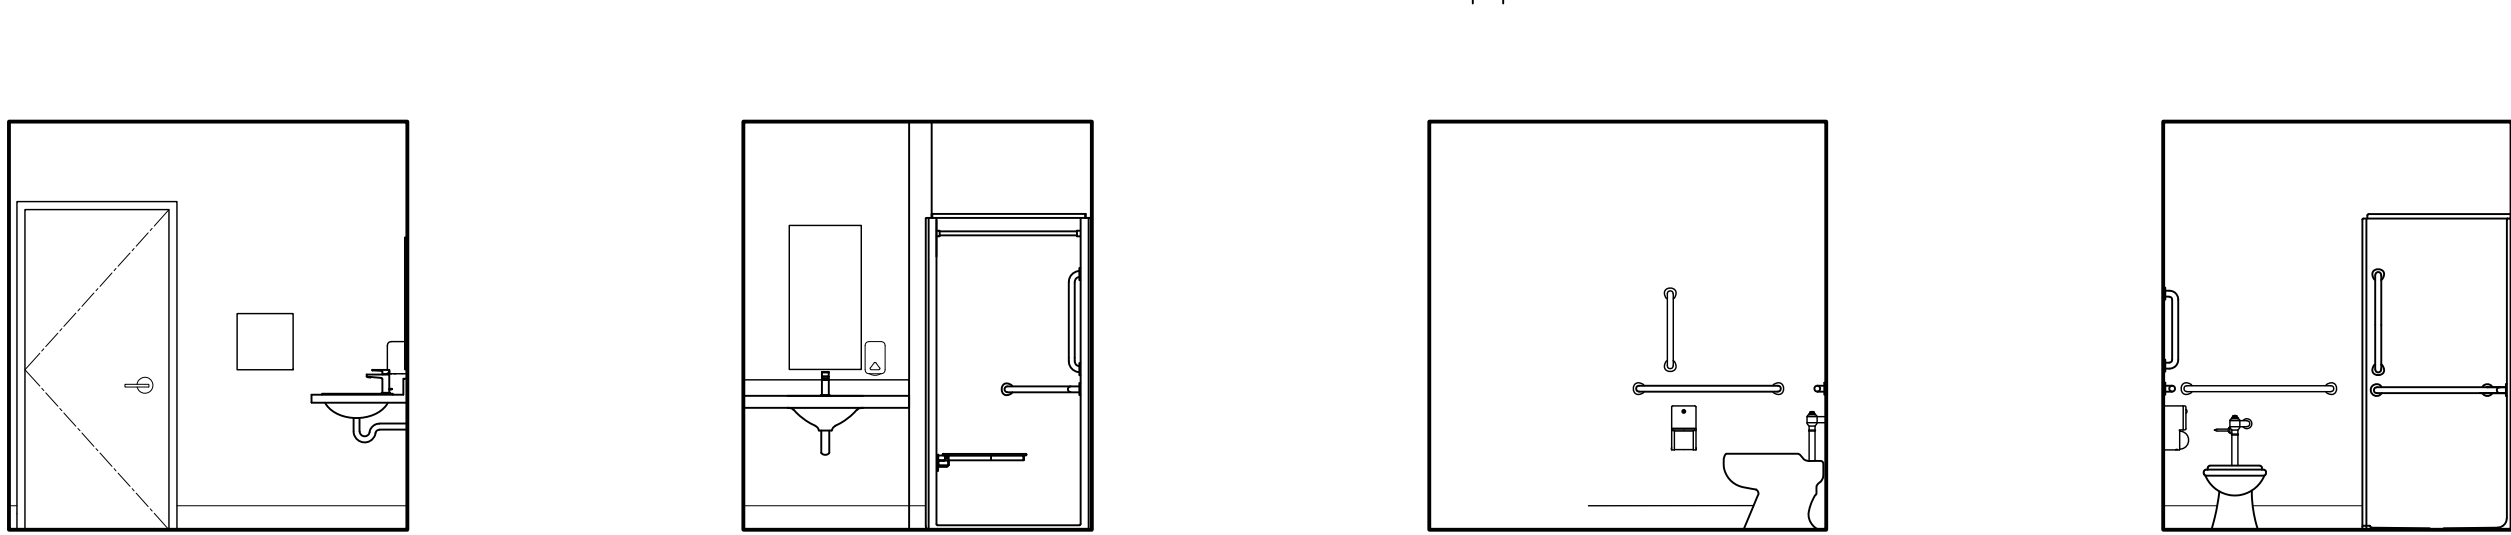


2 109 BATH
1/4" = 1'-0"

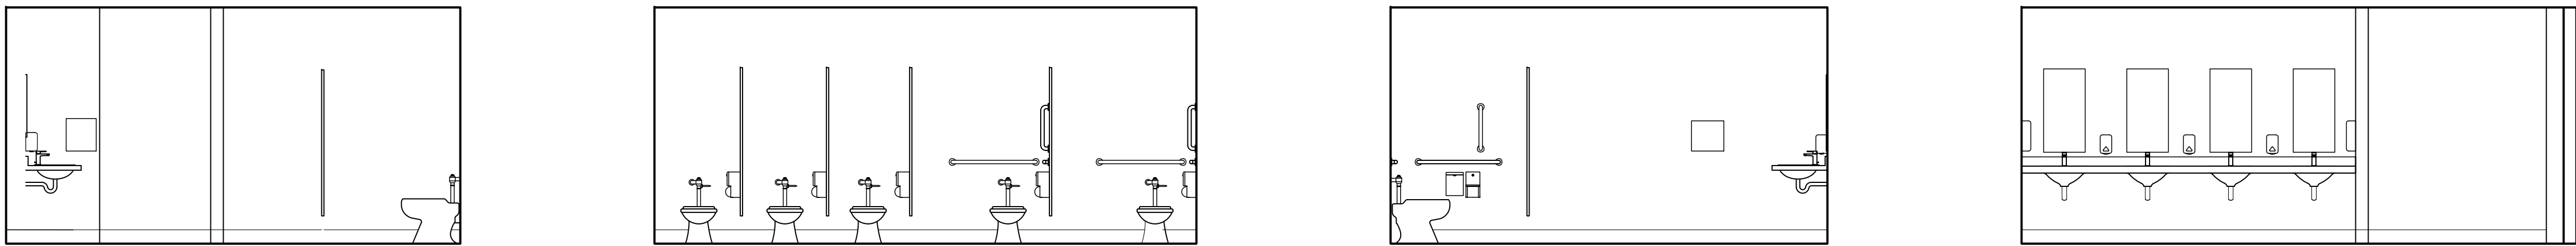


3 WOMEN'S 212, 304 (SIM), 418 (SIM, O.H.)
1/4" = 1'-0"

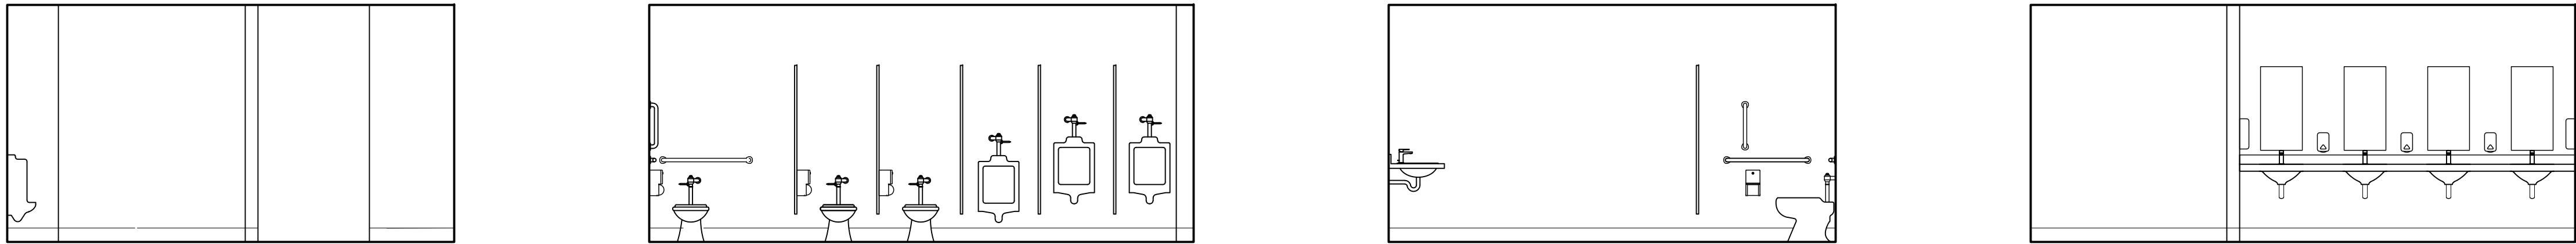

4 MEN'S 213, 305 (SIM), 405
1/4" = 1'-0"

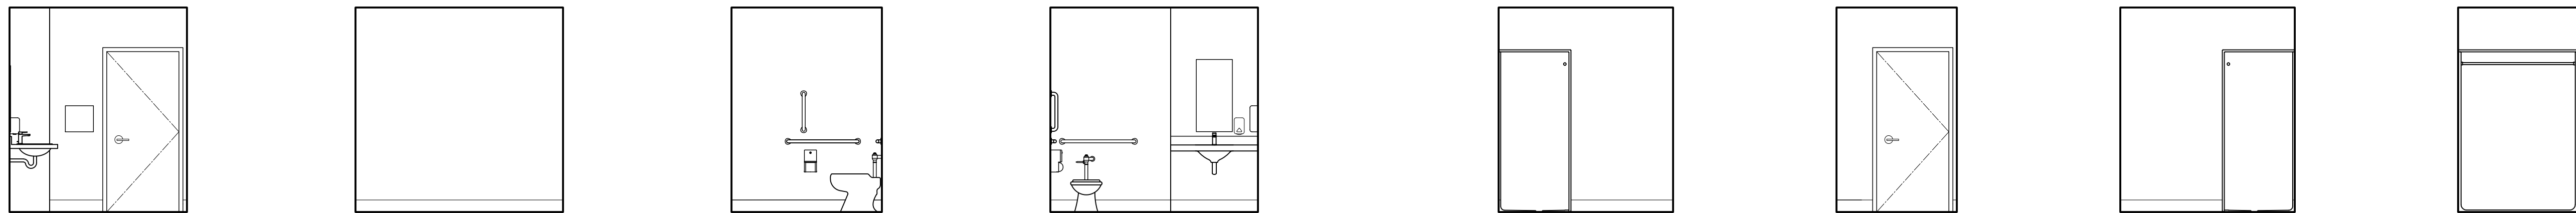

5 TOILET 217
1/4" = 1'-0"

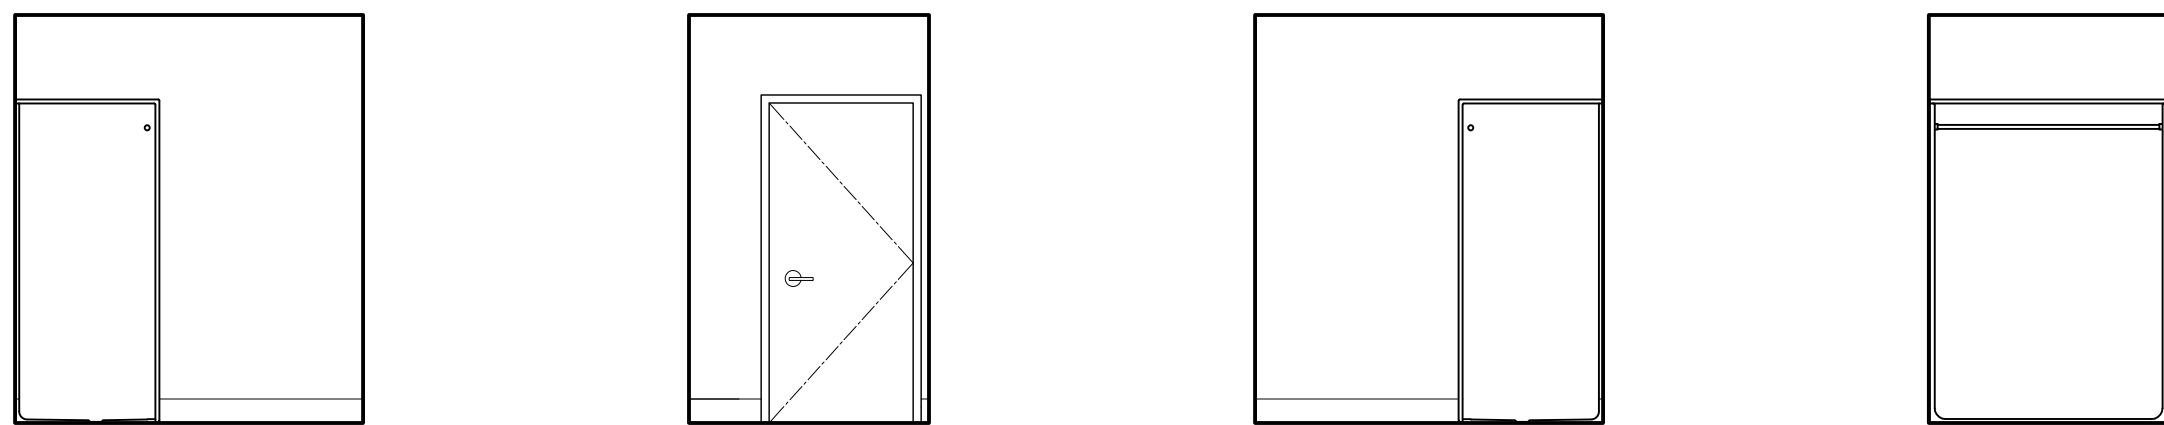

6 SHOWER 218A, 218B, 218D (O.H.), 218E (O.H.)
1/4" = 1'-0"




7 TOWEL 218 C
1/4" = 1'-0"

8 SHOWER 218F
1/4" = 1'-0"

DESIGN DEVELOPMENT

REV	ISSUED FOR	DATE

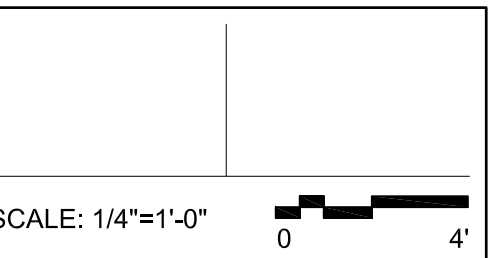


LIGHTHOUSE MISSION RE-BUILD

INTERIOR ELEVATIONS

PROJECT No: 202009.02
DRAWN BY: AK
CHECKED BY: AK
DATE ISSUED: 07.10.22


A6.01

© 2019

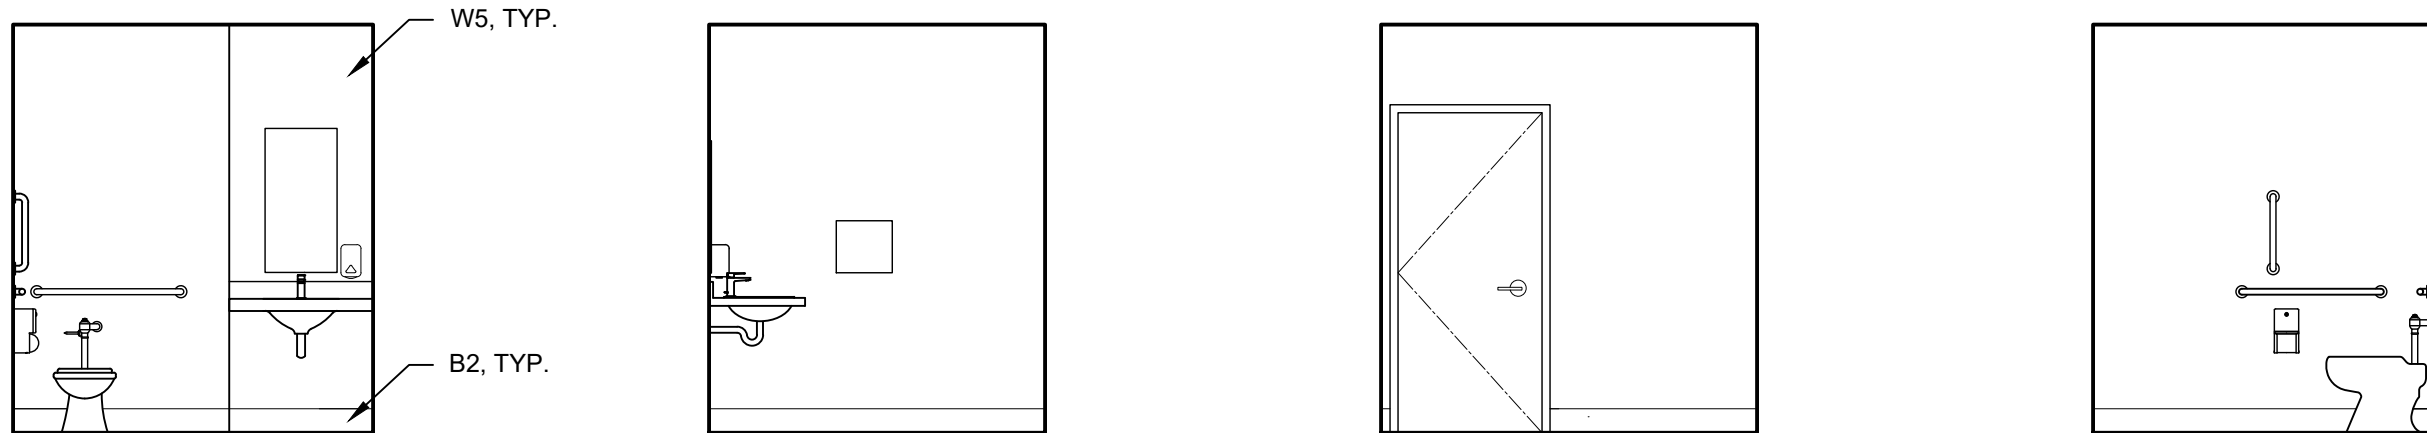


8 TOILET 219
1/4" = 1'-0"

2 TOILET 225
1/4" = 1'-0"

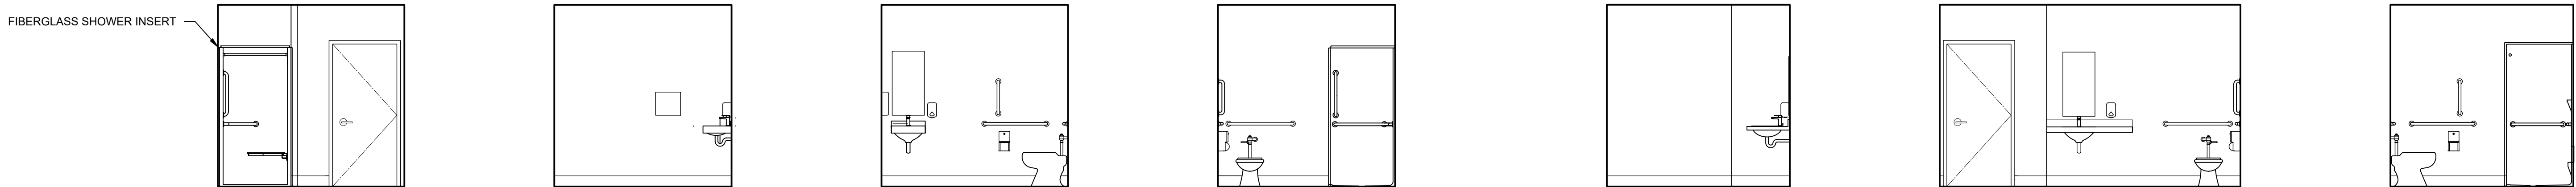


3 BATH 238
1/4" = 1'-0"

4 BATH 329, 330 (O.H.)
1/4" = 1'-0"

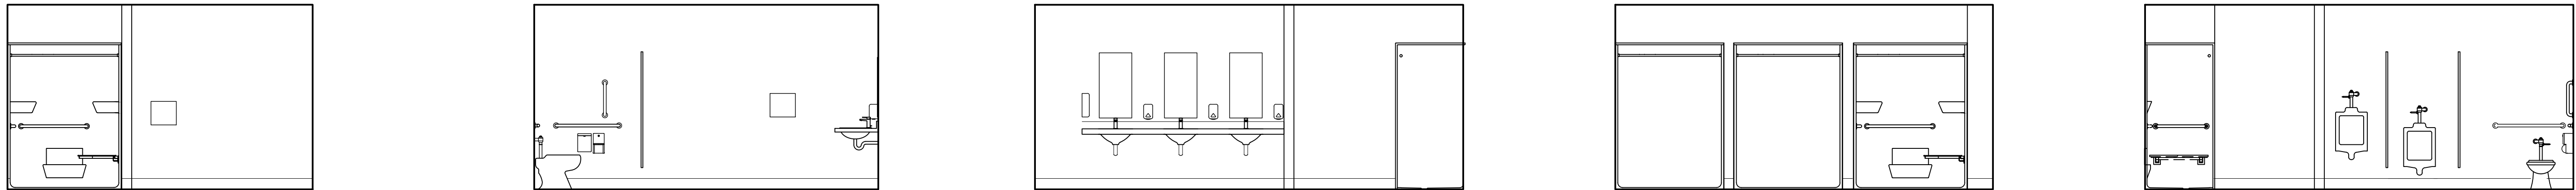

4 BATH 329, 330 (O.H.) CONTINUED
1/4" = 1'-0"

5 MEN'S 511
1/4" = 1'-0"

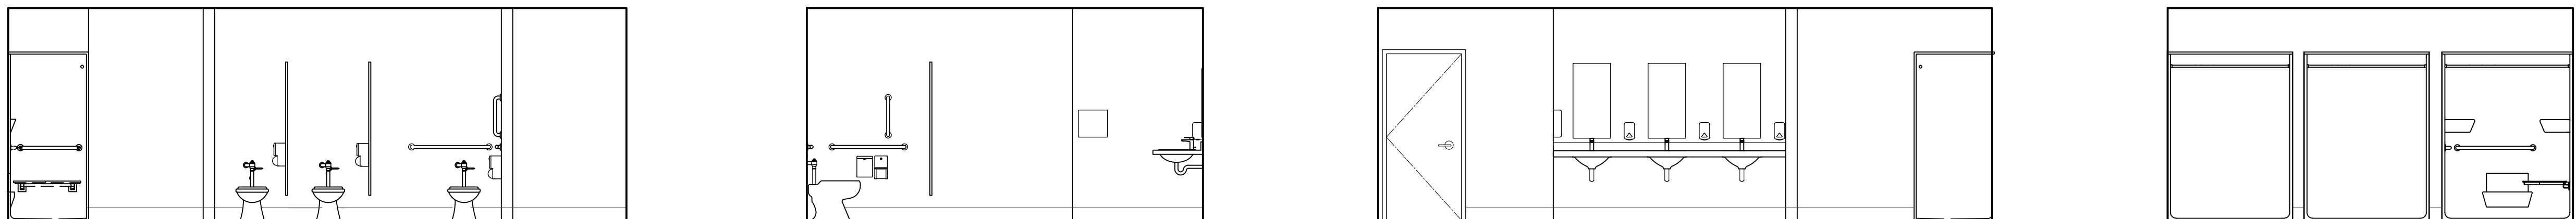

6 WOMEN'S 512
1/4" = 1'-0"




7 TOILET 508, 509 (O.H.)
1/4" = 1'-0"

8 BATHROOMS 528, 530, 527 (O.H.), 529 (O.H.)
1/4" = 1'-0"

DESIGN
DEVELOPMENT

REV	ISSUED FOR	DATE

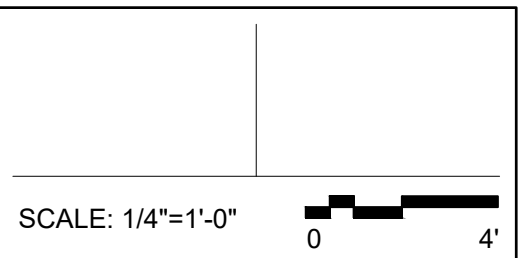

LIGHTHOUSE
MISSION
RE-BUILD

INTERIOR
ELEVATIONS

PROJECT No:	202009.02
DRAWN BY:	AK
CHECKED BY:	AK
DATE ISSUED:	07.10.22